

REISSUED FOR DEVELOPMENT PERMIT
APRIL 11, 2022



257 BELLEVILLE STREET
VICTORIA, BRITISH COLUMBIA

Prepared for the City of Victoria on behalf of ADZ Properties Ltd.

Client ■ ADZ Properties Ltd. #517 - 1177 West Hastings Street Vancouver, British Columbia V6E 2K3	Architectural ■ MTA Architecture 310, 625 11 Avenue SW Calgary, Alberta T2R 0E1 ph. 403.264.8700 www.mtalink.com	Architectural ■ Alan Lowe Architect Inc. #118 - 21 Erie Street Victoria, British Columbia V8V 5A8 ph. 250.360.2888	Landscape ■ Phillips Farevaag Smallen Berg 1777 W 3rd Avenue Vancouver, British Columbia V6J 1K7 ph. 604.736.5168
---	--	--	---

architectural

A0.01	General Notes and Assemblies
A0.02	Perspectives
A0.03	Sun & Shadow Studies
A0.04	Average Grade Key Plan
A1.01	Survey Plan
A1.02	Overall Context Plan
A1.03	Site Context Plan & Data Sheet
A1.04	Detailed Site Plan
A1.05	Site Photos
A2.01A	Parkade Level P1 Plan
A2.01B	Parkade Level P2 Plan
A2.02	Main Floor Plan
A2.03	Second Floor Plan
A2.04	Third Floor Plan
A2.05	Fourth Floor Plan
A2.06	Fifth Floor Plan
A2.07	Sixth Floor Plan
A2.08	Seventh Floor Plan
A2.09	Eighth Floor Plan
A2.10	Mech. Penthouse Plan
A2.11	Roof Plan
A4.01	Exterior Elevations
A4.02	Exterior Elevations
A4.03	Exterior Elevations
A4.04	Exterior Elevations
A4.05	Streetscape Elevations
A5.01	Building Sections
A5.02	Building Sections

landscape

L0.1	Tree Management Plan
L1.1	Landscape Plan - Ground Floor
L1.2	Landscape Plan - Roof Levels
L2.1	Planting Plan - Ground Floor
L2.2	Planting Plan - Roof Levels
L3.1	Planting Details
L3.2	Landscape Sections and Details
L3.3	Landscape Sections and Details

CITY OF VICTORIA

Revisions

Bubbled areas indicate revisions compared to the previously submitted plans

Received Date:
June 8, 2022

MUNICIPAL ADDRESS
257 BELLEVILLE STREET, VICTORIA, BC
LEGAL ADDRESS
LOT A, VICTORIA CITY, PLAN 21081

LAND USE DESCRIPTION
EXISTING: R-6S PROPOSED: R-6S

PROJECT STATISTICS			
	Existing Zoning Standard	Existing Building	Proposal
Zoning	R-6S		R-6S
Site Area (m²)	2000	2053.88	2053.88
Site Coverage (%)	45%	30%	53% 1092.56 870.14
Building Area Main Floor (m²)		619.15	
Gross Floor Area (above Grade excl. Balconies, incl mech.)			6153.22
Floor Space Ratio	3.00:1	0.90	2.995
Building Height (m)	30	15	32 (incl. mechanical penthouse)
Number of Floors	N/A	3	9
Setbacks (m) 1. "North Elevation" GL 1-mid 6/7-8 GL 8-10 GL 10-13 2. "South Elevation" 3. "West Elevation" GL D-G GL A-D 4. "East Elevation" GL D-G	0.0 2.5 4.5 0.4	 21.86 3.64 2.30 3.51 2.23 4.8 1.34 n/a	 5.94 3.00 0.19 3.585 2.50 4.575 0.40 1.26
Note: Existing Setbacks to relative proposed Gridlines			
Open Space (%)	40%	31.7%	28.5%
Parking Stalls	40	25	78
Bicycle Parking	1.25/unit		6 @ Entry & 71 @ Main & Parkade Level

Net to Gross Ratio	1.28
Parkade Level P1 Area	1846 m²
Parkade Level P2 Area	1846 m²
Number of Floors above Grade	9 incl. Roof Top Mechanical (Laurel Point - 11)
Total Height @ Top of Parapet (excl. Mechanical Room)	30000mm (Laurel Point - 32000mm)
Floor to Floor Height (Typ.)	3350mm
Podium Floor to Floor	4500mm
Typ. Slab thickness	225mm
Zero Elevation	8.80m (center of Cross Street near Lobby)
Number of Units	32-57 (Max. 57 units)
Parking stall count	Min 40 required 78 stalls provided / including 6 Handicap and 6 Visitor U/G

GENERAL NOTES REGARDING UNITS:
Building makes use of an open plan concept. Unit sizes and types will vary depending on end-user's unit configuration. Number and type of unit will vary. Below is a sample configuration of the building.

Typical Unit Configuration	Avg. No.	Avg. Area/unit (m²)
1 BEDROOM	5	110
1 Bedroom & Den	15	125
2 BEDROOM	9	195
Ground Oriented Access	3	115

BUILDING AREA CALCULATION
BUILDING GROSS AREAS MEASURED TO THE INSIDE FACE OF THE EXTERIOR WALLS
OPEN SITE SPACE CALCULATION
CALCULATION BASED ON CITY OF VICTORIA "SCHEDULE A" DEFINITION OF OPEN SITE SPACE.
OPEN SITE SPACE MEANS THAT PORTION OF THE LOT: A) WHICH FROM THE SURFACE OF THE LOT IN A VERTICAL COLUMN UPWARD IS NOT OCCUPIED OR OBSTRUCTED BY THE BUILDING OR ITS PARTS EXCEPT 1) ACCESSORY GARDEN STRUCTURE 2) BALCONY OR ROOF PROJECTION B) WHICH IS GRADED AND LANDSCAPED

BUILDING CODE ANALYSIS	
BUILDING AREA	6054.44 M²
NUMBER OF STORIES	9
NO. OF STREETS	2
APPLICABLE CODE	BCBC 2018
MAJOR OCCUPANCY	C
Building is Classified under Section 3.2.2.47 Group C, Any Height, Any Area, Sprinklered	
SPRINKLERED	Yes
FIRE ALARMS REQUIRED	Yes
STANDPIPE & HOSE REQUIRED	Yes
CONSTRUCTION COMBUSTIBLE	No

FIRE RESISTANCE RATINGS	
ROOF	2 Hours
MEZZANINE	n/a
FLOORS	2 Hours
LOAD BEARING	2 Hours
FIREWALL REQUIREMENTS	TBC

SPATIAL SEPARATION & UNPROTECTED OPENINGS				
TABLE 3.2.3.1C UNPROTECTED OPENING LIMITS FOR A BUILDING THAT IS SPRINKLERED THROUGHOUT - FOR GROUPS A, B, C, D AND F, DIVISION 3 OCCUPANCIES				
"NORTH ELEVATION"				
FLOOR	GRIDLINE	LIMITING DISTANCE	AREA	SHOWN
Main	5-7	PL - 12.18m	23.6m²	100%
Room: Mail Room R112				
Note: Allowable openings as per Code 100%				
Main	Mid 6/7-8	PL - 3.00m	41.2m²	39%
Room: Corridor R111				
Note: Allowable openings as per Code 40%				
Main - 5th	8-10	PL - 0.00m	32.3m²	0%
Room: Stair #03 & #04.				
Note: Allowable openings as per Code 0%.				
Main	10-13	PL - 3.62m	48.4m²	34%
Room: Unit #03 R120				
Note: Allowable openings as per Code 40%.				
2nd - 5th	Mid 6/7-8	PL - 3.00m	19.4m²	73%
Room: Units R212, R312, R412 & R512				
Note: Allowable openings as per Code 74%				
2nd & 3rd	10-12	PL - 3.62m	32.6m²	44%
Room: Units R214 & R314				
Note: Allowable openings as per Code 46%				
4th	10-11	PL - 3.62m	13.6m²	100 %
Room: Unit R413				
Note: Allowable openings as per Code 100%				
6th	Mid 6/7-9	PL - 3.00m	35.2m²	43%
Room: Unit R607				
Note: Allowable openings as per Code 46%				
7th	3-4	PL - 6.01m	15.8m²	100%
Room: Unit R706				
Note: Allowable openings as per Code 100%				
7th	4-5	PL - 7.80m	17.7m²	100%
Room: Unit R706				
Note: Allowable openings as per Code 100%				
7th	5-6	PL - 9.57m	14.9m²	100%
Room: Unit R706				
Note: Allowable openings as per Code 100%				
7th	Mid 6/7-8	PL - 3.00m	26.1m²	47%
Room: Unit R706				
Note: Allowable openings as per Code 52%				
All Eighth Floor 'North' Glazing @ 100% allowable Unprotected Openings				

"EAST ELEVATION"				
FLOOR	GRIDLINE	LIMITING DISTANCE	AREA	SHOWN
Main	C-Mid D/E	PL - 1.65m	28.3m²	17%
Room: Mail Room R112				
Note: Allowable openings as per Code 18%				
2nd - 7th	Mid C/D-D/E	PL - 1.65m	15.4m²	19%
Room: Unit R211, R311, R411, R511, R606 & R707				
Note: Allowable openings as per Code 20%				
2nd - 7th	Mid B/C-C/D	PL - 3.00m	15.3m²	72%
Room: Unit R211, R311, R411, R511, R606 & R706				
Note: Allowable openings as per Code 74%				
8th	Mid B/C-DE	PL - 3.00m	29.9m²	43%
Room: Unit R806				
Note: Allowable openings as per Code 46%				

COMPARTMENTALIZATION - SEPARATIONS
FIRE SEPARATIONS - GENERAL
3.1.8.1 General Requirements
3.3.4.2 Residential Occupancy, Fire Separations
ASSEMBLY OCCUPANCIES
3.3.2.2 In the case of gathering spaces at grade, or assembly functions
CORRIDOR SEPARATION
3.3.1.4 Public Corridor Separation
3.3.2.6 Corridors
EXIT ENCLOSURES
3.4.4 Fire Separation of Exits
FIRE STOPPING
3.1.9 Building Services in Fire Separations and Fire-Rated Assemblies
3.1.11 Fire Stops in Concealed Spaces
3.1.11.5 Fire Stopping of Horizontal Concealed Spaces
FLOOR ASSEMBLY RATINGS
3.2.2 Building Size and Construction Relative to Occupancy

INTERCONNECTED FLOOR SPACES
3.2.8 Mezzanines and openings through Floor Assemblies
3.2.8.2 (6) Interconnected Space conformity requirements
3.2.3.2 (3) Sprinklered Interconnected Spaces and exposed Building Face
3.2.2.2 Means of Egress from Mezzanines
JANITOR ROOMS
3.3.1.21 Janitor's Rooms
CONT'D

PENETRATION OF FIRE SEPARATIONS
3.1.9.4 Combustible Piping Penetrations
3.1.9.5 Openings Through a Membrane Ceiling
REPAIR GARAGES
3.3.5.5 N/A
ROOM WITH FUEL FIRE APPLIANCES
3.6.2.1 Fire Separations Around Service Rooms
3.6.2.2 Service Rooms Under Exits
3.6.2.3 Service Equipment
3.6.2.6 Door Swing for Service Rooms
SERVICE EQUIPMENT THROUGH FIRE SEPARATION
3.1.9.1 Fire Stopping of Service Penetrations
SERVICE ROOMS
3.6.2.1 Fire Separations Around Service Rooms
3.6.2.2 Service Rooms under Exits
SUITE TO SUITE SEPARATION
3.3.1.1 Separation of Suites
SEPARATION BETWEEN MAJOR OCCUPANCIES
3.1.3.1 Separation of Major Occupancies
STORAGE ROOMS
3.3.4.3 Storage Rooms
3.6.2.5 Combustible Refuse Storage
STORAGE GARAGES
3.3.5.6 Storage Garage Separation
VERTICAL SERVICE SPACES
3.3.5.6 Storage Garage Separation
VERTICAL SERVICE SPACES
3.1.8.3 Continuity of Fire Separations
3.1.9.1 Fire Stopping of Service Penetrations
3.5.3 Fire Separations
3.6.3.1 Fire Separations for Vertical Service Spaces
3.6.3.3 Linen and Refuse Chutes
CLOSURES IN FIRE SEPARATIONS 3.1.8
DAMPERS
3.1.8.7,8,9 Fire Dampers, Fire Dampers Waived, Installation of Fire Dampers

DOORS
3.1.8.4 Determination of Ratings
3.1.8.5 Installation of Closures
3.1.8.10 Twenty Minute Closures
3.1.8.11 Self-Closing Devices
DOOR LATCHES
3.1.8.13 Door Latches
HOLD OPEN DEVICES
3.1.8.12 Hold-Open Devices
MAXIMUM OPENINGS PERMITTED IN FIRE SEPARATIONS
3.1.8.6 Maximum Openings
SELF CLOSING DEVICES
3.1.8.11 Self Closing Devices
WIRED GLASS AND GLASS BLOCK
3.1.8.5 Installation of Closures
3.1.8.14 Wired Glass and Glass Block
MAXIMUM AREA OF GLASS IN EXITS AND FIREWALLS
3.1.8.15-16 Temperature Rise Limits, Area Limits for Wired Glass and Glass Block

SIZE AND OCCUPANCY REQUIREMENTS FOR FIRE SAFETY 3.2
BASEMENT FLOOR AND LOAD BEARING RATING
3.2.1.4 Floor Assembly Over Basement
BUILDING HEIGHT (NUMBER OF STOREYS) FIRST STOREY DEFINITION - MAX 2.0m ABOVE GROUND
3.2.1.1 8 Storeys
NUMBER OF STREETS BUILDING IS FACING WITHIN 15.0m (3.2.2.10)
3.2.2.10 Fire Lanes Requirements
BUILDING CLASSIFICATION (BUILDING SIZE AND CONSTRUCTION RELATIVE TO OCCUPANCY 3.2.2.20-83)
Classification Article - C Residential Construction Type - Non-Combustible Sprinklered - Yes
RATINGS
Floors
Roofs
Load Bearing
SPRINKLER REQUIREMENTS
3.2.5.13 Automatic Sprinkler Systems
FIRE ALARM REQUIREMENTS
3.2.4.1 Determination of Requirement for a Fire Alarm System

SAFETY REQUIREMENTS WITHIN FLOOR AREAS 3.3
SEPARATION OF SUITES
3.3.1.1 Separation of Suites
3.3.2 Assembly Occupancy
3.3.3 Care or Detention Occupancy
3.3.4 Residential Occupancy
3.3.5 Industrial Occupancy

CORRIDOR SEPARATION - PUBLIC
3.3.1.4 Public Corridor Separations
CORRIDOR SEPARATION - ASSEMBLY OCCUPANCY
3.3.2.6 Corridors
SUITE EGRESS
3.3.1.5 Egress Doorways
JANITORS ROOM RATING
3.3.1.21 Fire Rating of 1 Hour
STORAGE ROOM RATING
3.3.4.3 Fire Rating of 1 Hour
REPAIR GARAGE SEPARATION
3.3.5.5 Fire Rating of 2 Hours
STORAGE GARAGE SEPARATION
3.3.5.6 Fire Rating of 1.5 Hours

EGRESS AND EXIT REQUIREMENTS 3.3.3.4
ACCESS TO EXIT DIMENSIONS (WIDTH)
3.3.1.9 1100mm Minimum Width
ACCESS TO EXIT DIMENSIONS (CLEARANCE)
3.3.1.8 (see 3.4.3.4) 2100mm Minimum Clearance
CORRIDORS
Corridor and Aisle Widths
3.3.1.9 1100mm minimum width
3.3.2.5 Aisle Seating (N/A)
3.3.3.3 Minimum of 1100mm wide
CORRIDOR OBSTRUCTIONS IN ACCESS TO EXITS
3.3.1.9 (3) to 3.3.1.9 (6) Projections limited to 100mm into corridor
3.3.1.23 Obstructions
CORRIDOR OBSTRUCTIONS IN EXITS
3.4.3.3 Exit Width Reduction

CROSS-OVER FLOORS
3.4.6.17 Emergency Access to Floor Areas
DOORS
DOOR RELEASE HARDWARE
3.3.1.13 Doors and Door Hardware
3.3.2.7 Doors
3.4.6.15 Door Release Hardware
DOOR - SLIDING
3.3.1.12 Sliding Doors
3.4.6.13 Sliding Doors
INTERCONNECTED FLOOR SPACE (3.2.8) EXCEPTIONS TO SPECIAL PROTECTION
3.2.8.2 Exceptions to special protection
CONSTRUCTION REQUIREMENTS
2.2.8.3 Construction Requirements

SPRINKLERS
2.2.8.4 Building containing interconnected floor space shall be sprinklered throughout
VESTIBULES
3.2.8.5 Vestibules
DRAFT STOPS
3.2.8.7 Draft Stops

DOOR SWING
3.3.1.11 Door Swing
3.4.5.11 Direction of Door Swing
DOOR WIDTH
3.3.3.4 Doorway Width
3.4.3 Width and Length of Exits
3.4.6.10 Doors
ELECTROMAGNETIC LOCKS
3.4.6.15 (4) Door Release Hardware - Electromagnetic Locks
TRANSPARENT DOORS AND PANELS
3.3.1.19 Transparent Doors and Panels
3.4.1.8 Transparent Doors and Panels
WIRED GLASS IN DOORS
3.1.8.15 / 16 Temperature Rise Limit for Door / Area Limits for Wired Glass & Blocks
3.1.8.17 Temperature Rise and Area Limits Waived
EMERGENCY LIGHTING AND POWER
3.2.7.3 Emergency Lighting
3.2.7.4 Emergency Power for Lighting
EXIT DIMENSIONS (WIDTH)
3.4.3.2 Exit Width
EXIT DIMENSIONS (HEADROOM CLEARANCE)
3.4.3.4 Headroom Clearance
LOCATION OF EXITS FROM FLOOR AREAS
3.4.2.3 Distance between Exits
3.4.2.5 Location of Exits

EXIT CAPACITY
3.4.3.2 Exit Width
EXIT THROUGH LOBBY
3.4.4.2 Exits Through Lobbies
EXIT SIGNAGE
3.4.5 Exit Signs
GUARDS
3.3.2.9 Guards
3.3.1.1.8 Guards
3.4.6.5 Guards
HANDRAILS
3.4.6.4 Handrails
LIGHTING
3.2.7.1 Minimum Lighting Requirements
OBSTRUCTIONS TO EGRESS
3.3.1.23 Obstructions
3.4.3.3 Exit Width Reduction
OCCUPANT LOAD
3.1.17 Occupant Load (3.1.17.1) 2 persons per sleeping room in a dwelling unit
RAMPS
3.3.1.14 Ramps and Stairways
3.4.1.4 Public Corridor Separations
3.4.6.7 Treads, Risers and Tactile Warning
FIXED SEATS, ASSEMBLY OCCUPANCY
3.3.2.4 Fixed Seats
3.3.2.8 Fixed Bench Type Seats Without Arms

STAIR LANDINGS AND STAIR FLIGHTS
3.4.6.3 Landings and Maximum Vertical Rise of Stair Flights
STAIR TREADS AND RISERS
3.3.1.14 Ramps and Stairways
3.3.1.16 Curved or Spiral Stairs
3.3.2.14 Risers for Stairs
3.4.6.7 Treads, Risers and Tactile Warning

STAIR WIDTH
3.4.3.1 Exit Width Based on Occupant Load
TRAVEL DISTANCE TO:
3.3.1.5 Egress Doorways (Table 3.3.1.5.B)
3.3.1.6 Egress Travel Distance (refer to 3.4.2.5 for distances)
3.4.2.3 Distance between Exits
3.4.2.5 Location of Exits

INTERIOR FINISH
ATTACHMENT TO WALLS AND PARTITIONS
3.1.5.6 Nailing Elements
ELECTRICAL AND COMMUNICATIONS CABLE RATINGS
3.6.1.1 Scope
LIMITS IN LOBBIES USED AS EXITS
3.4.4.2 Exits Through Lobbies

LIMITS IN LOBBIES USED AS EXITS
3.4.4.2 Exits Through Lobbies
INTERIOR FINISH, FLAME SPREAD
3.1.5.10 Combustible Interior Finishes
3.1.12 Flame Spread Rating and Smoke Developed Classification
3.1.13 Interior Finish
PLASTIC PIPE AND DUCTS
3.1.9.4 Combustible Piping Penetrations

BARRIER FREE DESIGN FOR PERSONS WITH DISABILITIES
ACCESS ROUTES WITHIN BUILDING
3.8.1.3 Access Routes
PARKING AREAS
3.8.3.4 Parking Stalls for Persons with Disabilities
AREAS REQUIRING BARRIER FREE PATH OF TRAVEL
3.8.2.1 Application and Exemptions
3.8.2.3 Specific Requirements
3.8.2.27 Apartment Buildings and Condominiums
ASSISTIVE LIVING DEVICES
3.8.3.7 Assistive Living Devices
BUILDING ENTRANCES
3.8.3.5 Main Entrances
CONTROLS
3.8.3.21 Controls
DOORS AND DOORWAYS
3.8.3.5 Main Entrances
3.8.3.13 Door Numbers
DRINKING FOUNTAINS
3.8.3.17 Drinking Fountains
EXTERIOR WALKS, PARKING AND DRIVEWAYS
3.8.3.2 Parking and Driveways

PUBLIC COUNTERS
3.8.3.14 Public Counters
RAMPS
3.8.3.3 Ramps
SIGNS
3.8.3.12 Directional Signs
SPACES IN SEATING AREAS
3.8.3.6 Seating Areas
TELEPHONE SHELVES AND COUNTERS
3.8.3.18 Counters
3.8.3.16 Public Telephones
WASHROOMS
3.8.2.3 Location and Washrooms
STALLS AND WATER CLOSETS
3.8.3.8
3.8.3.9
URINALS
3.8.3.10
LAVATORIES
3.8.3.11
UNIVERSAL TOILET ROOMS
3.8.3.12

FIRE ALARM SYSTEMS
DETERMINE THE NEED
3.2.4.1 Determination of Requirement for a Fire Alarm System
Full Fire Alarm System Required & Supplied

REQUIREMENT FOR DEVICES
3.2.4.10-12 Fire Detectors, Smoke Detectors, Prevention of Smoke Circulation
/ 15-17 System Monitoring, Manual Stations, Alert and Alarm Signals
/ 19-21 Visual Signals, Smoke Alarms, Voice Communications Systems
HOSE CABINET DESIGN
3.2.5.10/ .11 Hose Connections, Hose Stations
HOSE CABINET LOCATION
3.2.5.11 Hose Stations
STANDPIPE SYSTEM DESIGN
3.2.5.8 Standpipe System Design
PORTABLE FIRE EXTINGUISHERS
3.2.5.17 Portable Fire Extinguishers. For Types Required and Locations see BC Fire Code
HEALTH REQUIREMENTS
3.7.2.2 Water Closets
3.7.2.3 Lavatories

EXTERIOR WALL ASSEMBLY SCHEDULE
EXTERIOR WALL ABOVE GRADE:
• EXTERIOR FINISH - CLADDING TBD
• 50MM (R10) RIGID INSULATION ON
• 100 MM Z-GIRTS
• AIR BARRIER MEMBRANE
• 15.9 MM EXTERIOR SHEATHING
• 152MM STEEL STUDS CW
• RSI 3.5 (R20) BATT INSULATION
• VAPOUR BARRIER
• GYPSUM WALL BOARD
• PAINT FINISH

FOUNDATION WALL BELOW GRADE:
• GRAVEL
• DRAINAGE LAYER
• BENTONITE LAYER (IF REQUIRED)
• FOUNDATION WATERPROOFING
• CONCRETE FOUNDATION WALL

WINDOWS
FRAME
CLEAR ANODIZED ALUMINUM WINDOW-WALL SYSTEM. THE INTERIOR FRAMES MAY BE WOOD CLAD WITH MILLED WOOD BULLS. THE FRAME SIDE OF EACH WINDOW IS TO CONFORM TO A PRECISE SEQUENCE OF MEMBRANE INSTALLATION. THE VAPOUR BARRIERS, AND AIR BARRIERS MUST TIE INTO THE ROUGH OPENING OF ALL WINDOW SYSTEMS AT THE WINDOW PLANE.

GLAZING
THE GLAZING DOUBLE GLAZED WITH A LOW-E COATING ON SURFACE 3 FOR THE SEALED UNIT. CONSIDER GLAZING AND FRAMES OF THE HIGHEST AFFORDABLE INSULATING VALUE AND THERMAL PERFORMANCE. AN ADDITIONAL TINT IS RECOMMENDED ON THE GLASS TO REDUCE SOLAR HEAT GAIN.

SOLAR SHADING
HORIZONTAL SOLAR SHADING DEVICES AND OVERHANGS MAY BE USED TO REDUCE SOLAR GAIN EXPOSURE ON THE SOUTH FACADE. ADDITIONAL VERTICAL SHADING DEVICES MAY BE USED ON THE EAST AND WEST FACADES IF REQUIRED AS WELL. FINALLY, THE SLENDER MASSING AND STEPPING ALLOWS FOR INCREASED DAYLIGHT ACCESS.

DRAWING REFERENCE SYMBOLS:
DETAIL NUMBER SHEET NUMBER WHERE LOCATED
ELEVATION NUMBER SHEET NUMBER WHERE LOCATED
SECTION NUMBER SHEET NUMBER WHERE LOCATED
ELEVATION NUMBER
INTERIOR ELEVATION NUMBER SHEET NUMBER WHERE LOCATED
INTERIOR ELEVATION NUMBER ELEVATION NUMBER SHEET NUMBER WHERE LOCATED
DRAWING NUMBER DRAWING TITLE
DRAWING SCALE SHEET NUMBER WHERE LOCATED
DRAWING NUMBER DRAWING TITLE
DRAWING SCALE SHEET NUMBER WHERE LOCATED SHEET NUMBER REFERENCED FROM
OBJECT NAME OBJECT HEIGHT FROM A GIVEN ELEVATION
SLOPE DIRECTION SLOPE INCREMENT
CEILING TYPE HEIGHT ABOVE FINISHED FLOOR
SUB KEYNOTE REFERENCE KEYNOTE REFERENCE NUMBER

SYMBOL LEGEND
<



VIEW FROM BELLEVILLE STREET



VIEW FROM INNER HARBOR



VIEW FROM QUEBEC STREET



VIEW FROM PENDRAY & QUEBEC STREET

257 BELLEVILLE STREET

VICTORIA, BRITISH COLUMBIA

no.	issued for	date
1	DEVELOPMENT PERMIT	OCT 23/2012
2	DEVELOPMENT PERMIT	MAR 16/2020
3	REISSUED DEVELOPMENT PERMIT	DEC 03/2020



alan lowe architect inc.



mtaink.com Urban Design Architecture Interior Design

PERSPECTIVES

A0.02

drawn	DL	scale	AS SHOWN
checked	DL	project no.	20.118

MARCH SHADOW STUDIES



MARCH 21ST 2011 - 10.00am




MARCH 21ST 2011 - 12.00pm




MARCH 21ST 2011 - 2.00pm


JUNE SHADOW STUDIES

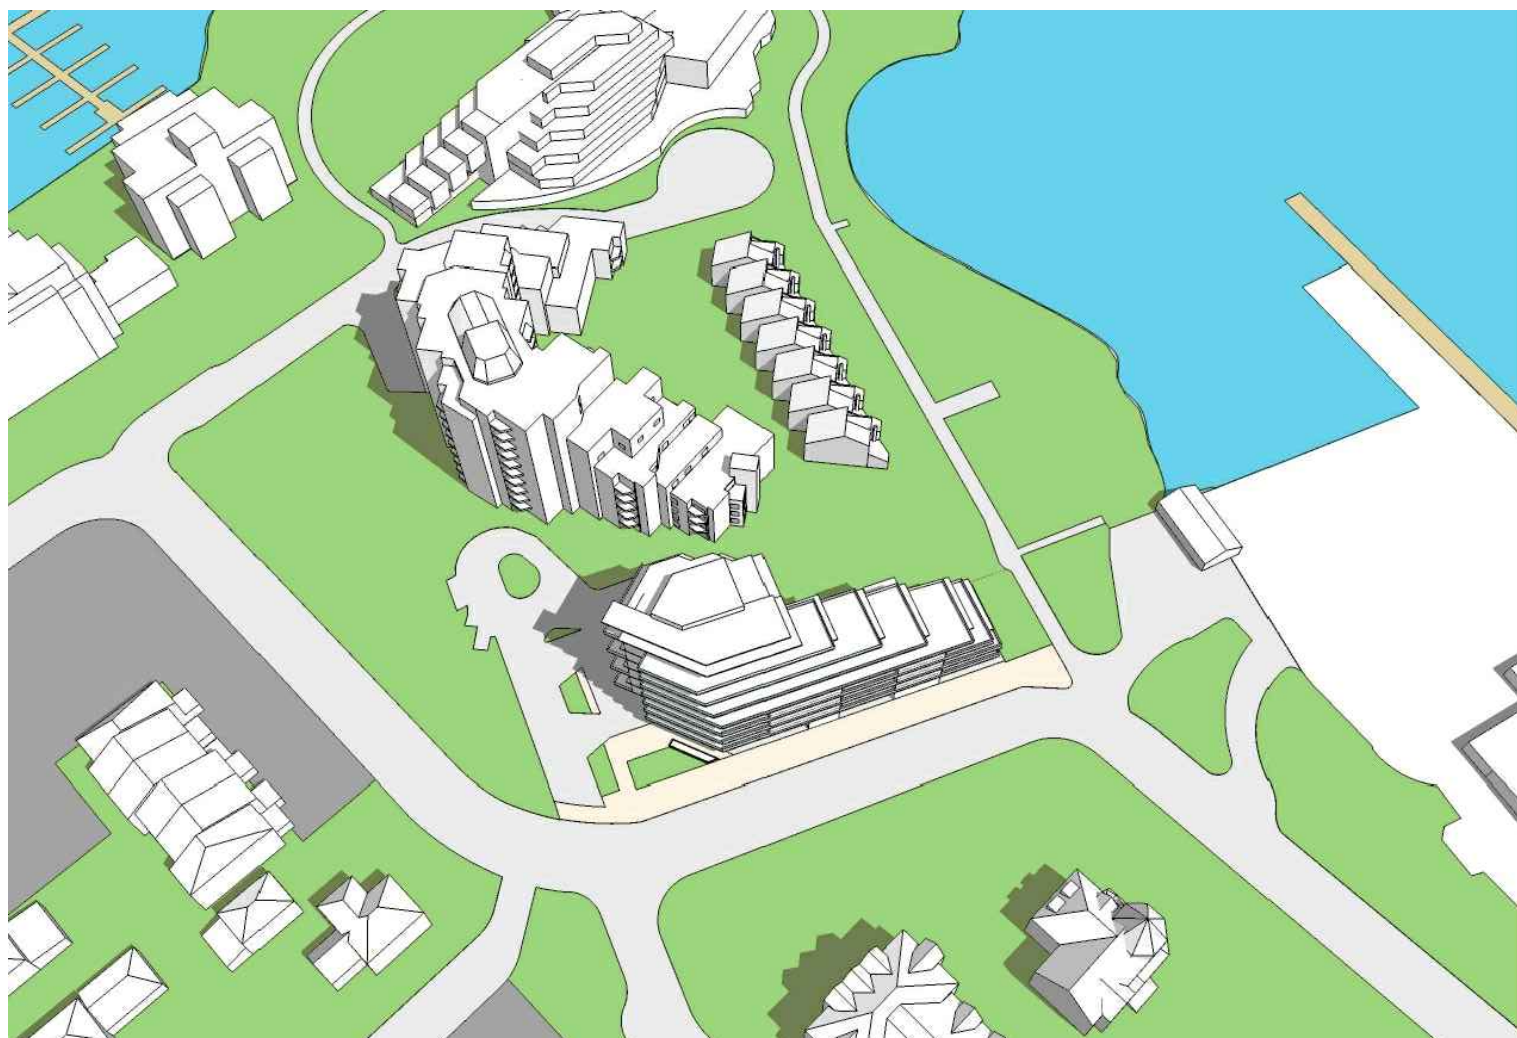

JUNE 21ST 2011 - 10.00am

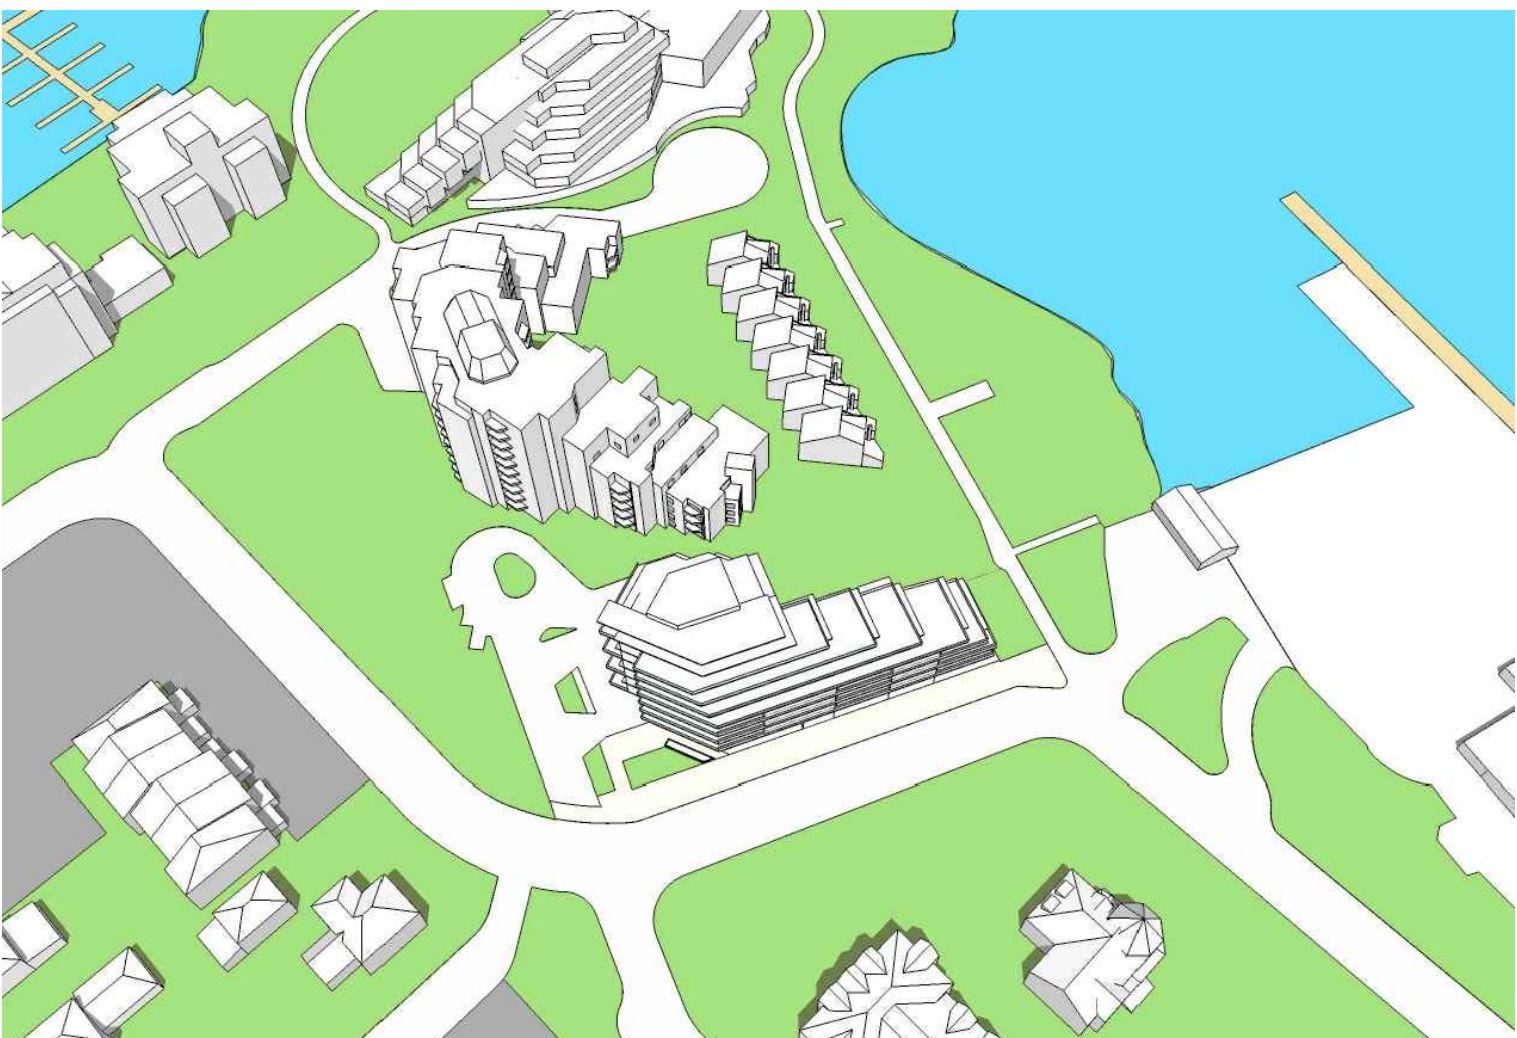

JUNE 21ST 2011 - 12.00pm

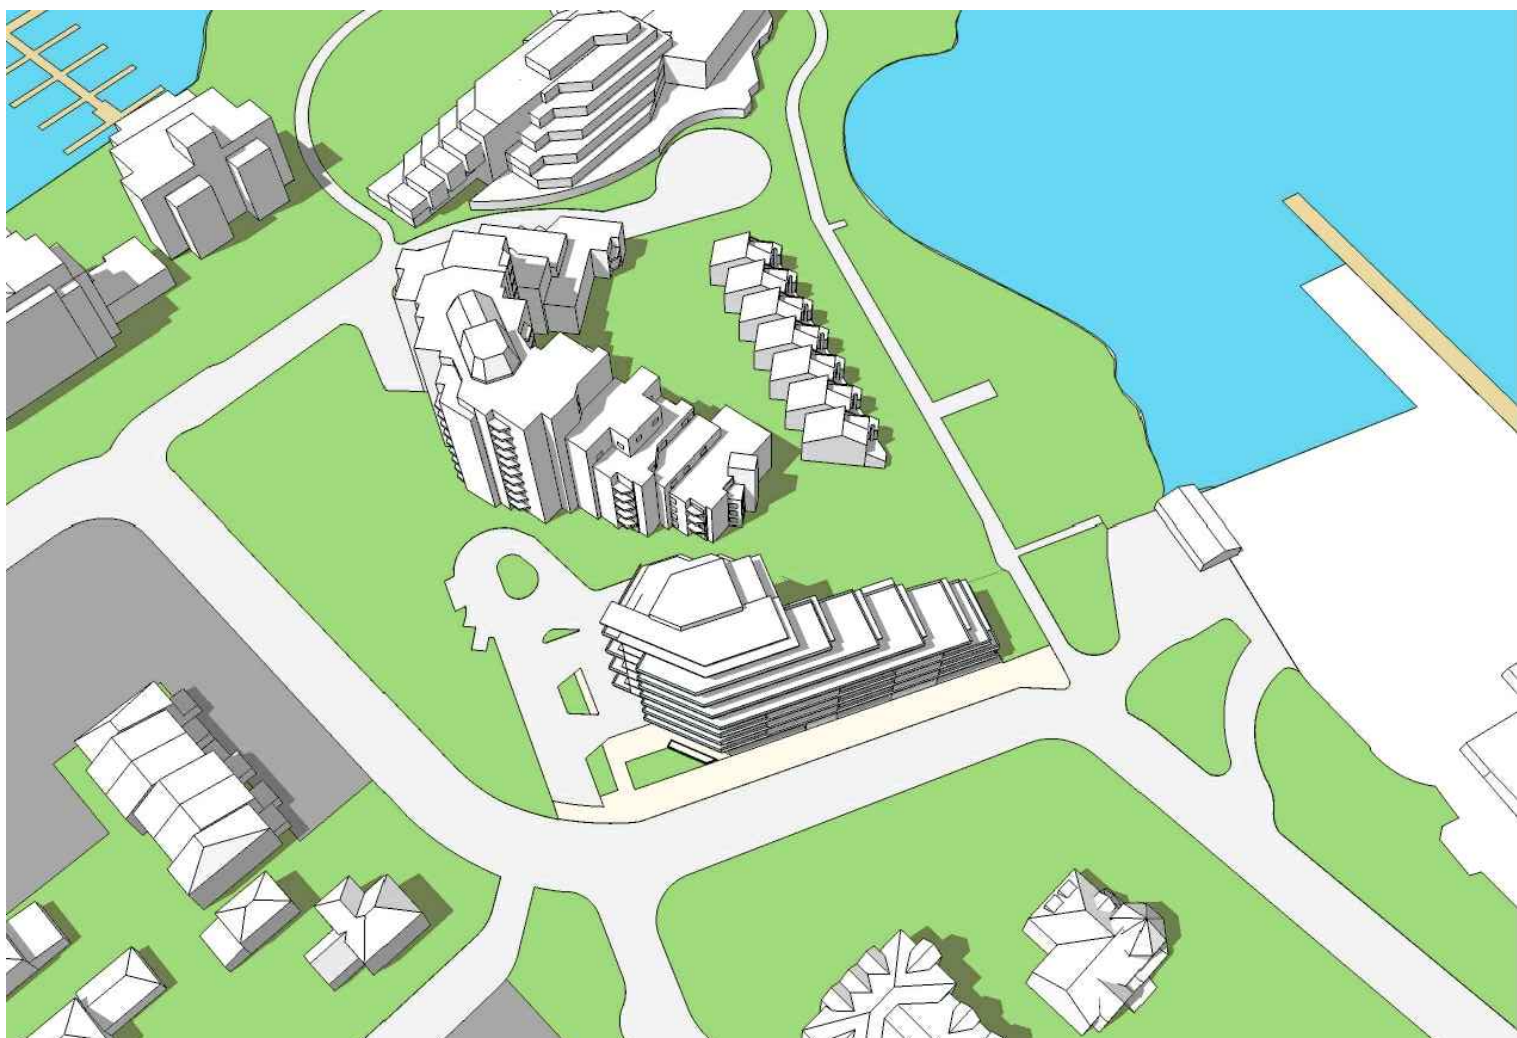

JUNE 21ST 2011 - 2.00pm

SEPTEMBER SHADOW STUDIES



SEPTEMBER 21ST 2011 - 10.00am



SEPTEMBER 21ST 2011 - 12.00pm



SEPTEMBER 21ST 2011 - 2.00pm


DECEMBER SHADOW STUDIES



DECEMBER 21ST 2011 - 10.00am



DECEMBER 21ST 2011 - 12.00pm

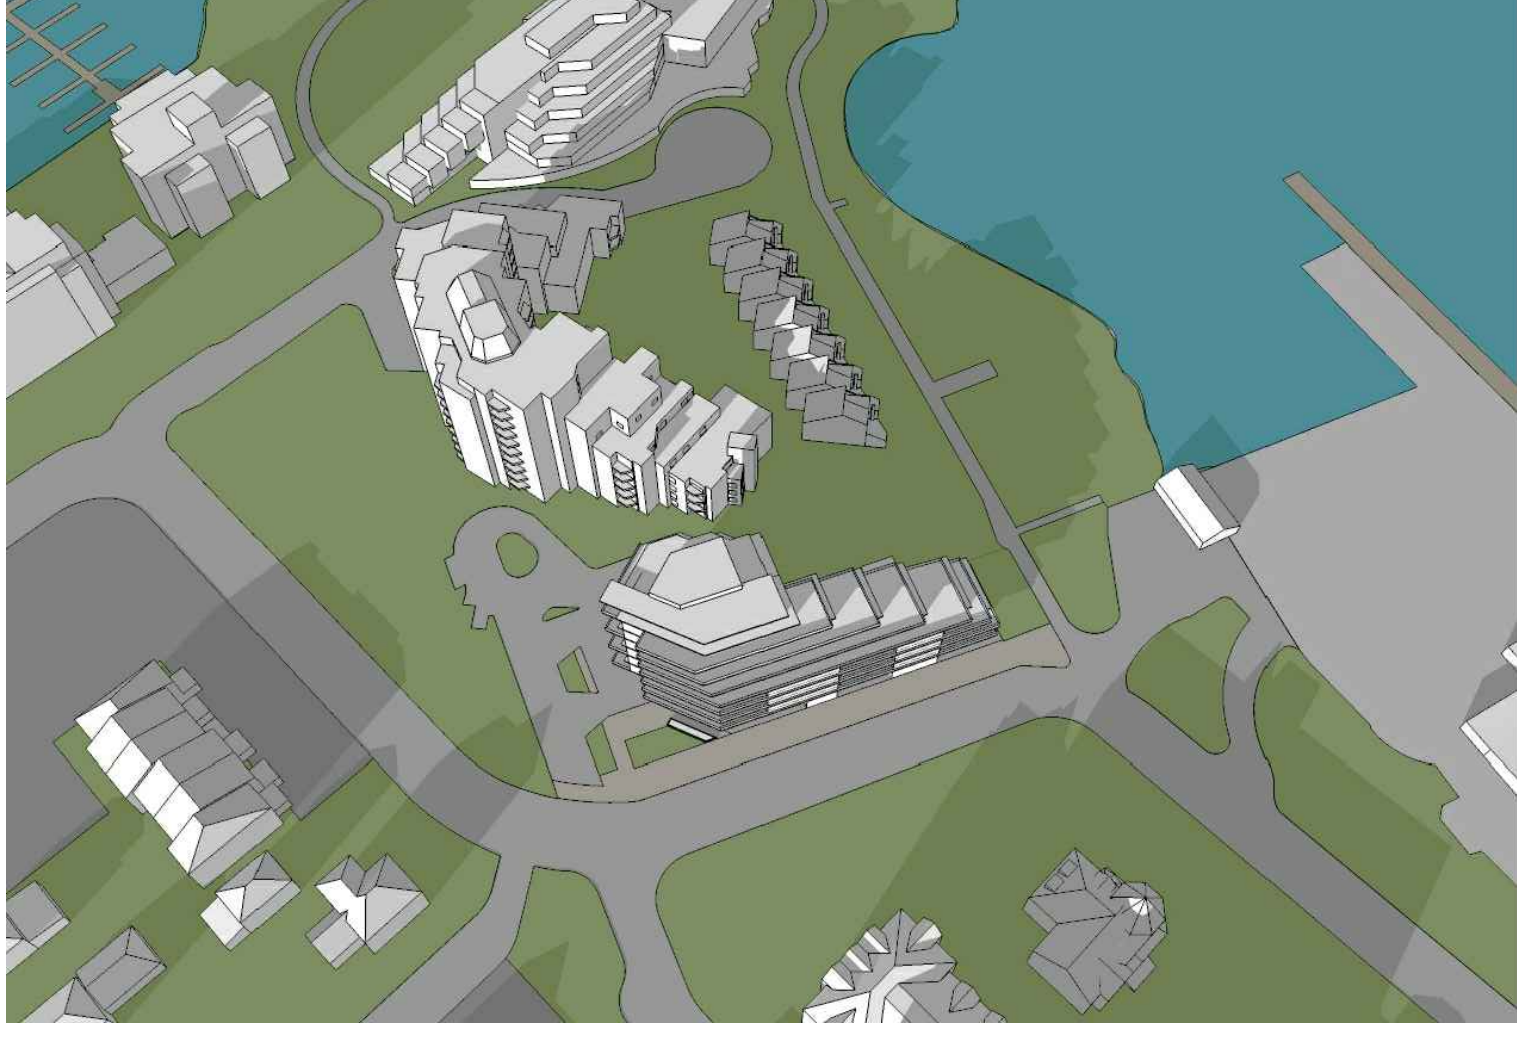

DECEMBER 21ST 2011 - 2.00pm

257 BELLEVILLE STREET

VICTORIA, BRITISH COLUMBIA

no.	issued for	date
1	DEVELOPMENT PERMIT	OCT 23/2012
2	DEVELOPMENT PERMIT	MAR 16/2020
3	REISSUED DEVELOPMENT PERMIT	DEC 03/2020



alan lowe architect inc.



drawing title	
SUN & SHADOW STUDIES	
sheet	
A0.03	
drawn	scale
DS	AS SHOWN
checked	project no.
DL	20.118

[illegible]

mit

Consultant

alan **lowe** architect inc.



310, 625-11 Ave SW Calgary AB T2R 0E1
t. 403.264.8700
f. 403.264.8029

mtalink.com Urban Design Architecture Interior Design

Drawing title

AVERAGE GRADE KEY PLAN

A0.04

meet

scale


DS

AS SHOWN

check



project no.
20-112

P:\2020\20.118.257 Belleville DP Renewal\D Integrated Design\D20 AutoCAD\022 Current\Sheets\WD 30x42 Sheets\A0.00\20.118-09-151-A0.04 AVERAGE GRADE KEY PLAN.dwg 2020/12/02 5:30 PM Ilona Ciunkiewicz

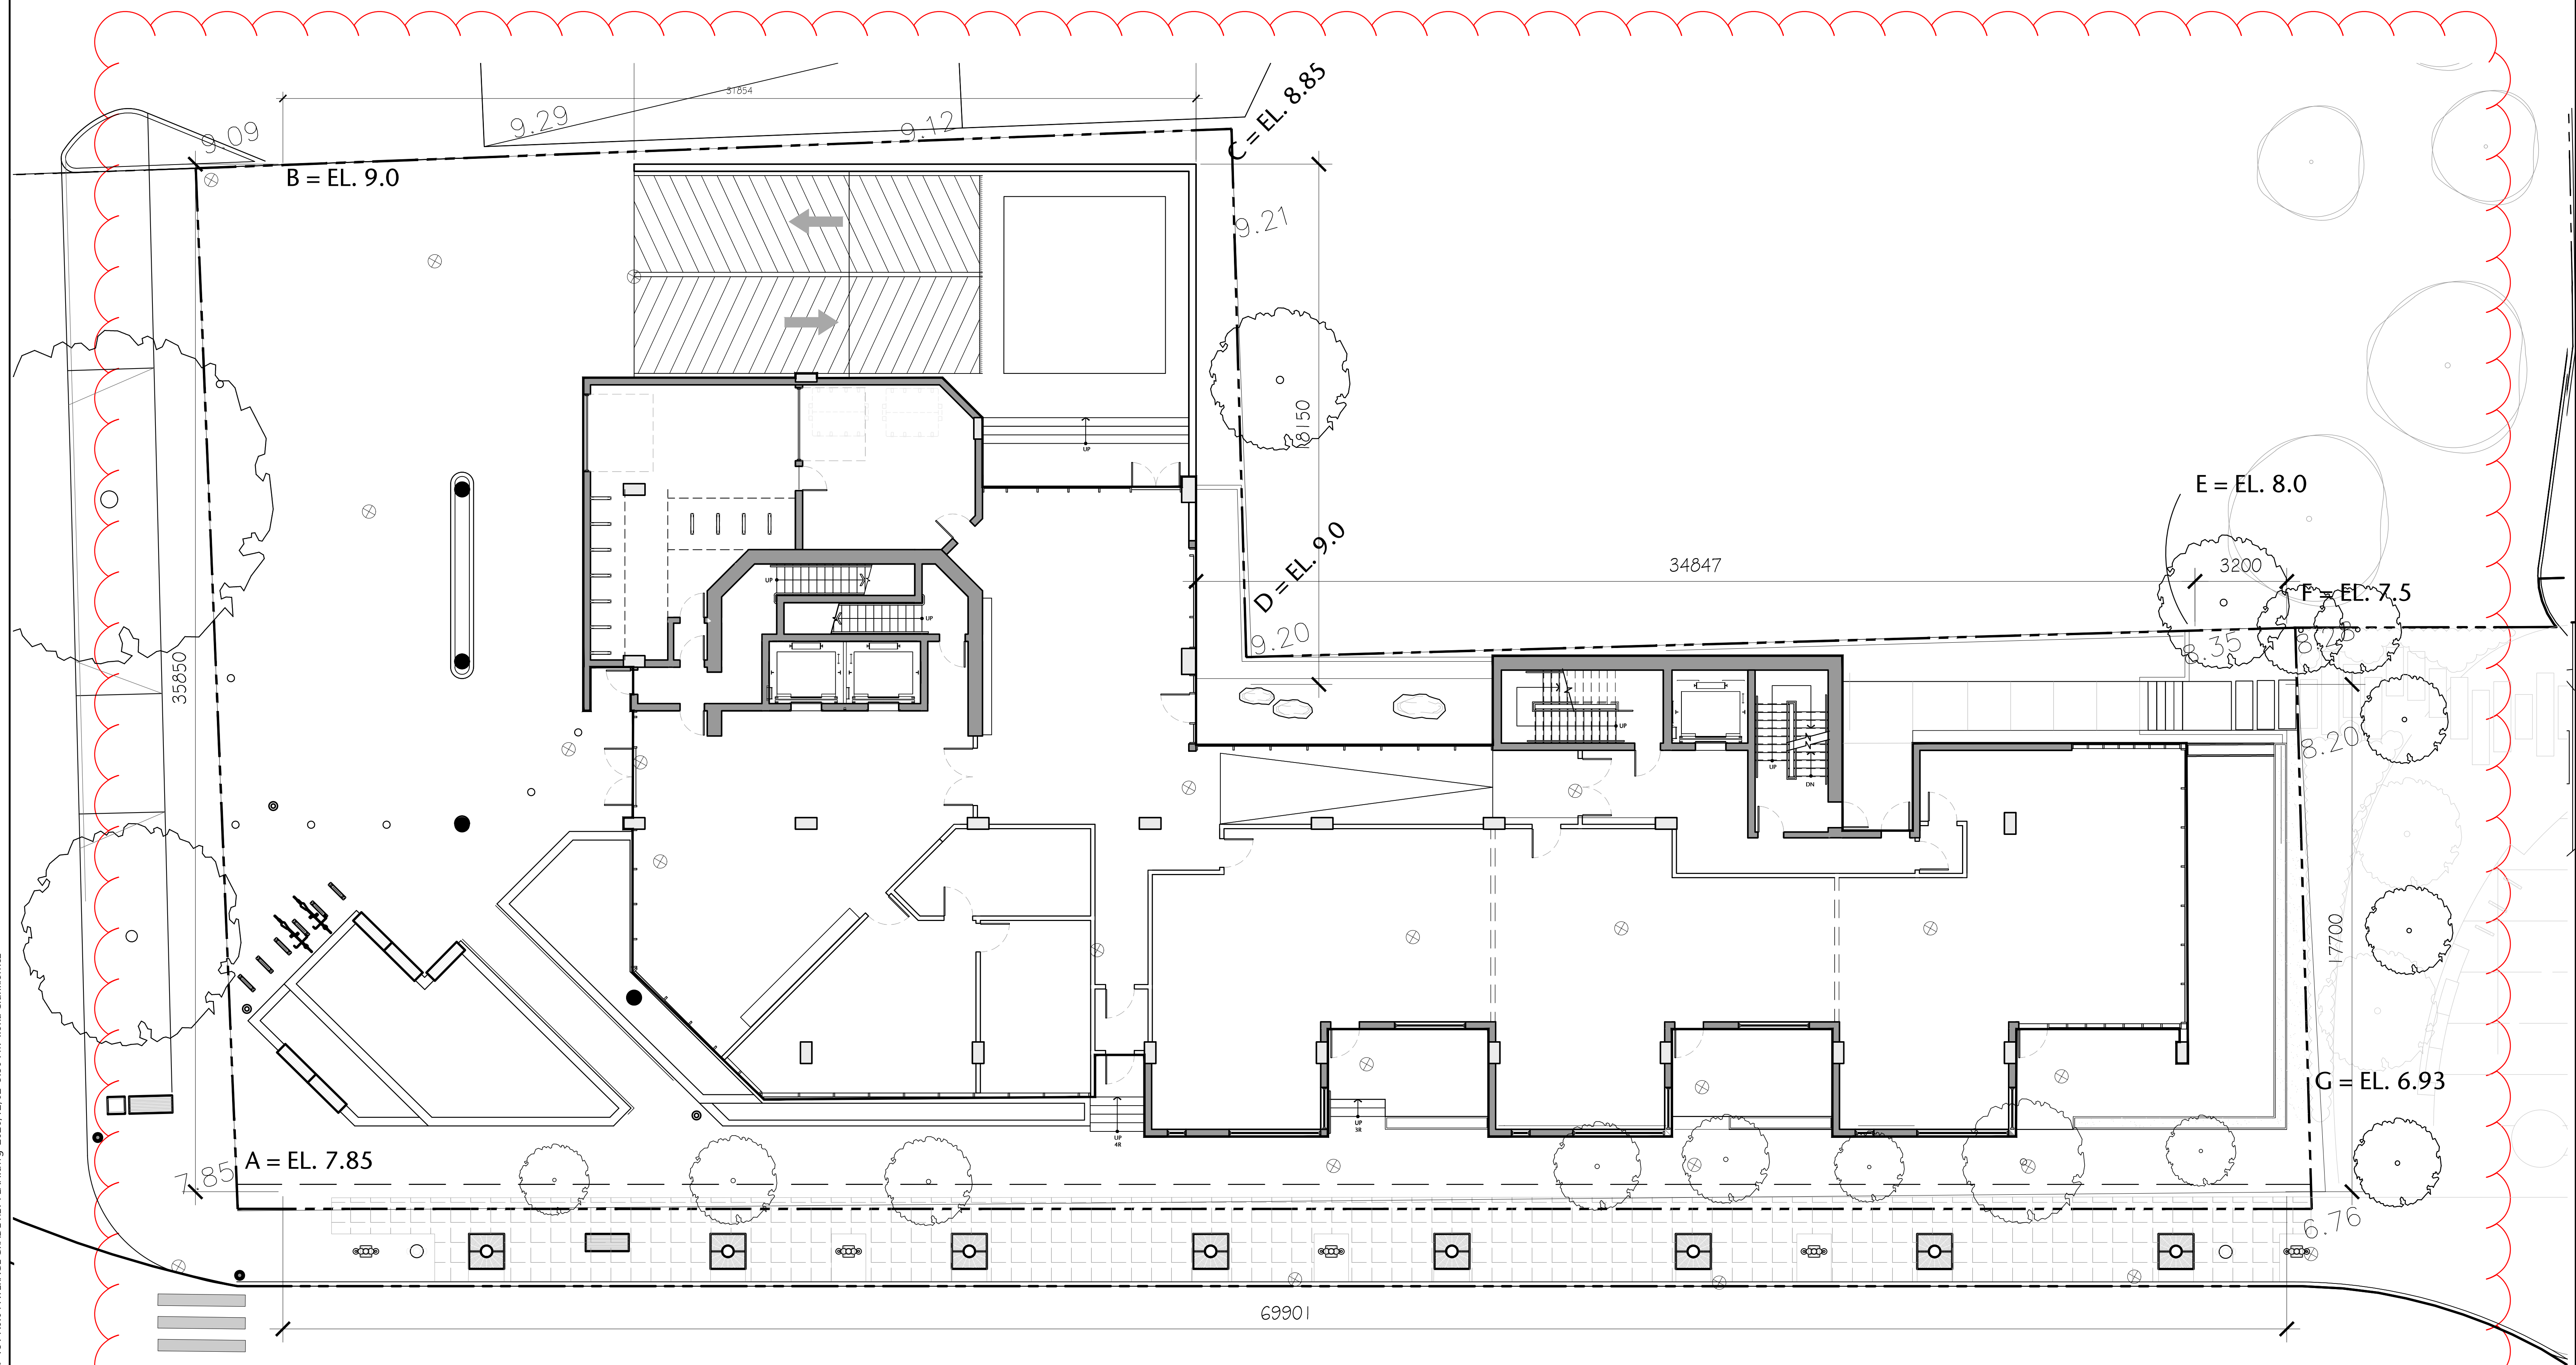

1 AVERAGE GRADE KEY PLAN
A0.04 1:100

Average Grade Calculation:			
Grade Points	Average of Points	Distance between Points	Totals
A&B	$7.85+9/2 = 8.425$	35.850m	302.036
B&C	$9+8.85/2 = 8.925$	31.854m	284.297
C&D	$8.85+9/2 = 8.925$	18.150m	161.989
D&E	$9+8/2 = 8.5$	34.847m	296.199
E&F	$8+7.5/2 = 7.75$	3.2m	24.8
F&G	$7.5+6.93/2 = 7.215$	17.7m	127.705
G&A	$6.93+7.85/2 = 7.39$	69.901m	516.568
<u>Totals:</u>		<u>211.502m</u>	<u>1,713.594</u>
Grade Calculation: $1,713.594/211.502 = 8.102m$			

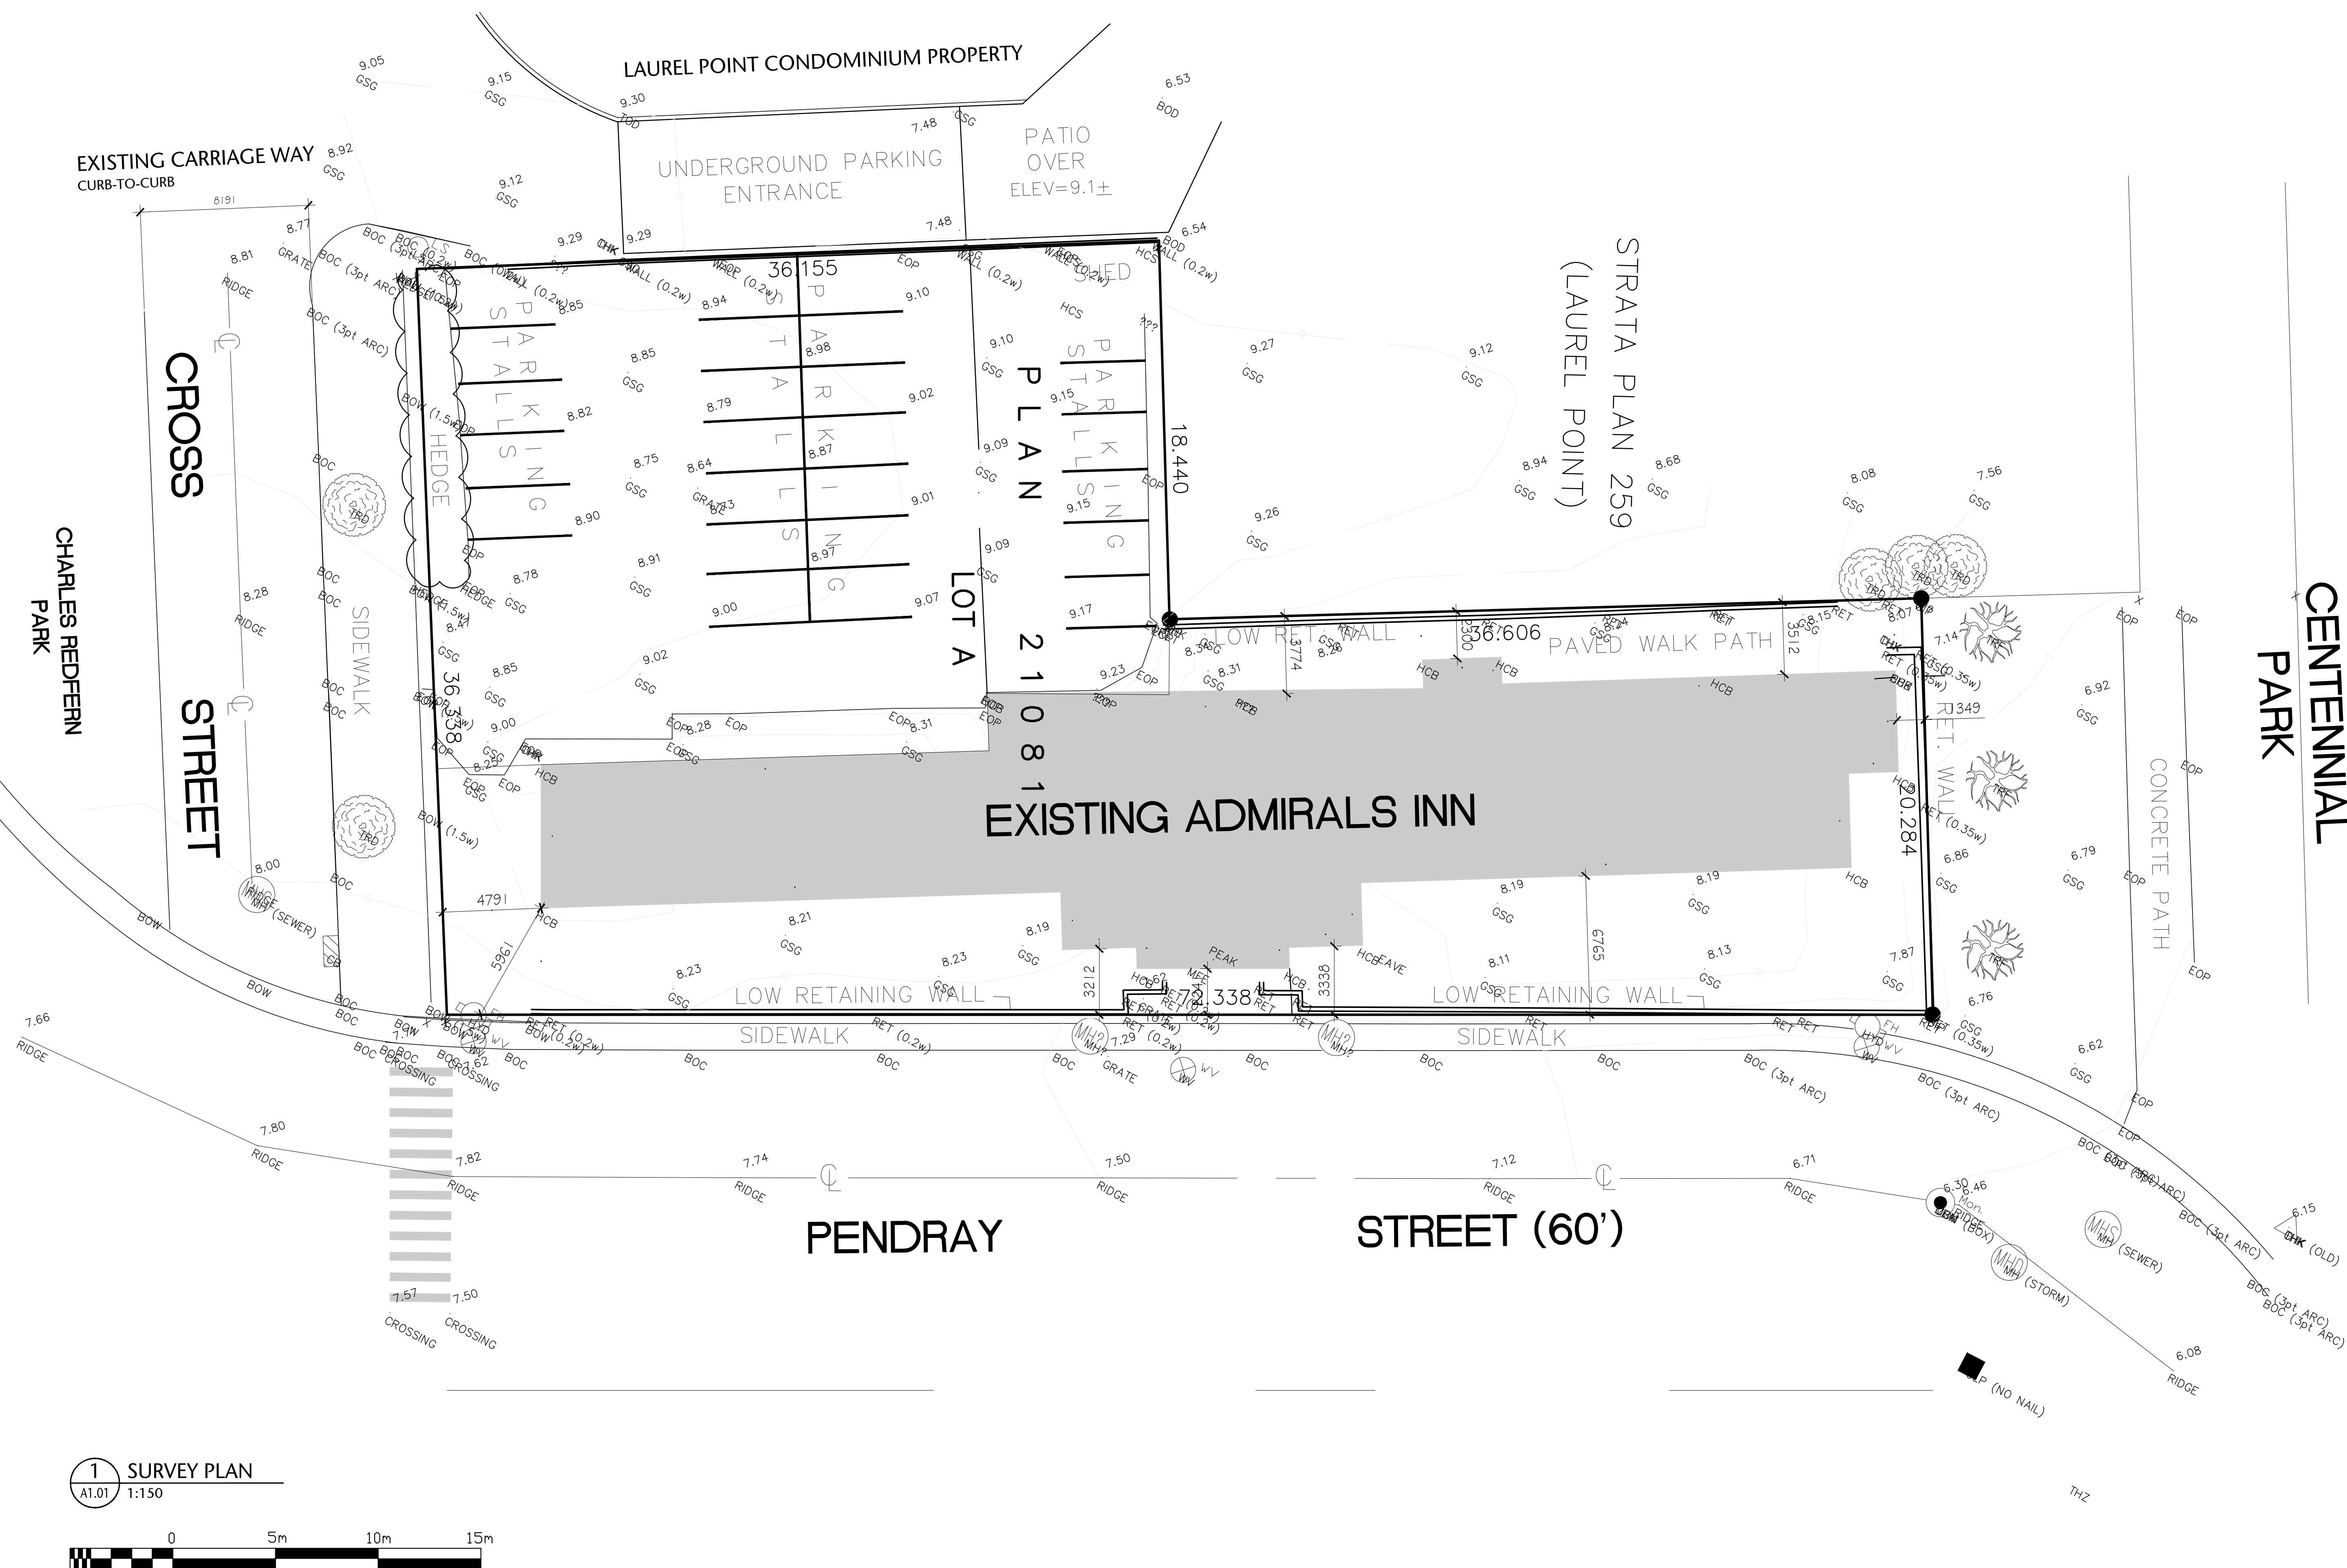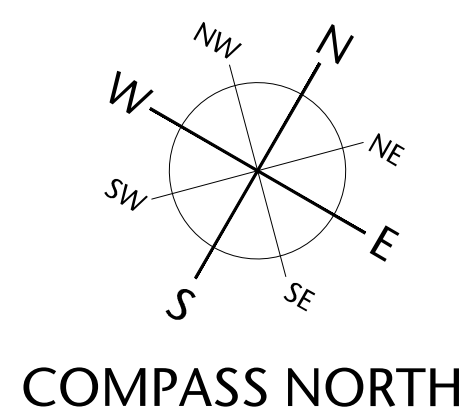

VICTORIA, BRITISH COLUMBIA

[illegible]

consultant

alan **lowe** architect inc.



mtalink.com Urban Design Architecture Interior Design


drawing title

SURVEY PLAN

A1.01

NA ^{drawn}	AS SHOWN ^{scale}
DL ^{checked}	20.118 ^{project no}

P:\2020\20.118.257 Belleville DP Renewal\ID Integrated Design\ID20 AutoCAD\ID22 Current\Sheets\A1.00\20.118.09-151-A1.02 OVERALL CONTEXT PLAN.dwg 2020/12/02 6:10 PM Iona Crunkiewicz

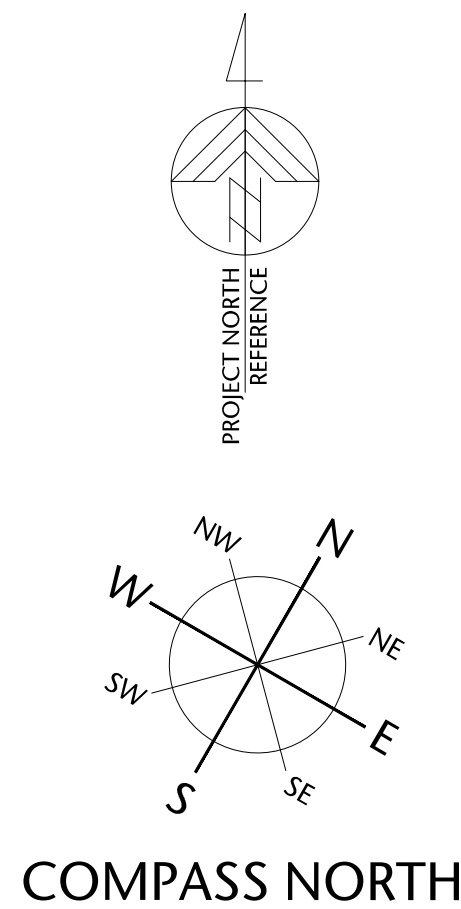

1 OVERALL CONTEXT PLAN
A1.02 NTS

0 10 20 30 40m
1:750

257 BELLEVILLE STREET

VICTORIA, BRITISH COLUMBIA

no.	issued for	date
1	DEVELOPMENT PERMIT	OCT 23/2012
2	DEVELOPMENT PERMIT	MAR 16/2020
3	REISSUED DEVELOPMENT PERMIT	DEC 03/2020



alan lowe architect inc.



310, 625 - 11 Ave SW Calgary AB T2R 0E1
T. 403.264.8700
F. 403.264.8029

mtalink.com Urban Design Architecture Interior Design


OVERALL CONTEXT PLAN

A1.02

drawn	scale
POR	AS SHOWN
checked	project no.
DL	20.118

COPYRIGHTED. This design is the exclusive property of the Architect and shall not be reproduced without the Architects written permission. These drawings are to be read in conjunction with the specifications, structural, mechanical and electrical drawings. This drawing must not be scaled. All dimensions, data and levels shall be verified before construction, and all errors or omissions reported immediately to the Architect.

P:\2020\20.118.257 Belleville DP Renewal\1D Integrated Design\20 AutoCAD\222 Current\Sheets\A1.00.20.118.09-151-A1.03 SITE PLAN.dwg 2021/06/07 5:20 PM Iona Cunliffe

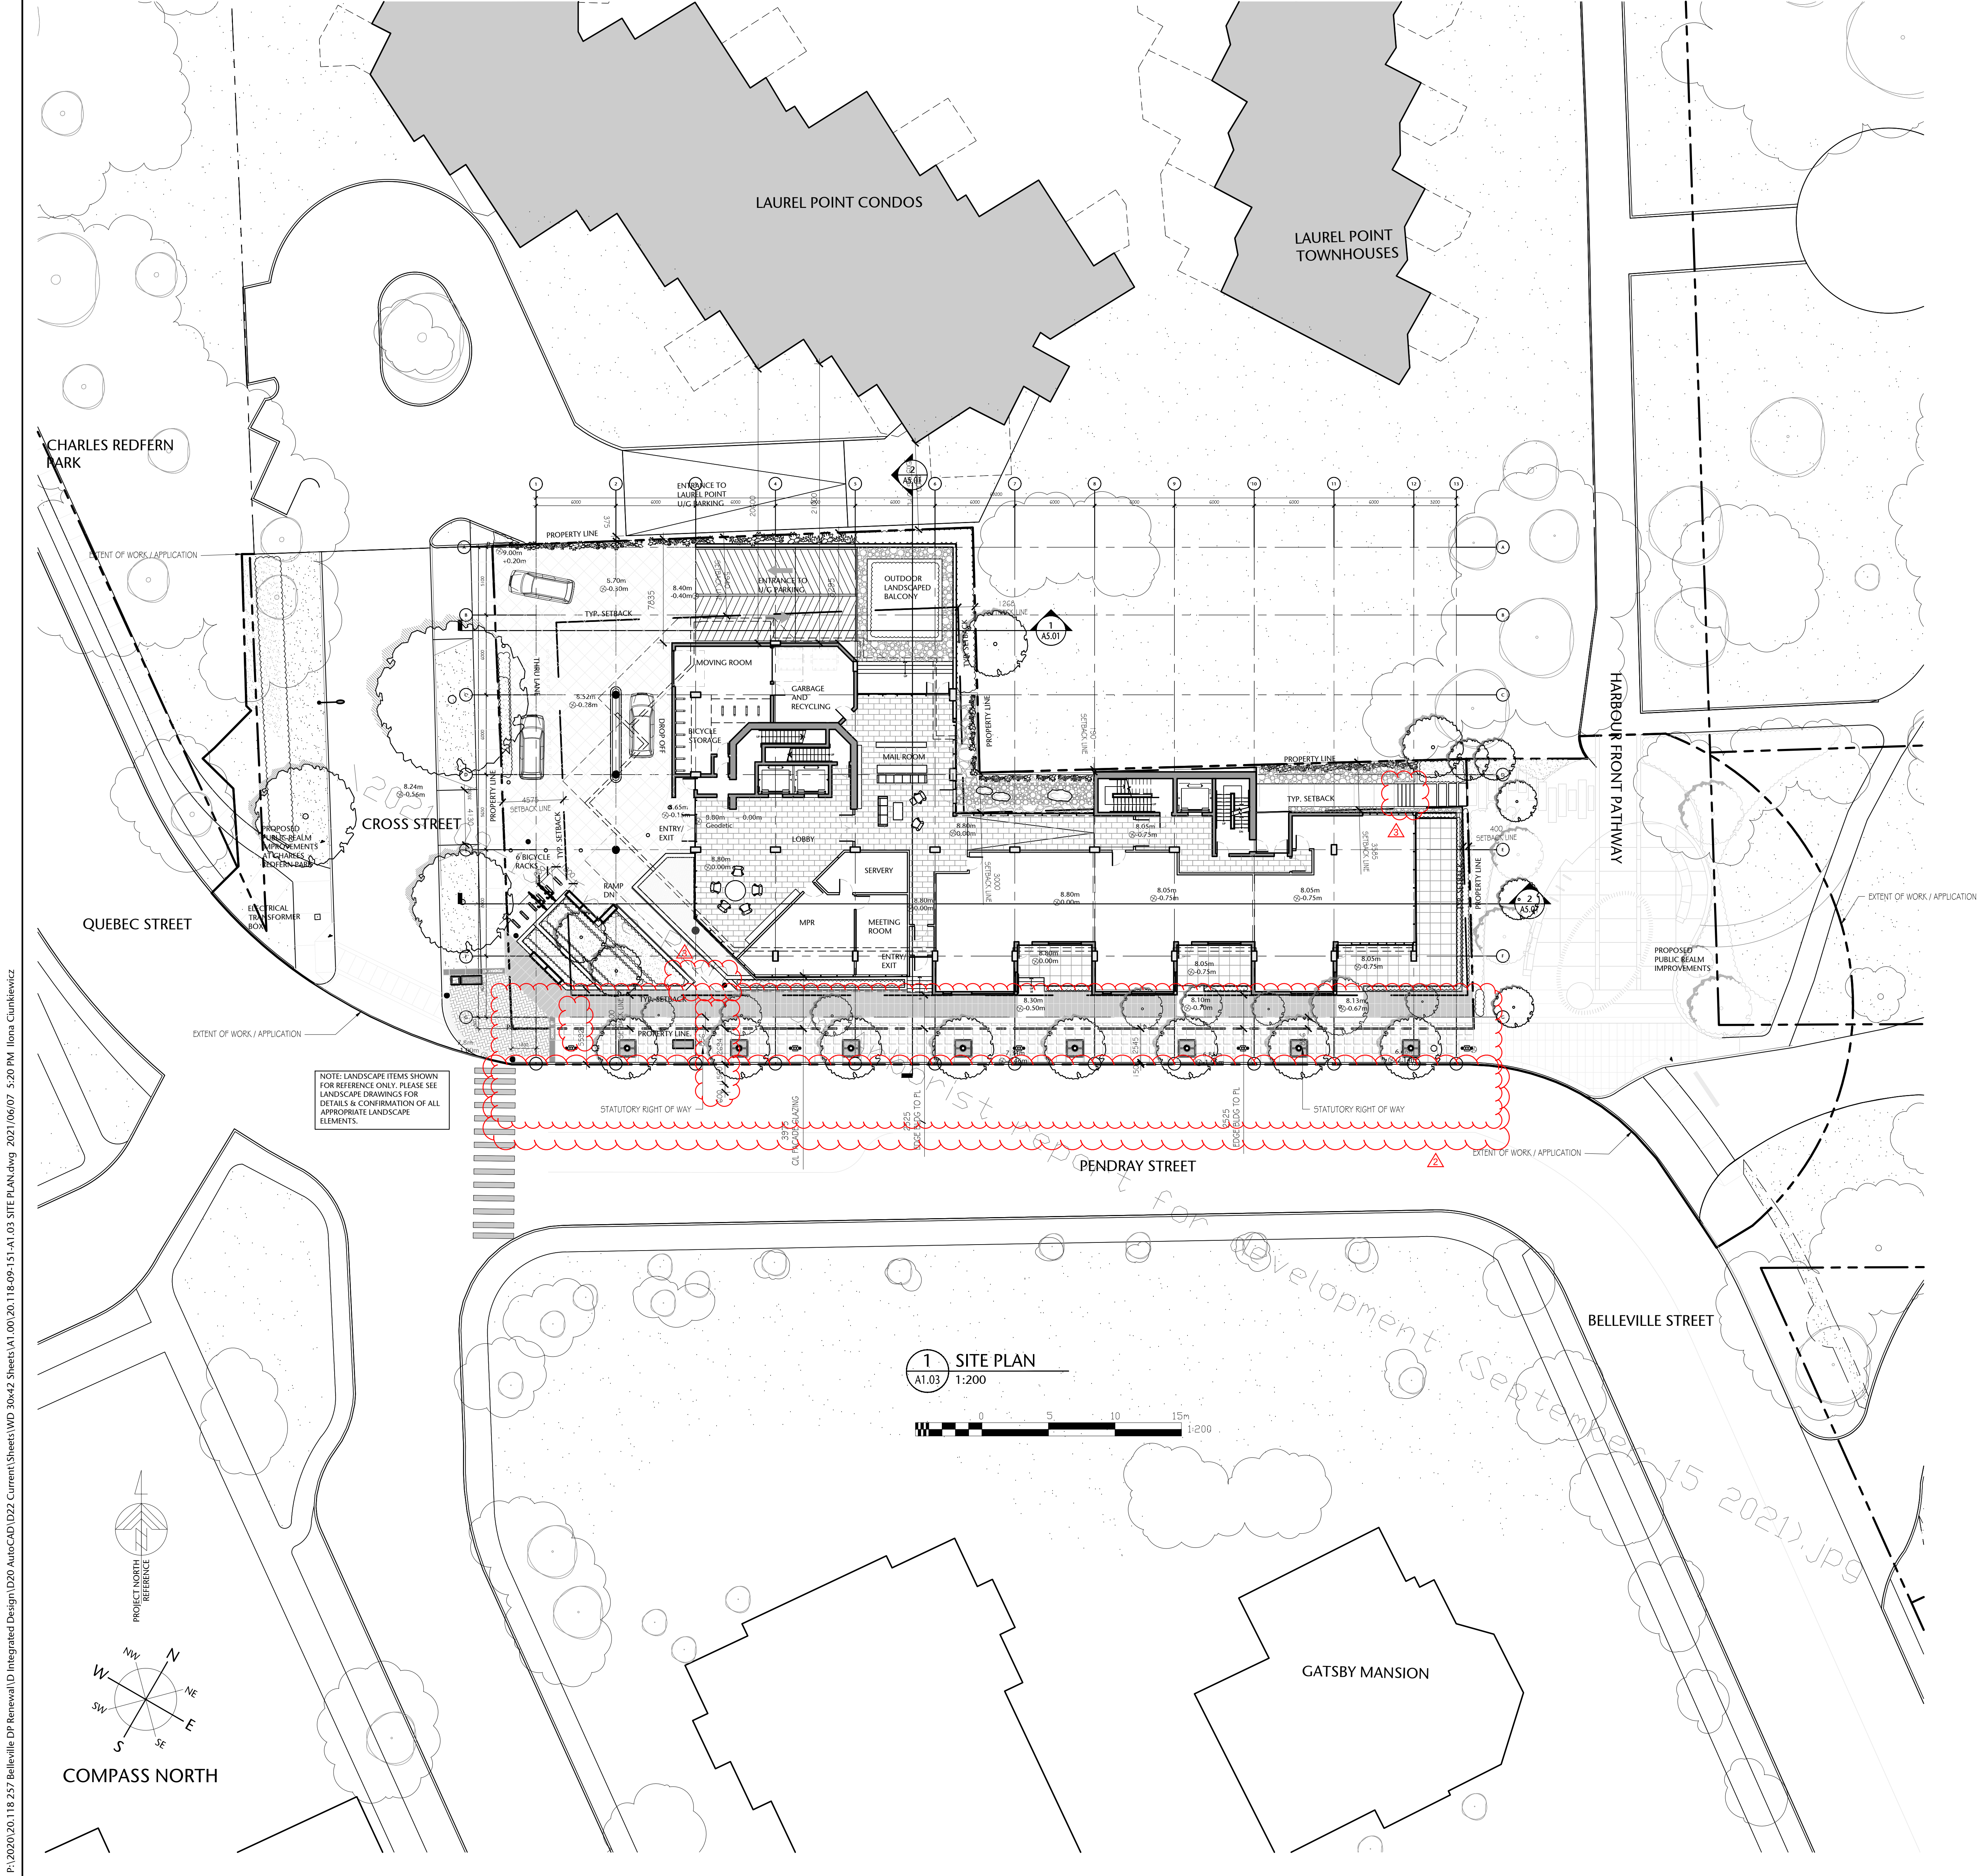

MUNICIPAL ADDRESS
257 BELLEVILLE STREET, VICTORIA, BC
LEGAL ADDRESS
LOT A, VICTORIA CITY, PLAN 21081
LAND USE DESCRIPTION
EXISTING: R-65 PROPOSED: R-65

PROJECT STATISTICS			
	Existing Zoning	Existing Building	Proposal
Zoning	R-65		R-65
Site Area (m²)	2000	2053.88	2053.88
Site Coverage (%)	45%	30%	53%
Building Area		619.15	1092.56
Main Floor (m²)			870.14
Gross Floor Area (above Grade excl. Balconies, incl. mech.)			6153.22
Floor Space Ratio	3.00:1	0.90	2.995
Building Height (m)	30	15	32 (incl. mechanical penthouse)
Number of Floors	N/A	3	9
Setbacks (m)			
1. "North Elevation"	0.0		
CL 1-mid 6/7		21.86	5.94
CL mid 6/7-8		3.64	3.00
CL 8-10		2.30	0.19
CL 10-13		3.51	3.585
2. "South Elevation"	2.5	2.23	2.50
3. "West Elevation"	4.5	4.8	4.575
4. "East Elevation"	0.4	1.34	0.40
CL D-G			1.26
CL A-D			
Note: Existing Setbacks to relative proposed Gridlines			
Open Space (%)	40%	31.7%	28.5%
Parking Stalls	40	25	78
Bicycle Parking	1.25/unit		6 @ Entry & 71 @ Main & Parkade Level

Net to Gross Ratio	1.28
Parkade Level P1 Area	1846 m²
Parkade Level P2 Area	1846 m²
Number of Floors above Grade	9 incl. Roof Top Mechanical (Laurel Point - 11)
Total Height @ Top of Parapet (excl. Mechanical Room)	30000mm (Laurel Point - 32000mm)
Floor to Floor Height (Typ.)	3350mm
Podium Floor to Floor	4500mm
Typ. Slab thickness	225mm
Zero Elevation	8.80m (center of Cross Street near Lobby)
Number of Units	32-57 (Max. 57 units)
Parking stall count	Min 40 required 78 stalls provided / including 6 Handicap and 6 Visitor U/G

GENERAL NOTES REGARDING UNITS: Building makes use of an open plan concept. Unit sizes and types will vary depending on end-user's unit configuration. Number and type of unit will vary. Below is a sample configuration of the building.		
Typical Unit Configuration	Avg. No.	Avg. Area/unit (m²)
1 BEDROOM	5	110
1 Bedroom & Den	15	125
2 BEDROOM	9	195
Ground Oriented Access	3	115

BUILDING AREA CALCULATION	
BUILDING GROSS AREAS MEASURED TO THE INSIDE FACE OF THE EXTERIOR WALLS	
OPEN SITE SPACE CALCULATION	
CALCULATION BASED ON CITY OF VICTORIA "SCHEDULE A" DEFINITION OF OPEN SITE SPACE.	
OPEN SITE SPACE MEANS THAT PORTION OF THE LOT: A) WHICH FROM THE SURFACE OF THE LOT IN A VERTICAL COLUMN UPWARD IS NOT OCCUPIED OR OBSTRUCTED BY THE BUILDING OR ITS PARTS EXCEPT: 1) ACCESSORY GARDEN STRUCTURE 2) BALCONY OR ROOF PROJECTION B) WHICH IS GRADED AND LANDSCAPED	

257 BELLEVILLE STREET

VICTORIA, BRITISH COLUMBIA

no.	issued for	date
1	DEVELOPMENT PERMIT	OCT 23/2012
2	DP ADDITIONAL ITEMS	DEC 05/2012
3	DEVELOPMENT PERMIT	MAR 16/2020
4	REISSUED DEVELOPMENT PERMIT	DEC 03/2020
5	REISSUED DEVELOPMENT PERMIT	JUN 07/2021
6	REISSUED DEVELOPMENT PERMIT	DEC 06/2021
7	REISSUED DEVELOPMENT PERMIT	APR 11/2022



consultant

alan lowe architect inc.



drawing title	
SITE CONTEXT PLAN & DATA SHEET	
sheet	
A1.03	
drawn	scale
POR	AS SHOWN
checked	project no.
DL	20.118

COPYRIGHTED. This design is the exclusive property of the Architect and shall not be reproduced without the Architect's written permission. These drawings are to be read in conjunction with the specifications, structural, mechanical and electrical drawings. This drawing must not be scaled. All dimensions, data and levels shall be verified before construction, and all errors or omissions reported immediately to the Architect.

257 BELLEVILLE STREET

VICTORIA, BRITISH COLUMBIA

no.	issued for	date
1	DEVELOPMENT PERMIT	OCT 23/2012
2	DEVELOPMENT PERMIT	MAR 16/2020
3	REISSUED DEVELOPMENT PERMIT	DEC 03/2020
4	REISSUED DEVELOPMENT PERMIT	JUN 07/2021
5	REISSUED DEVELOPMENT PERMIT	DEC 06/2021



alan lowe architect inc.




Urban Design Architecture Interior Design

DETAILED SITE PLAN

A1.04


drawn	scale
POR	AS SHOWN
checked	project no.
DL	20.118

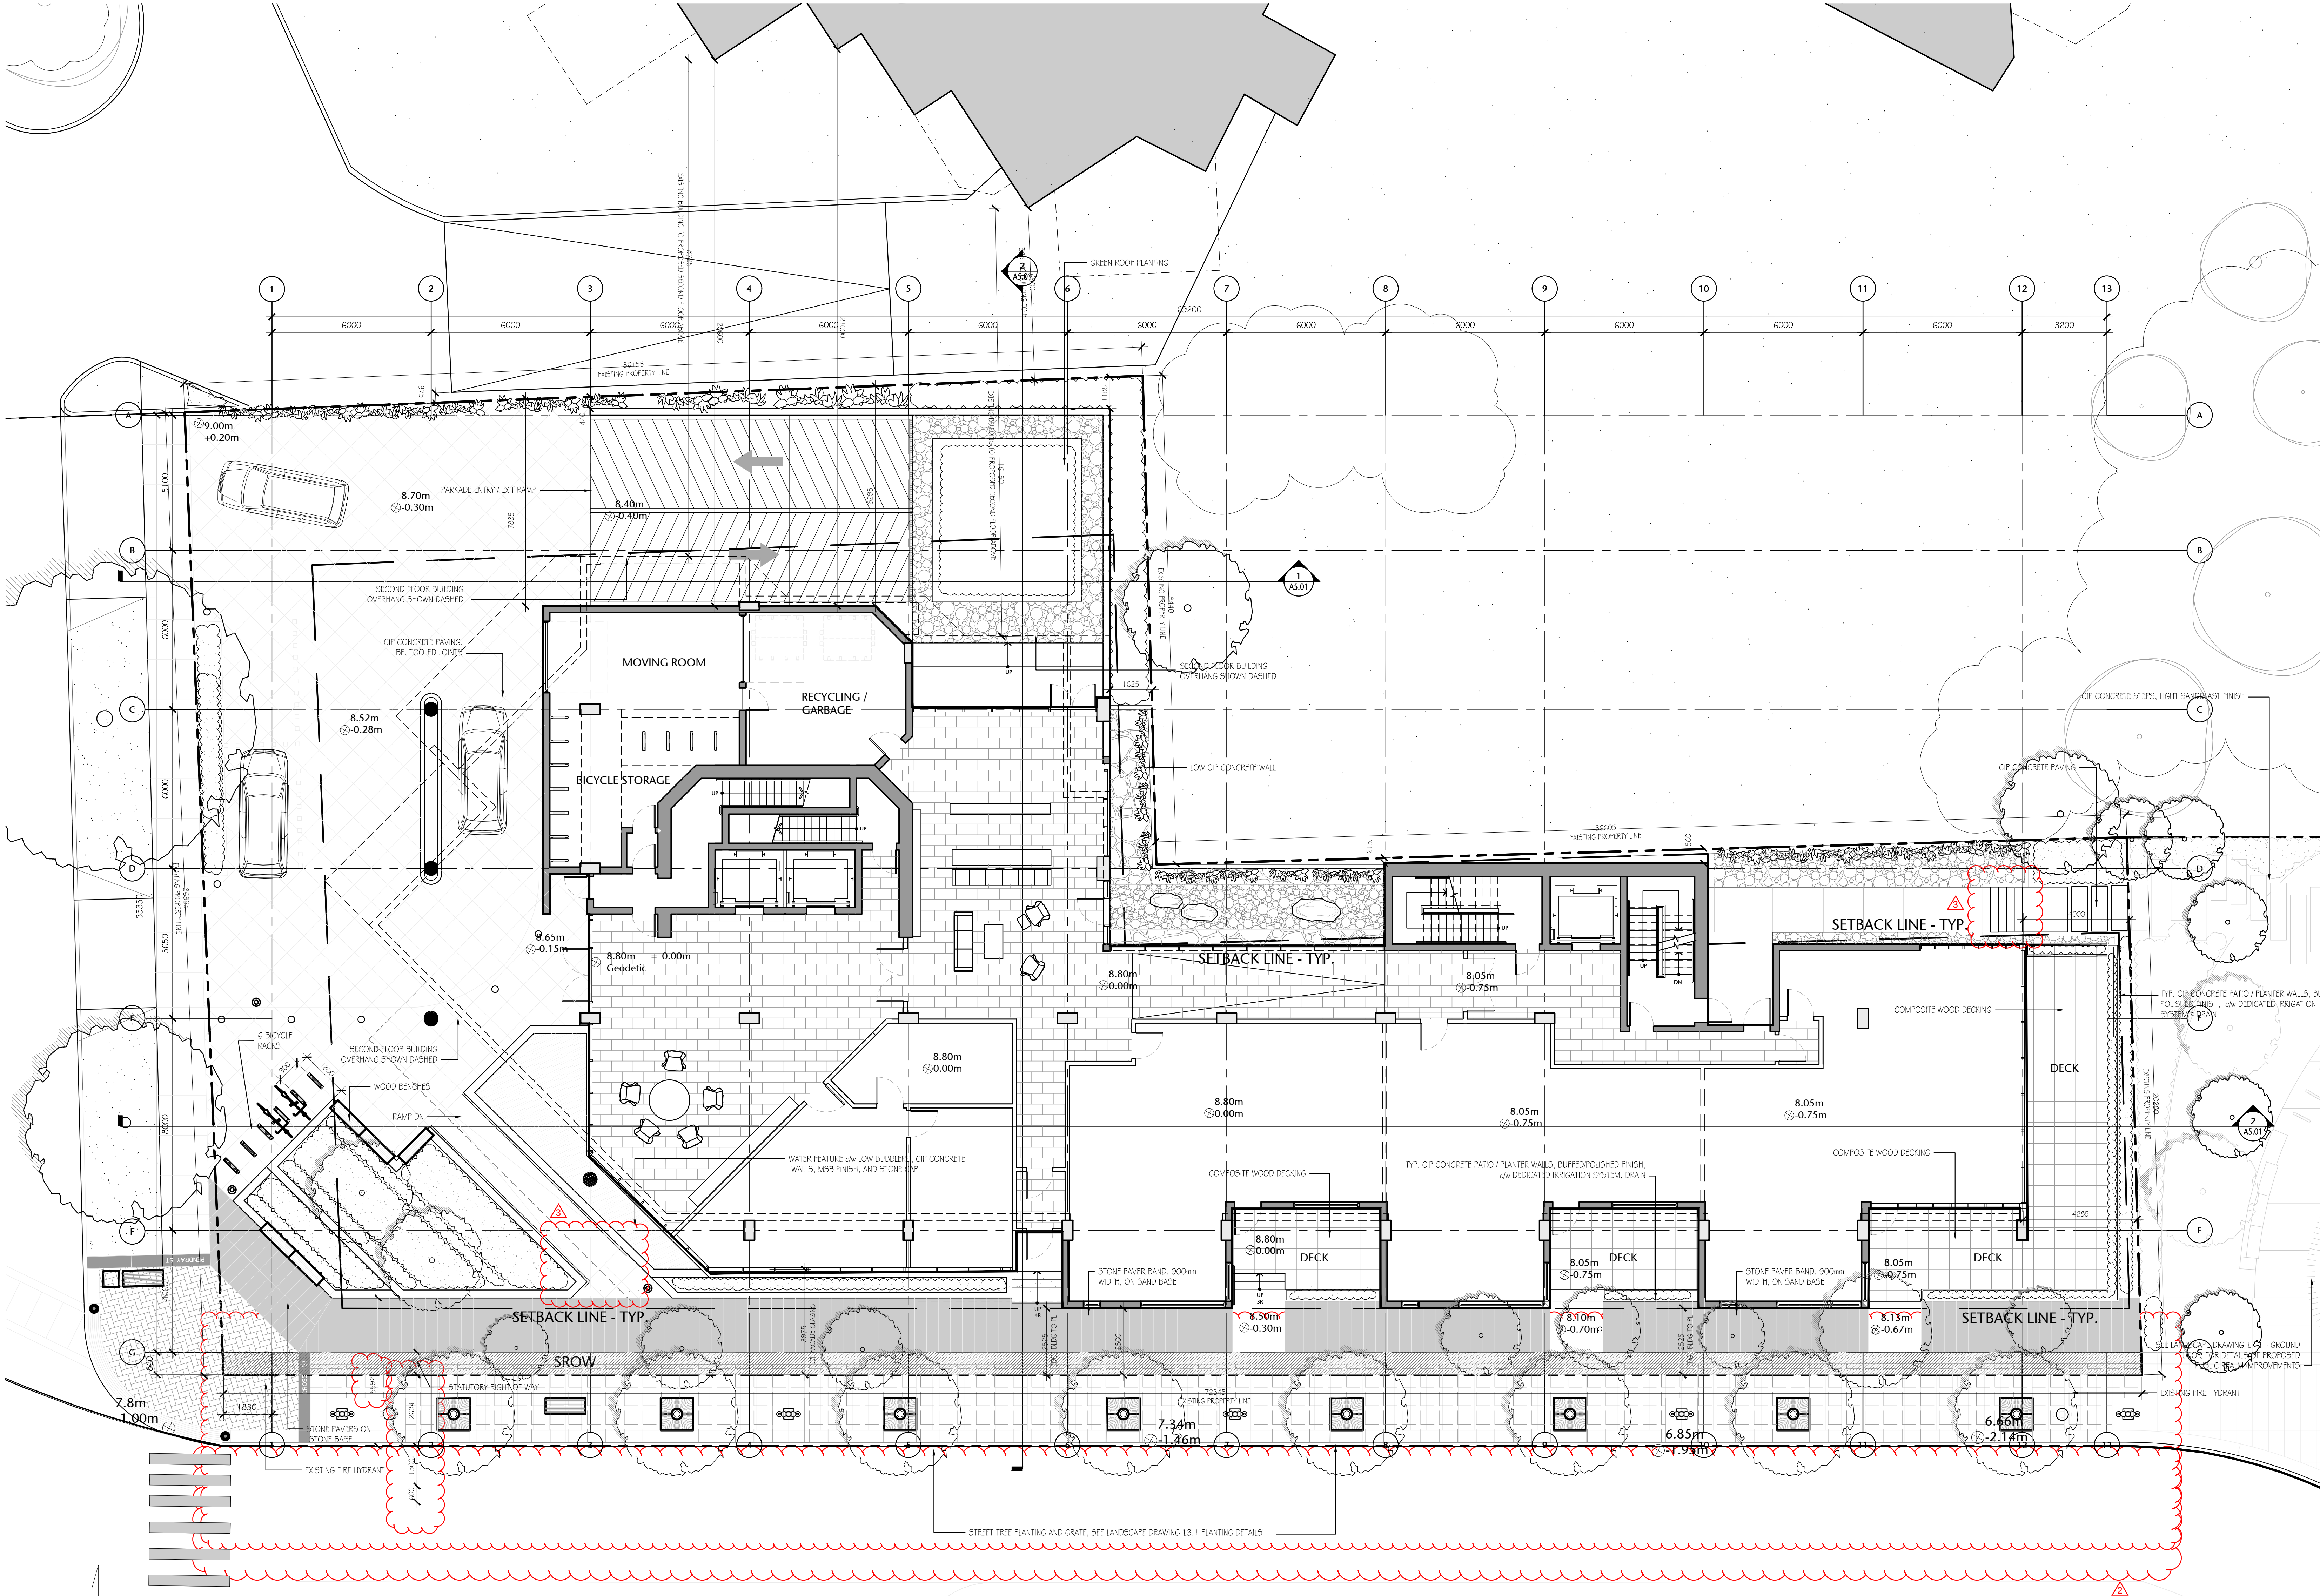

NOTE: LANDSCAPE ITEMS SHOWN FOR REFERENCE ONLY. PLEASE SEE LANDSCAPE DRAWINGS FOR DETAILS & CONFIRMATION OF ALL APPROPRIATE LANDSCAPE ELEMENTS.

NOTE: FOR TYPICAL LANDSCAPE FINISHES & GRADING, SEE LANDSCAPE DRAWINGS

SCHEDULE A
STATUTORY RIGHT OF WAY SHOWN HATCHED

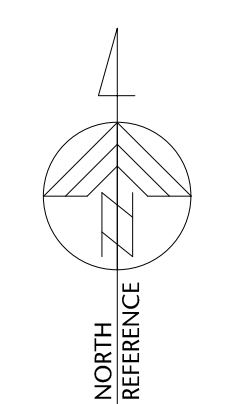

1 DETAILED SITE PLAN
A1.04 1:150

COMPASS NORTH

P:\2020\20.118 257 Belleville DP Renewal\DP Renewal\ID Integrated Design\20 AutoCAD\ID22 Current\Sheets\WD 3042 Sheets\A1 00.118-09-151-A1.04 SITE PHOTOS.dwg 2021/06/07 5:24 PM Ilona Cunliewicz



1 QUEBEC STREET LOOKING EAST DOWN PENDRAY STREET
NTS

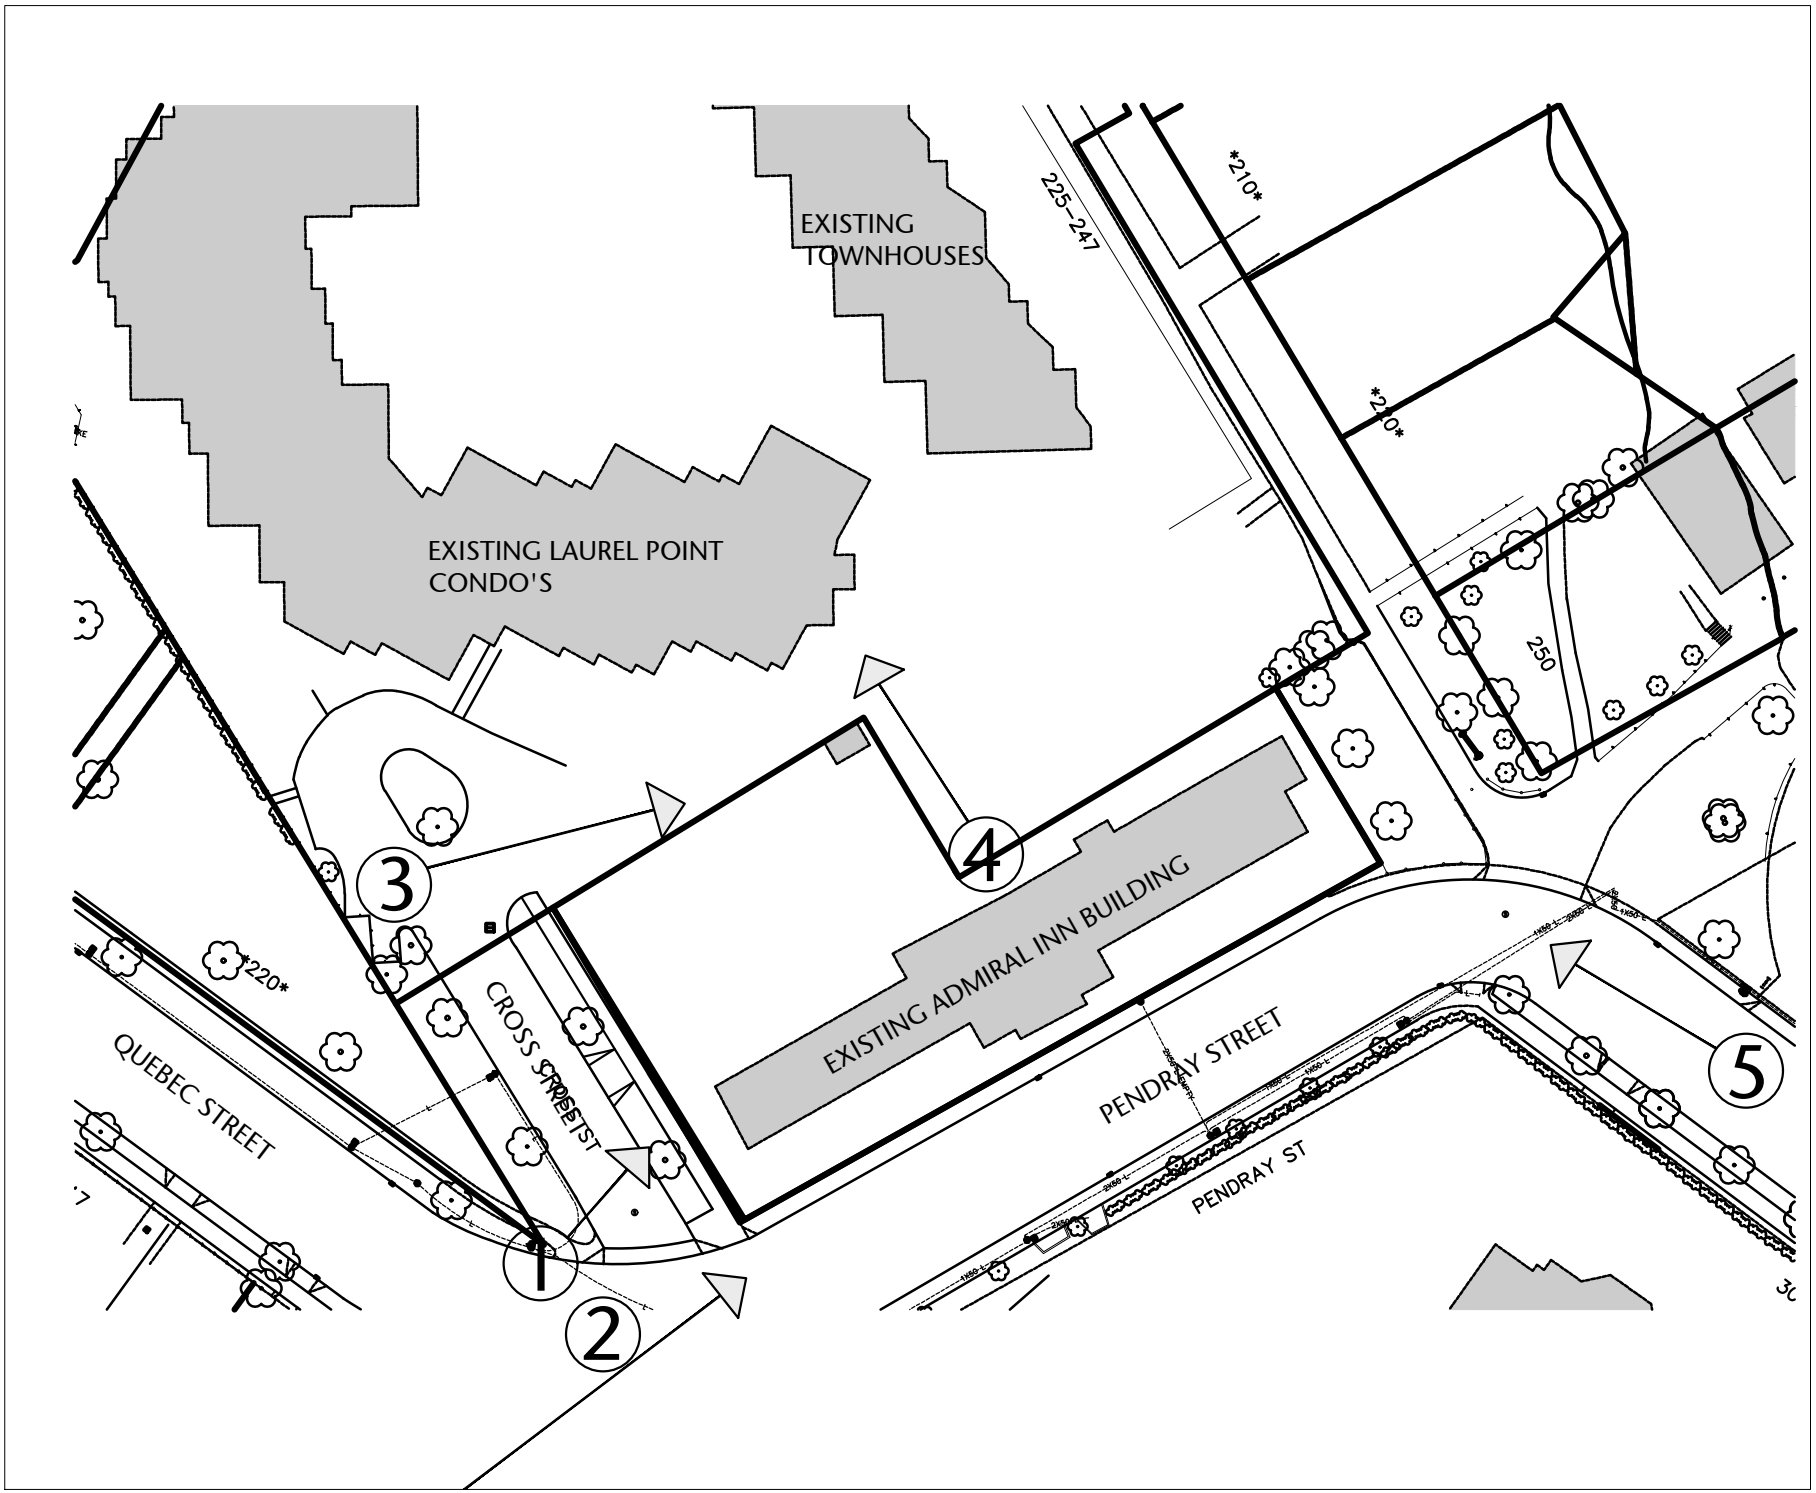


PHOTO LOCATION PLAN
NTS



2 PENDRAY STREET LOOKING NORTH - EXISTING ADMIRAL'S INN BUILDING
NTS



3 VIEW LOOKING SOUTH DOWN CROSS STREET
NTS



4 LOOKING NORTH AT ADJACENT LAUREL POINT CONDO'S
NTS



5 VIEW LOOKING NORTH UP BELLEVILLE STREET - EXISTING ADMIRAL'S INN BUILDING
NTS

257 BELLEVILLE STREET

VICTORIA, BRITISH COLUMBIA

no.	issued for	date
1	DEVELOPMENT PERMIT	OCT 23/2012
2	DEVELOPMENT PERMIT	MAR 16/2020
3	REISSUED DEVELOPMENT PERMIT	DEC 03/2020



seal

permit

consultant

alan **lowe** architect inc.



mtalink.com Urban Design Architecture Interior Design

drawing title



SITE PHOTOS

A1.05


sheet

drawn	scale
NA	NTS
checked	project no.
DL	20.118

P:\2020\20.118 257 Belleville DP Renewal\1D Integrated Design\20 AutoCAD\022 Current\Sheets\WD 30x42 Sheets\A2.01A PARKADE LEVEL P1.dwg 2021/01/05 4:03 PM Iona Ciumkevics

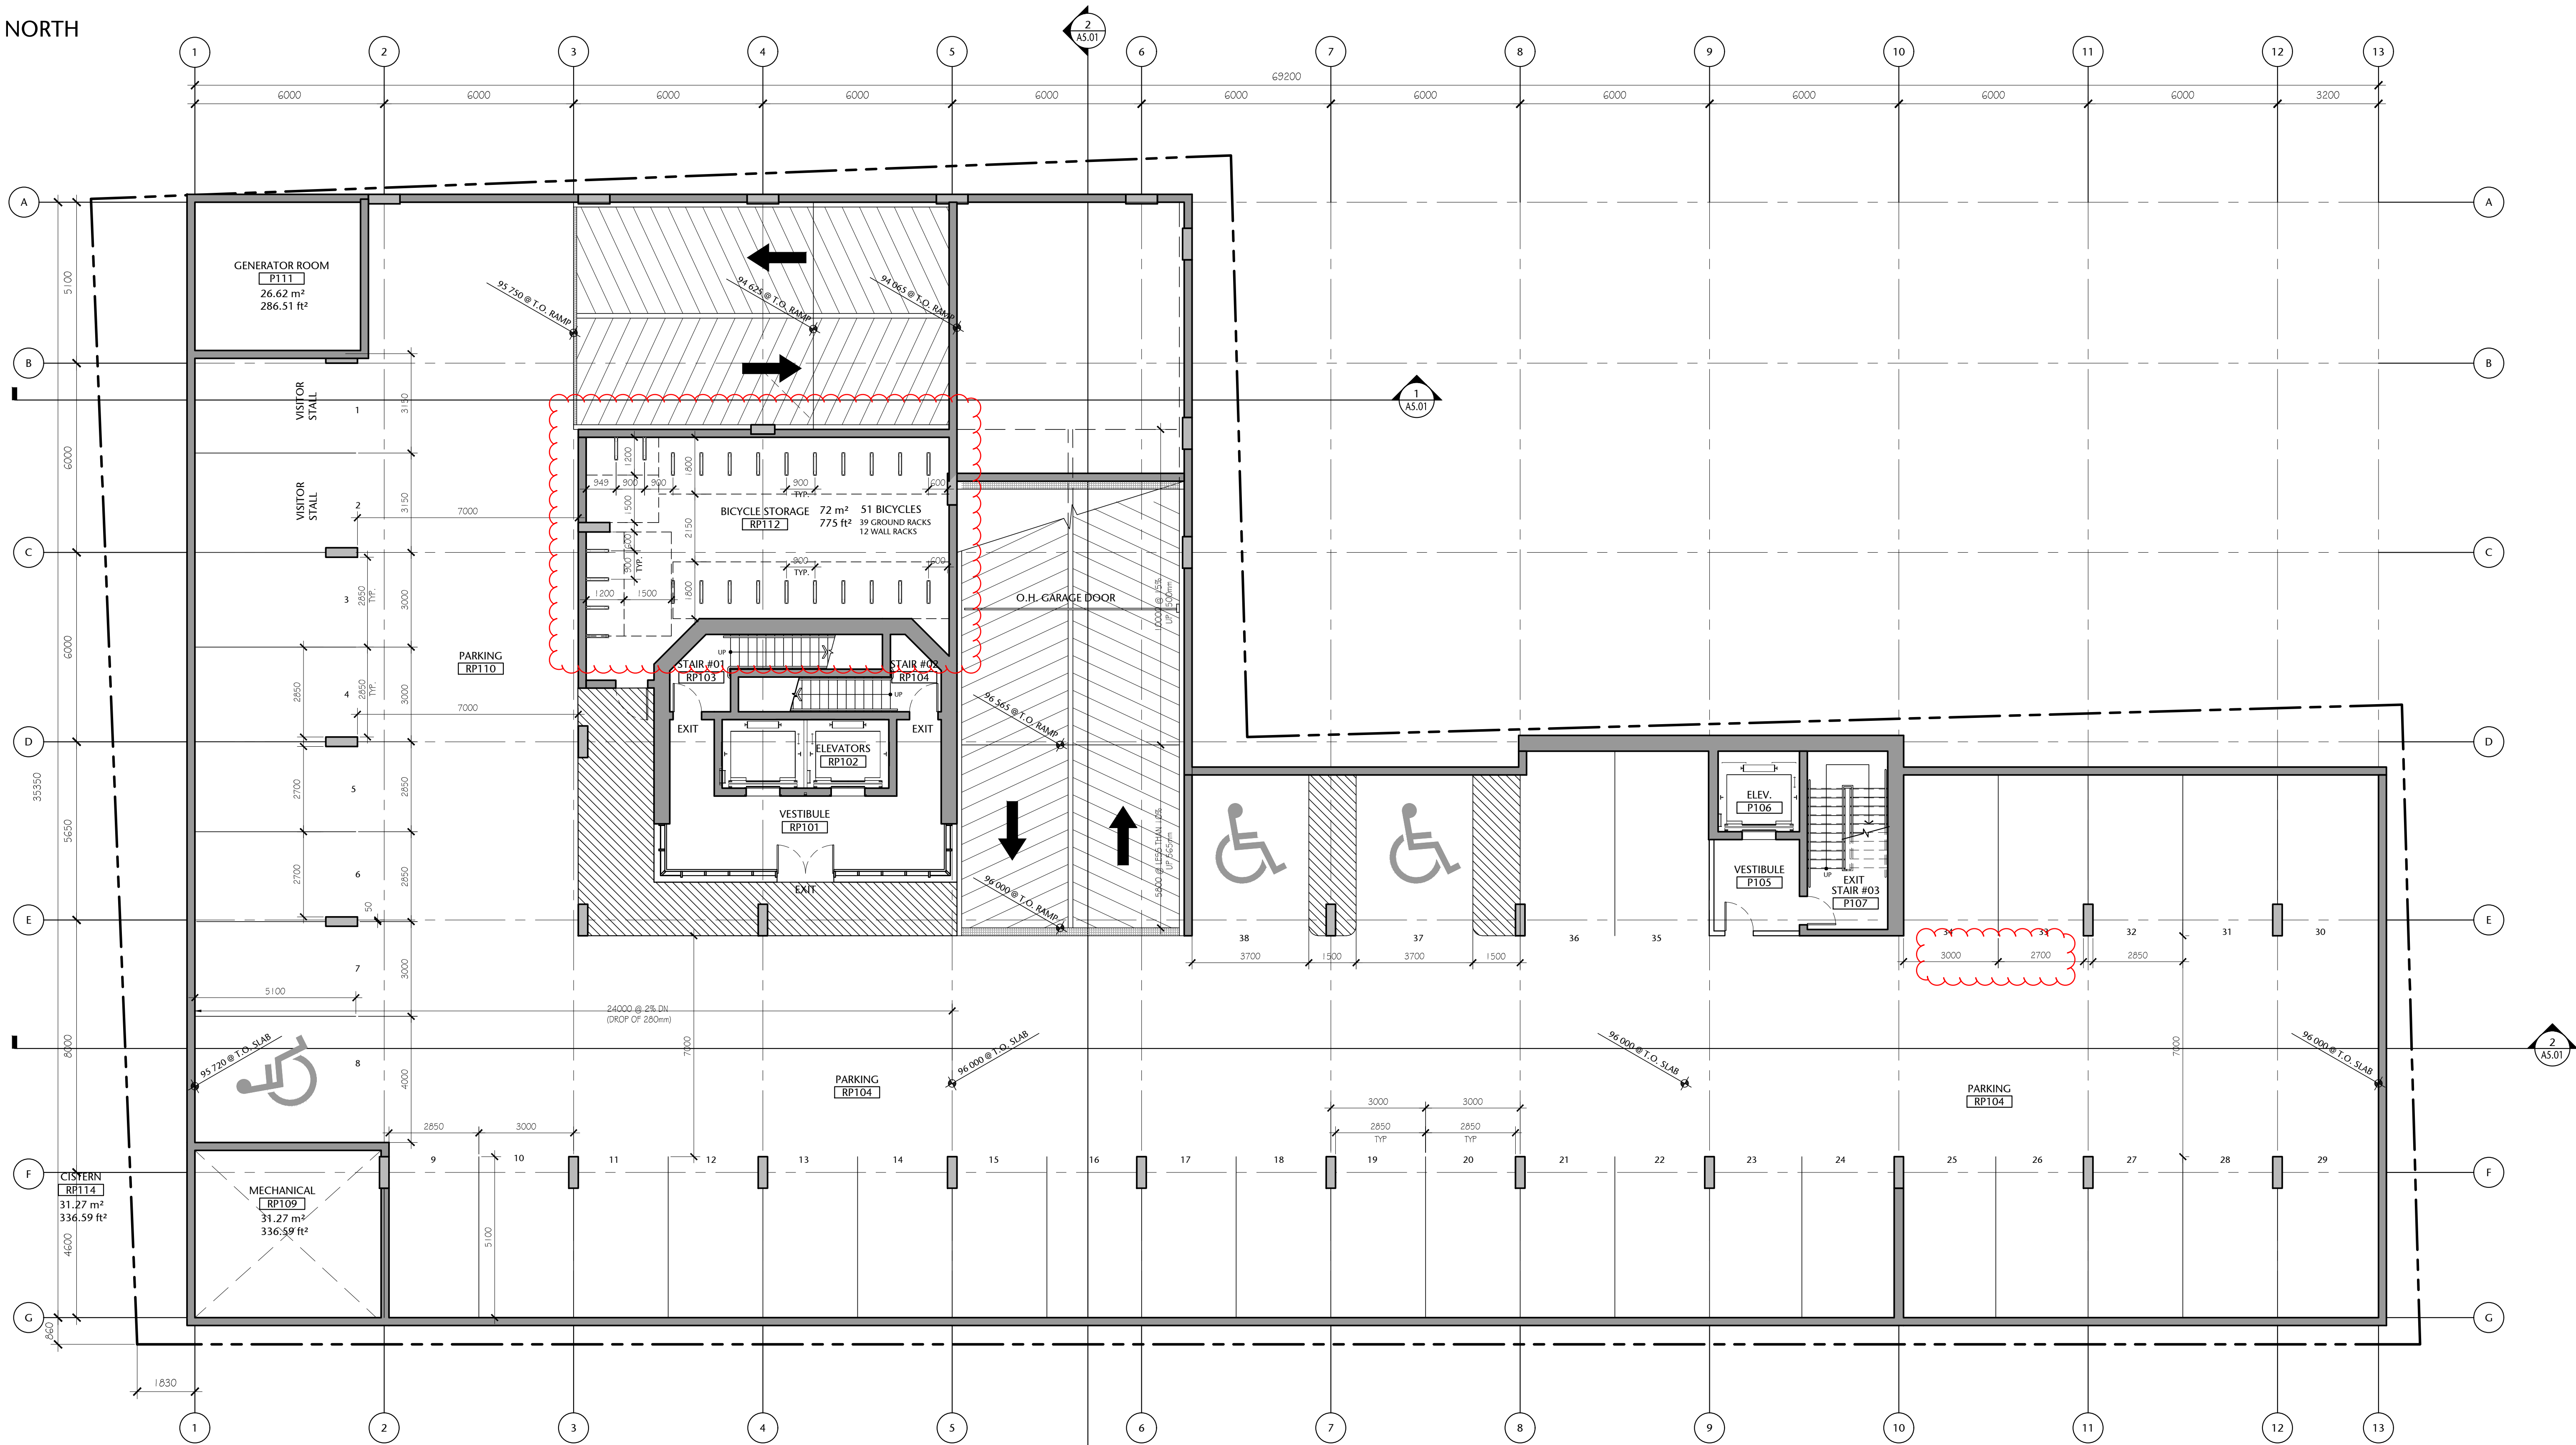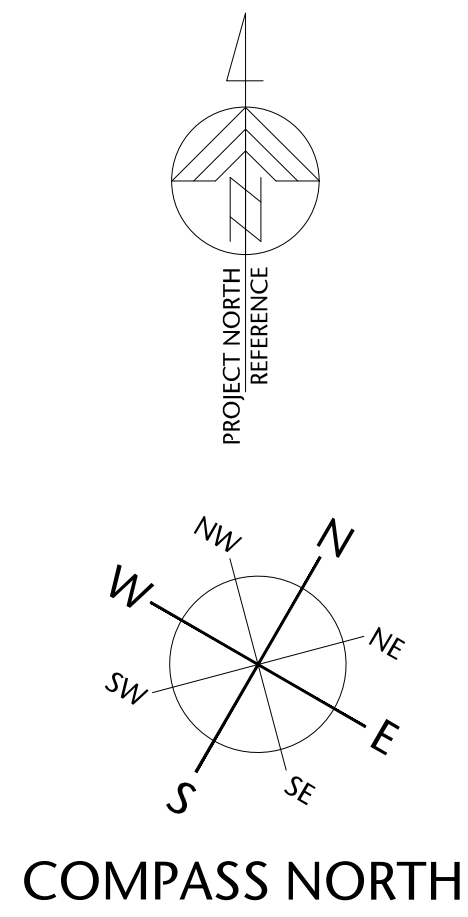

1 PARKADE LEVEL P1
A2.01
1:100

 

Parkade Level P1 General Notes:

1. PARKING STALL COUNT: 38 STALLS (40 INCLUDES 3 HC STALLS & 2 VISITOR STALLS)
2. TYPICAL STALL DIMENSION, 3m x 5.1m WITH A 7m DRIVE AISLE.
3. MECHANICAL, ELECTRICAL ROOM REQUIREMENTS TO BE CONFIRMED.

257 BELLEVILLE
STREET

VICTORIA, BRITISH COLUMBIA

no.	issued for	date
1	DEVELOPMENT PERMIT	OCT 23/2012
2	DP ADDITIONAL ITEMS	DEC 05/2012
3	DP ADDITIONAL ITEMS	DEC 12/2012
4	DEVELOPMENT PERMIT	MAR 16/2020
5	REISSUED DEVELOPMENT PERMIT	DEC 03/2020



consultant

alan **lowe** architect inc.



310, 625 - 11 Ave SW Calgary AB T2R 0E1
t. 403.264.8700
f. 403.264.8029

mtalink.com Urban Design Architecture Interior Design



drawing title
PARKADE LEVEL P1

A2.01A


drawn	scale
POR	AS SHOWN
checked	project no.
DL	20.118

COPYRIGHTED. This design is the exclusive property of the Architect and shall not be reproduced without the Architect's written permission. These drawings are to be read in conjunction with the specifications, structural, mechanical and electrical drawings. This drawing must not be scaled. All dimensions, data and levels shall be verified before construction, and all errors or omissions reported immediately to the Architect.

P:\2020\20.118 257 Belleville DP Renewal\1D Integrated Design\1D20 AutoCAD\1D22 Current\Sheets\WD 30x42 Sheets\A2.01B PARKADE LEVEL P2.dwg 2021/01/05 4:05 PM Iona Clunkiewicz

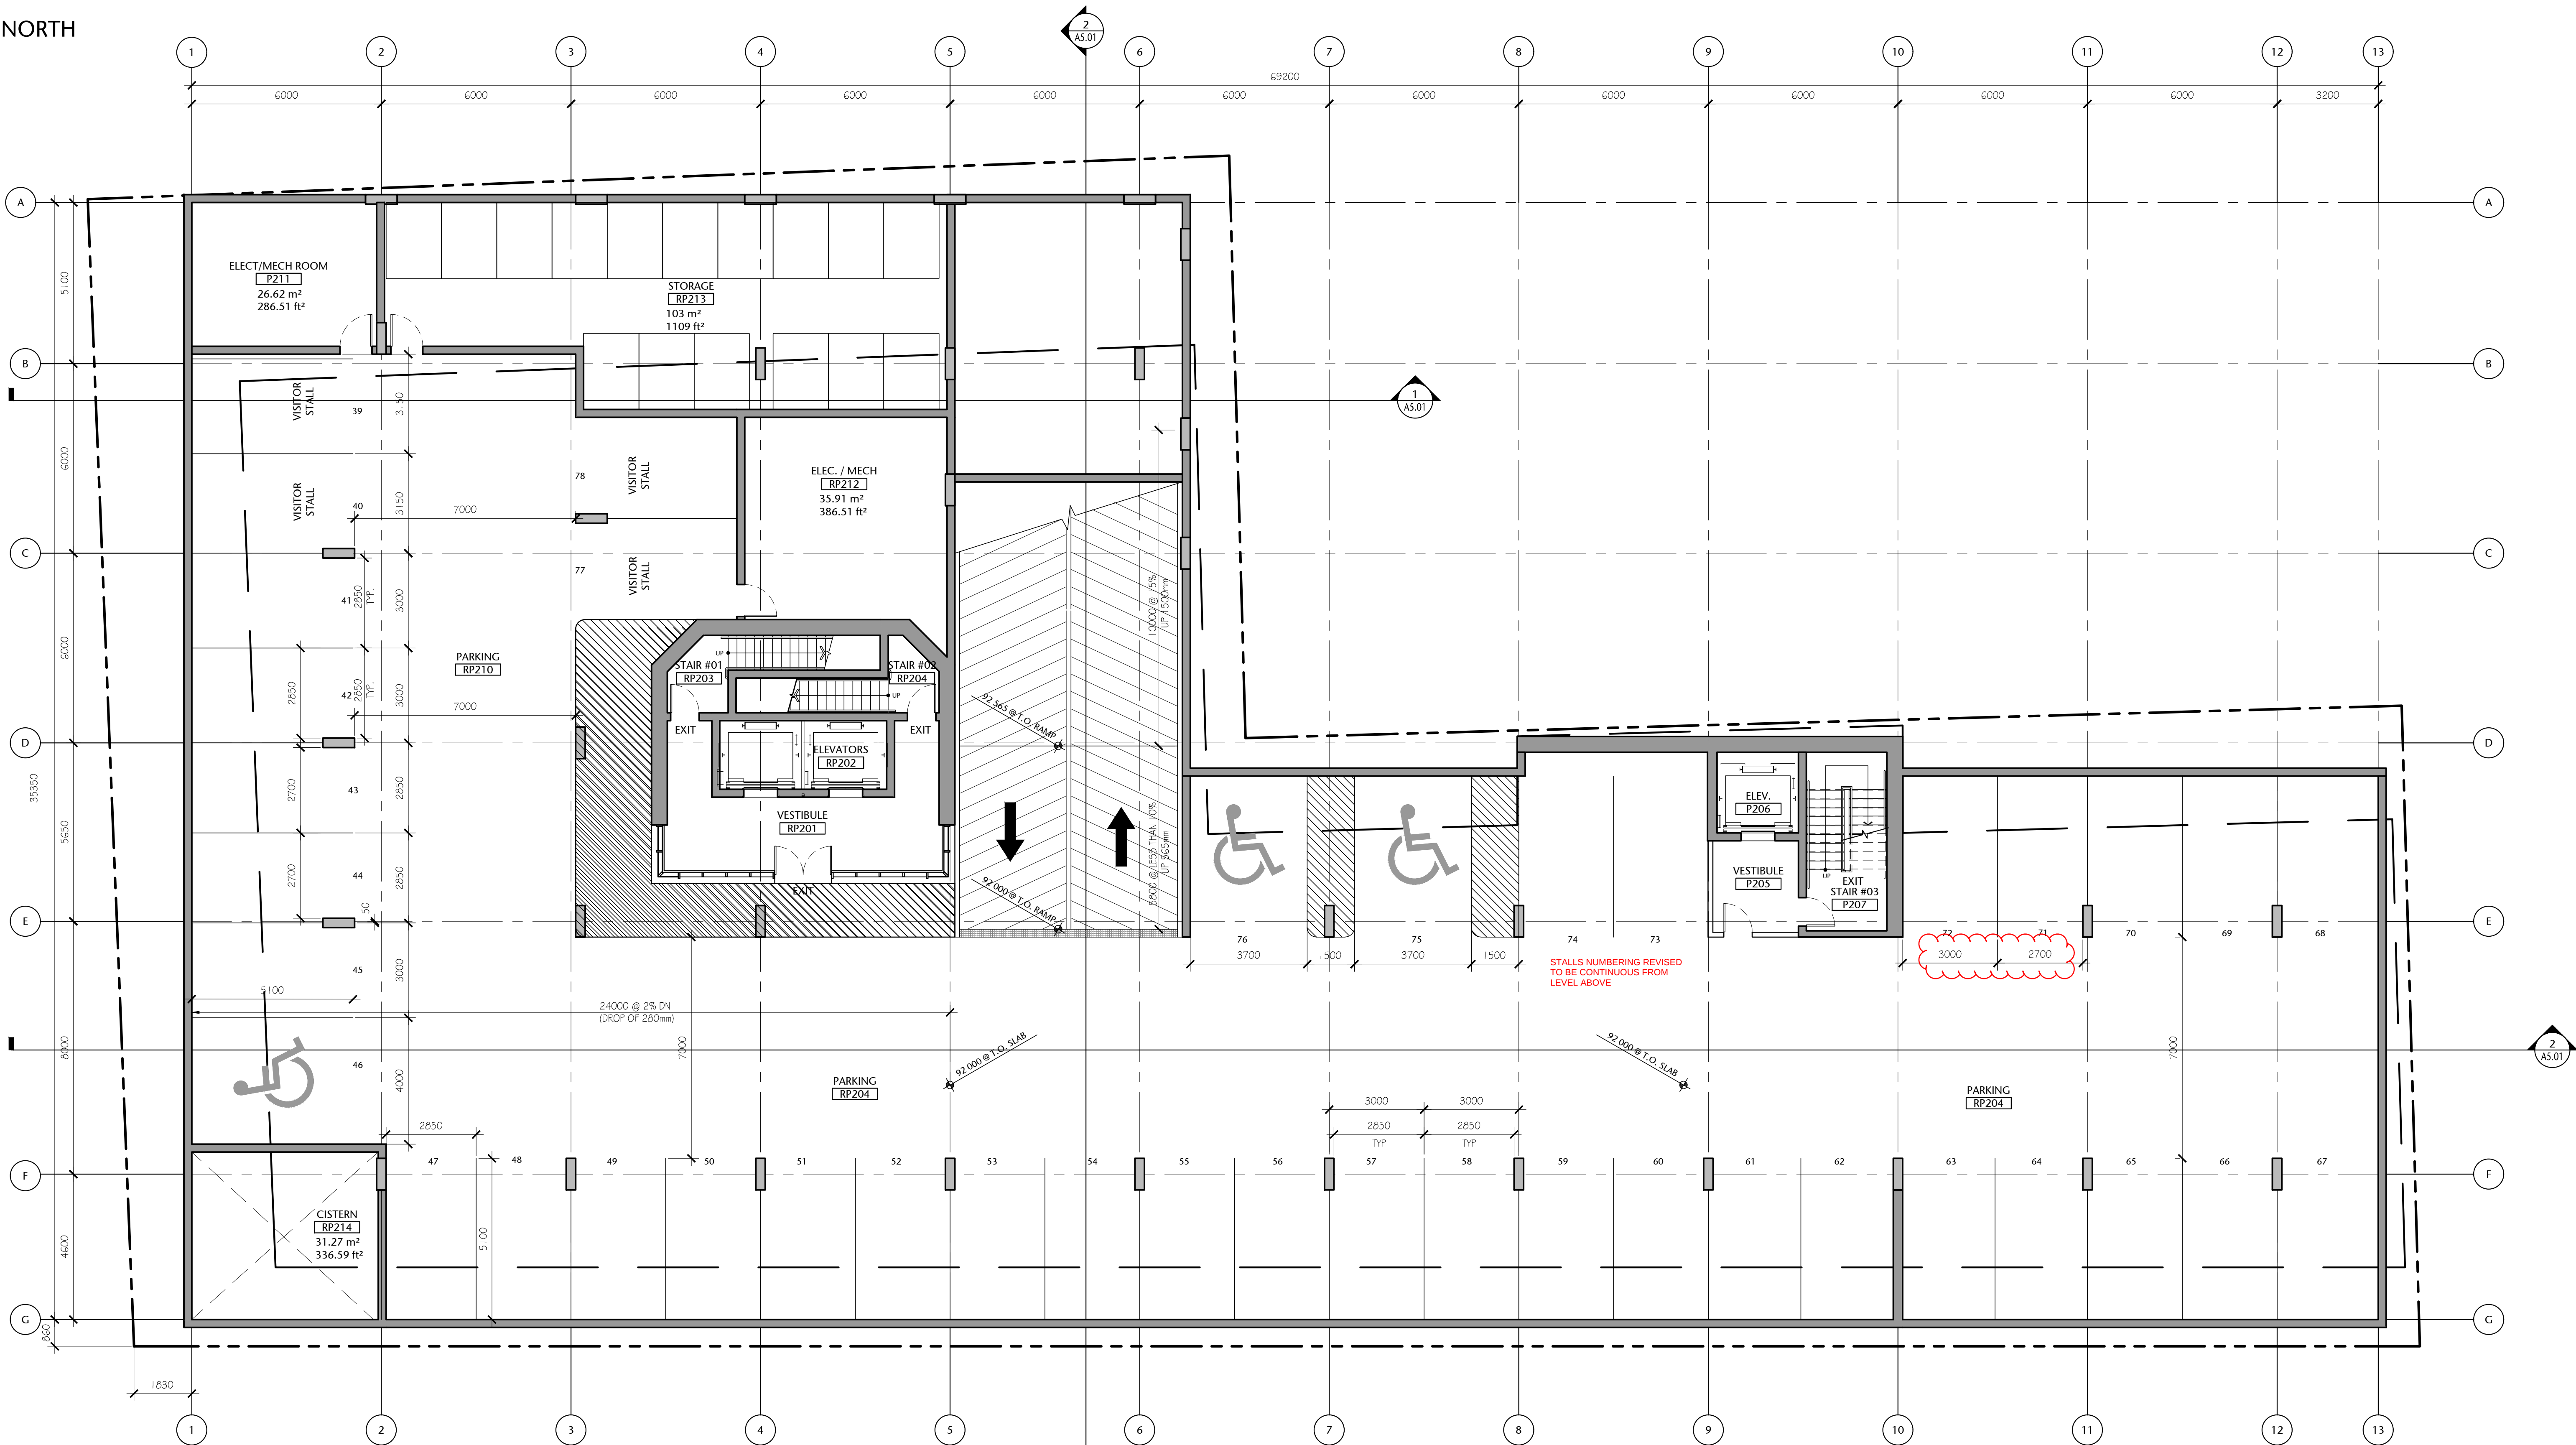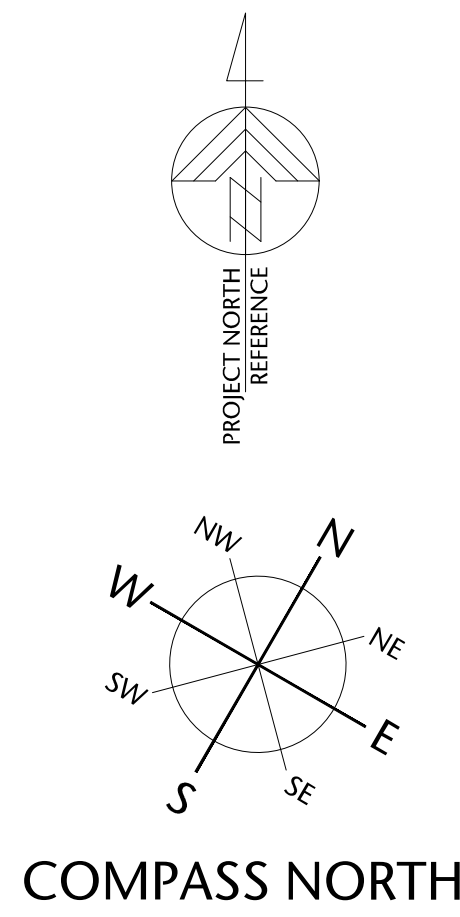

1 PARKADE LEVEL P2
A2.01B 1:100

 

Parkade Level P2 General Notes:

1. PARKING STALL COUNT: 40 STALLS (40 INCLUDES 3 HC STALLS & 4 VISITOR STALLS)
2. TYPICAL STALL DIMENSION, 3m x 5.1m WITH A 7m DRIVE AISLE.
3. TENANT STORAGE AS SHOWN. MECHANICAL, ELECTRICAL ROOM REQUIREMENTS TO BE CONFIRMED.

257 BELLEVILLE STREET

VICTORIA, BRITISH COLUMBIA

no.	issued for	date
1	DEVELOPMENT PERMIT	OCT 23/2012
2	DP ADDITIONAL ITEMS	DEC 05/2012
3	DP ADDITIONAL ITEMS	DEC 12/2012
4	DEVELOPMENT PERMIT	MAR 16/2020
5	REISSUED DEVELOPMENT PERMIT	DEC 03/2020



consultant

alan **lowe** architect inc.



310, 625 - 11 Ave SW Calgary AB T2R 0E1
t. 403.264.8700
f. 403.264.8029



mtalink.com Urban Design Architecture Interior Design

drawing title
PARKADE LEVEL P2


A2.01B

drawn POR	scale AS SHOWN
checked DL	project no. 20.118

COPYRIGHTED. This design is the exclusive property of the Architect and shall not be reproduced without the Architects written permission. These drawings are to be read in conjunction with the specifications, structural, mechanical and electrical drawings. This drawing must not be scaled. All dimensions, data and levels shall be verified before construction, and all errors or omissions reported immediately to the Architect.

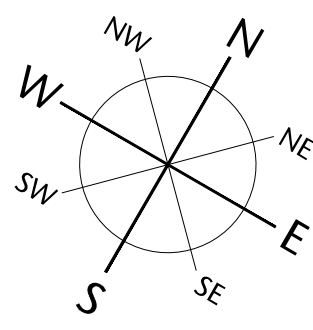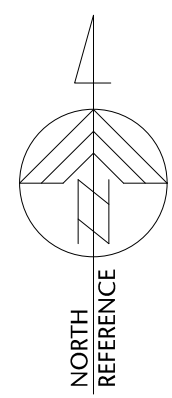

COMPASS NORTH

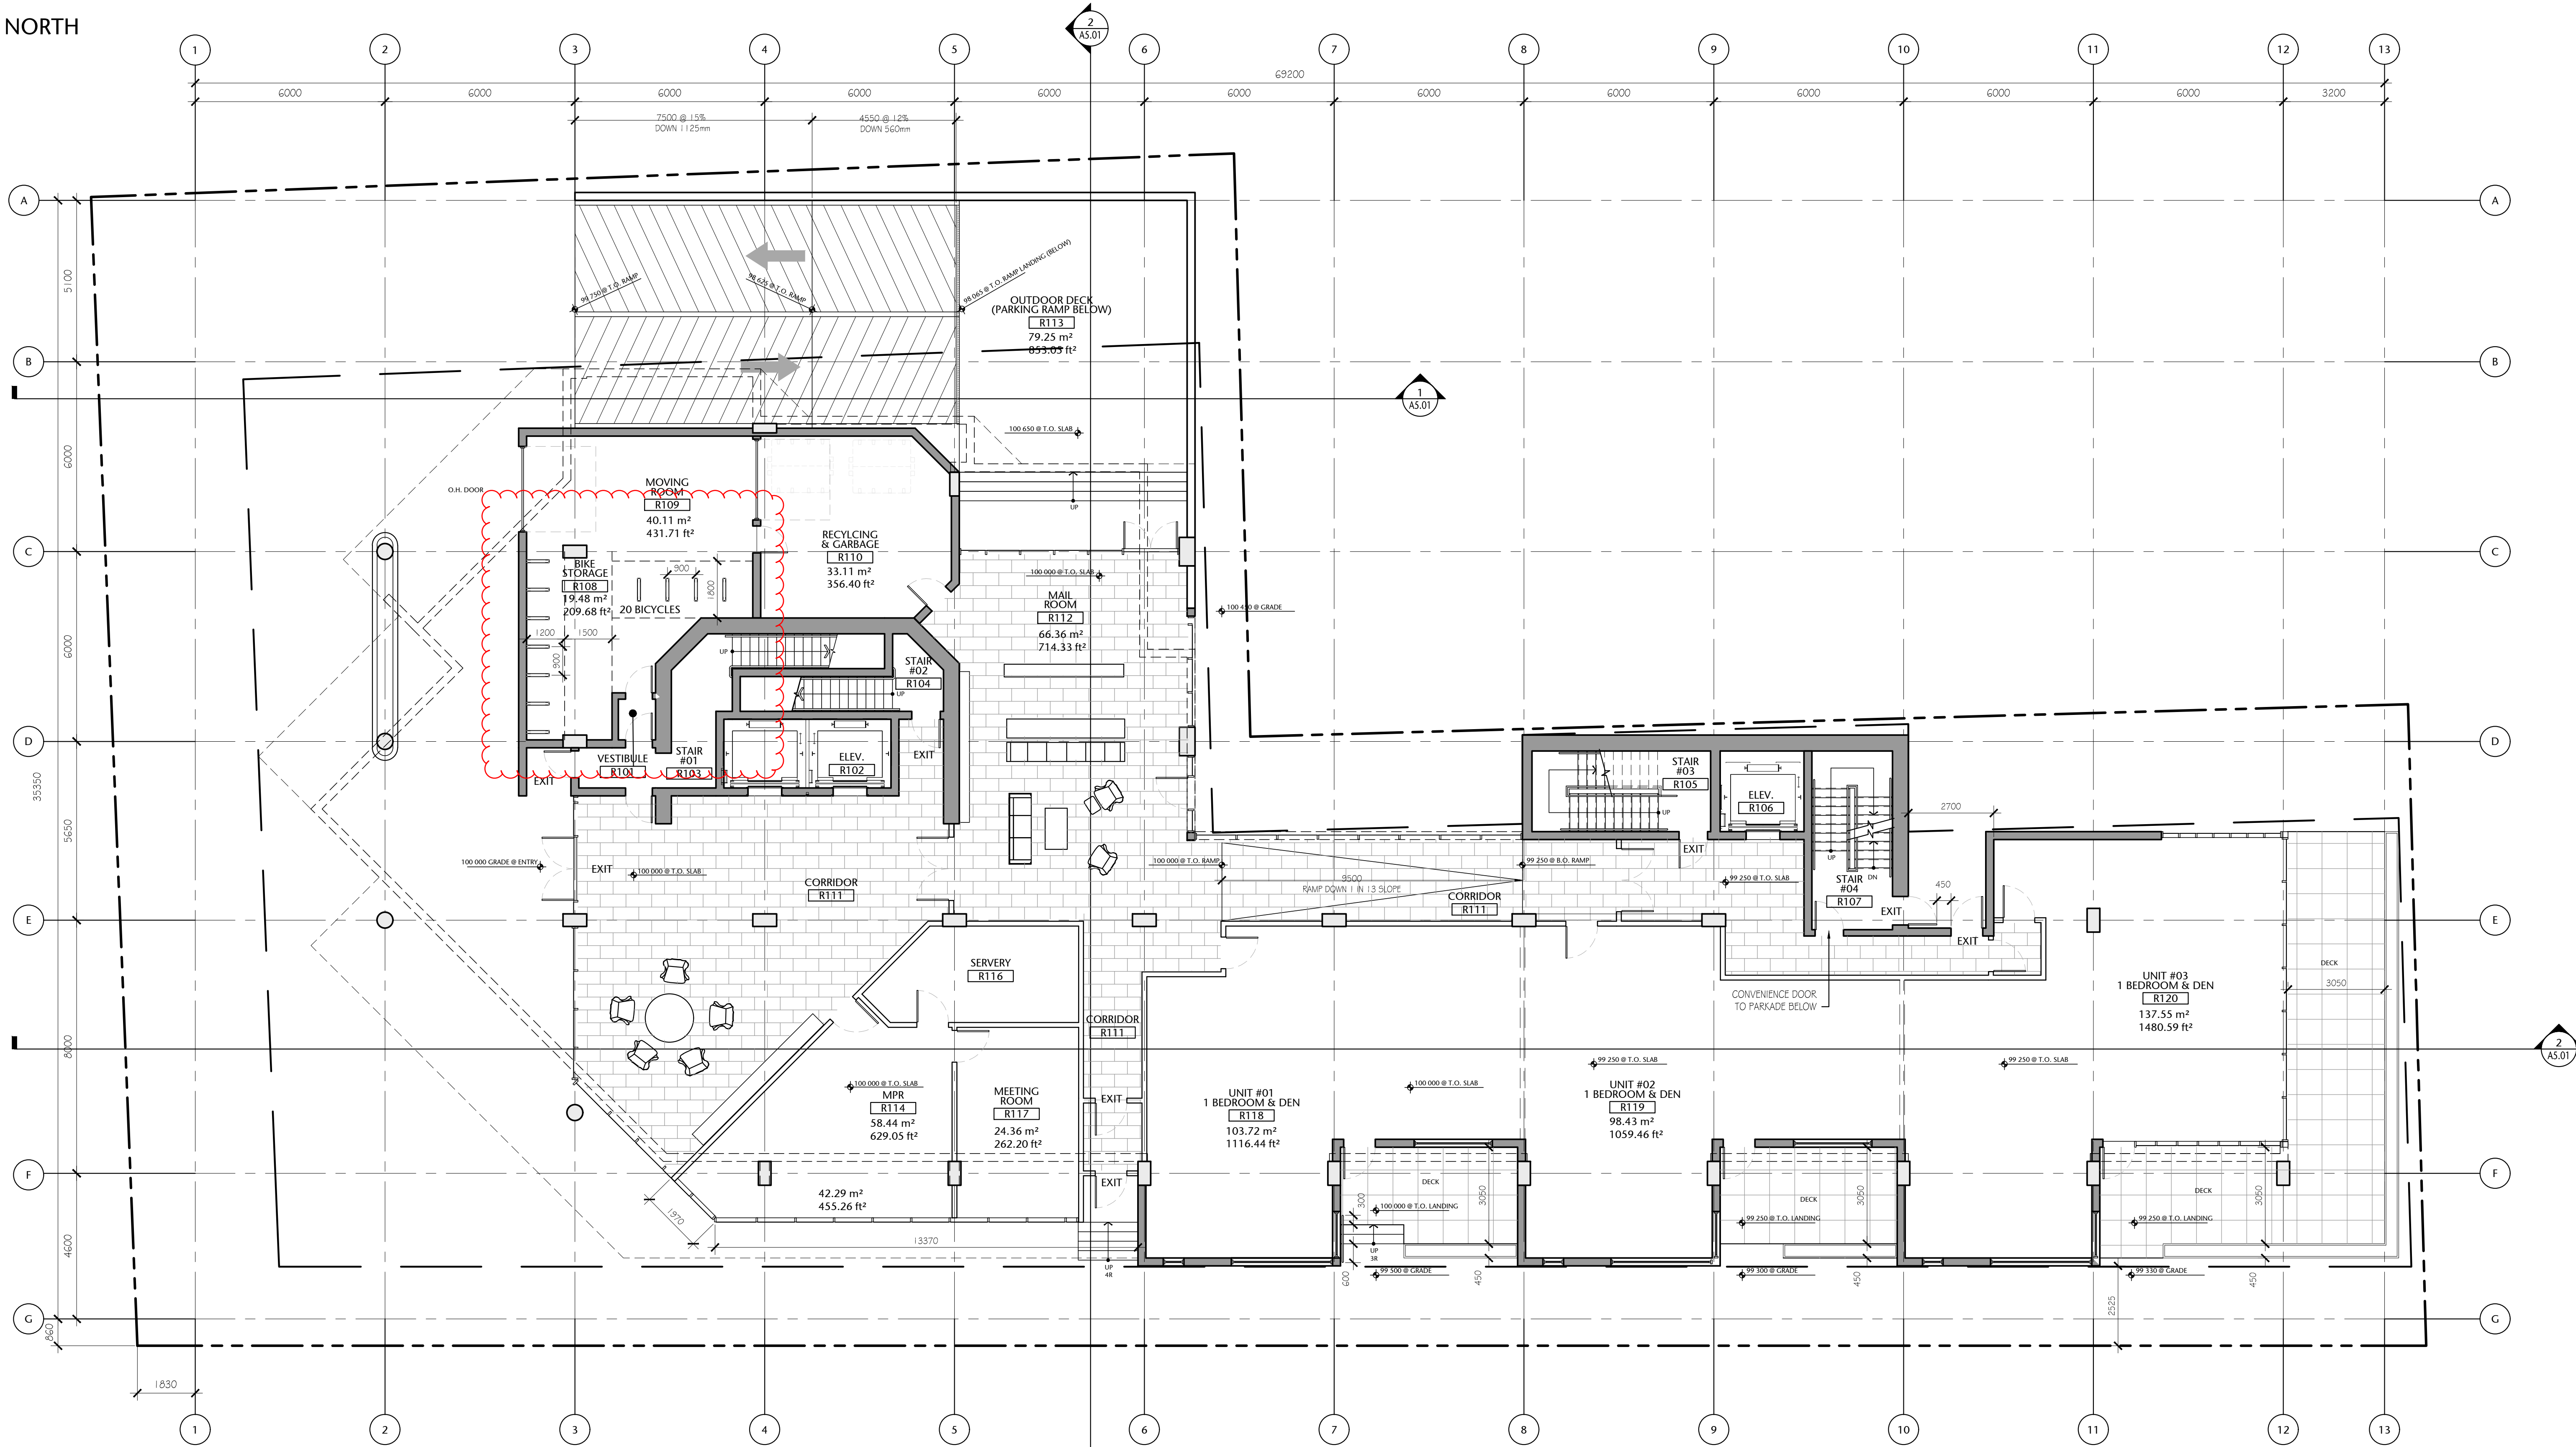


Main Floor Gross Area:
870.14 sq. mts. (9366.10 sq. ft.)

(Possible Unit Mix Illustrated)

Overall Gross Floor Areas:

Gross Floor Area above Grade (excluding balconies)		
	SQ. MTS.	SQ. FT.
1. Main Floor :	870.14	9,366
2. Second Floor:	950.23	10,228
3. Third Floor:	937.43	10,090
4. Fourth Floor:	857.23	9,227
5. Fifth Floor:	785.82	8,459
6. Sixth Floor:	651.25	7,010
7. Seventh Floor:	577.83	6,220
8. Eighth Floor:	424.51	4,569
9. Mech Penthouse	98.78	1,063
TOTAL AREA	6153.22	66,232

 1 MAIN FLOOR PLAN
A2.02 1:100



257 BELLEVILLE
STREET

VICTORIA, BRITISH COLUMBIA

no.	issued for	date
1	DEVELOPMENT PERMIT	OCT 23/2012
2	DEVELOPMENT PERMIT	MAR 16/2020
3	REISSUED DEVELOPMENT PERMIT	DEC 03/2020



alan **lowe** architect inc.





mtaink.com Urban Design Architecture Interior Design


drawing title
MAIN FLOOR PLAN

A2.02

drawn POR	scale AS SHOWN
checked DL	project no. 20.118

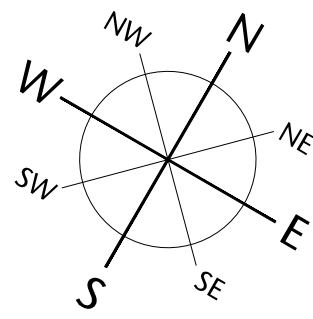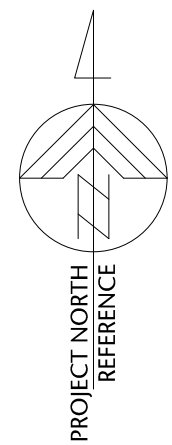

COMPASS NORTH

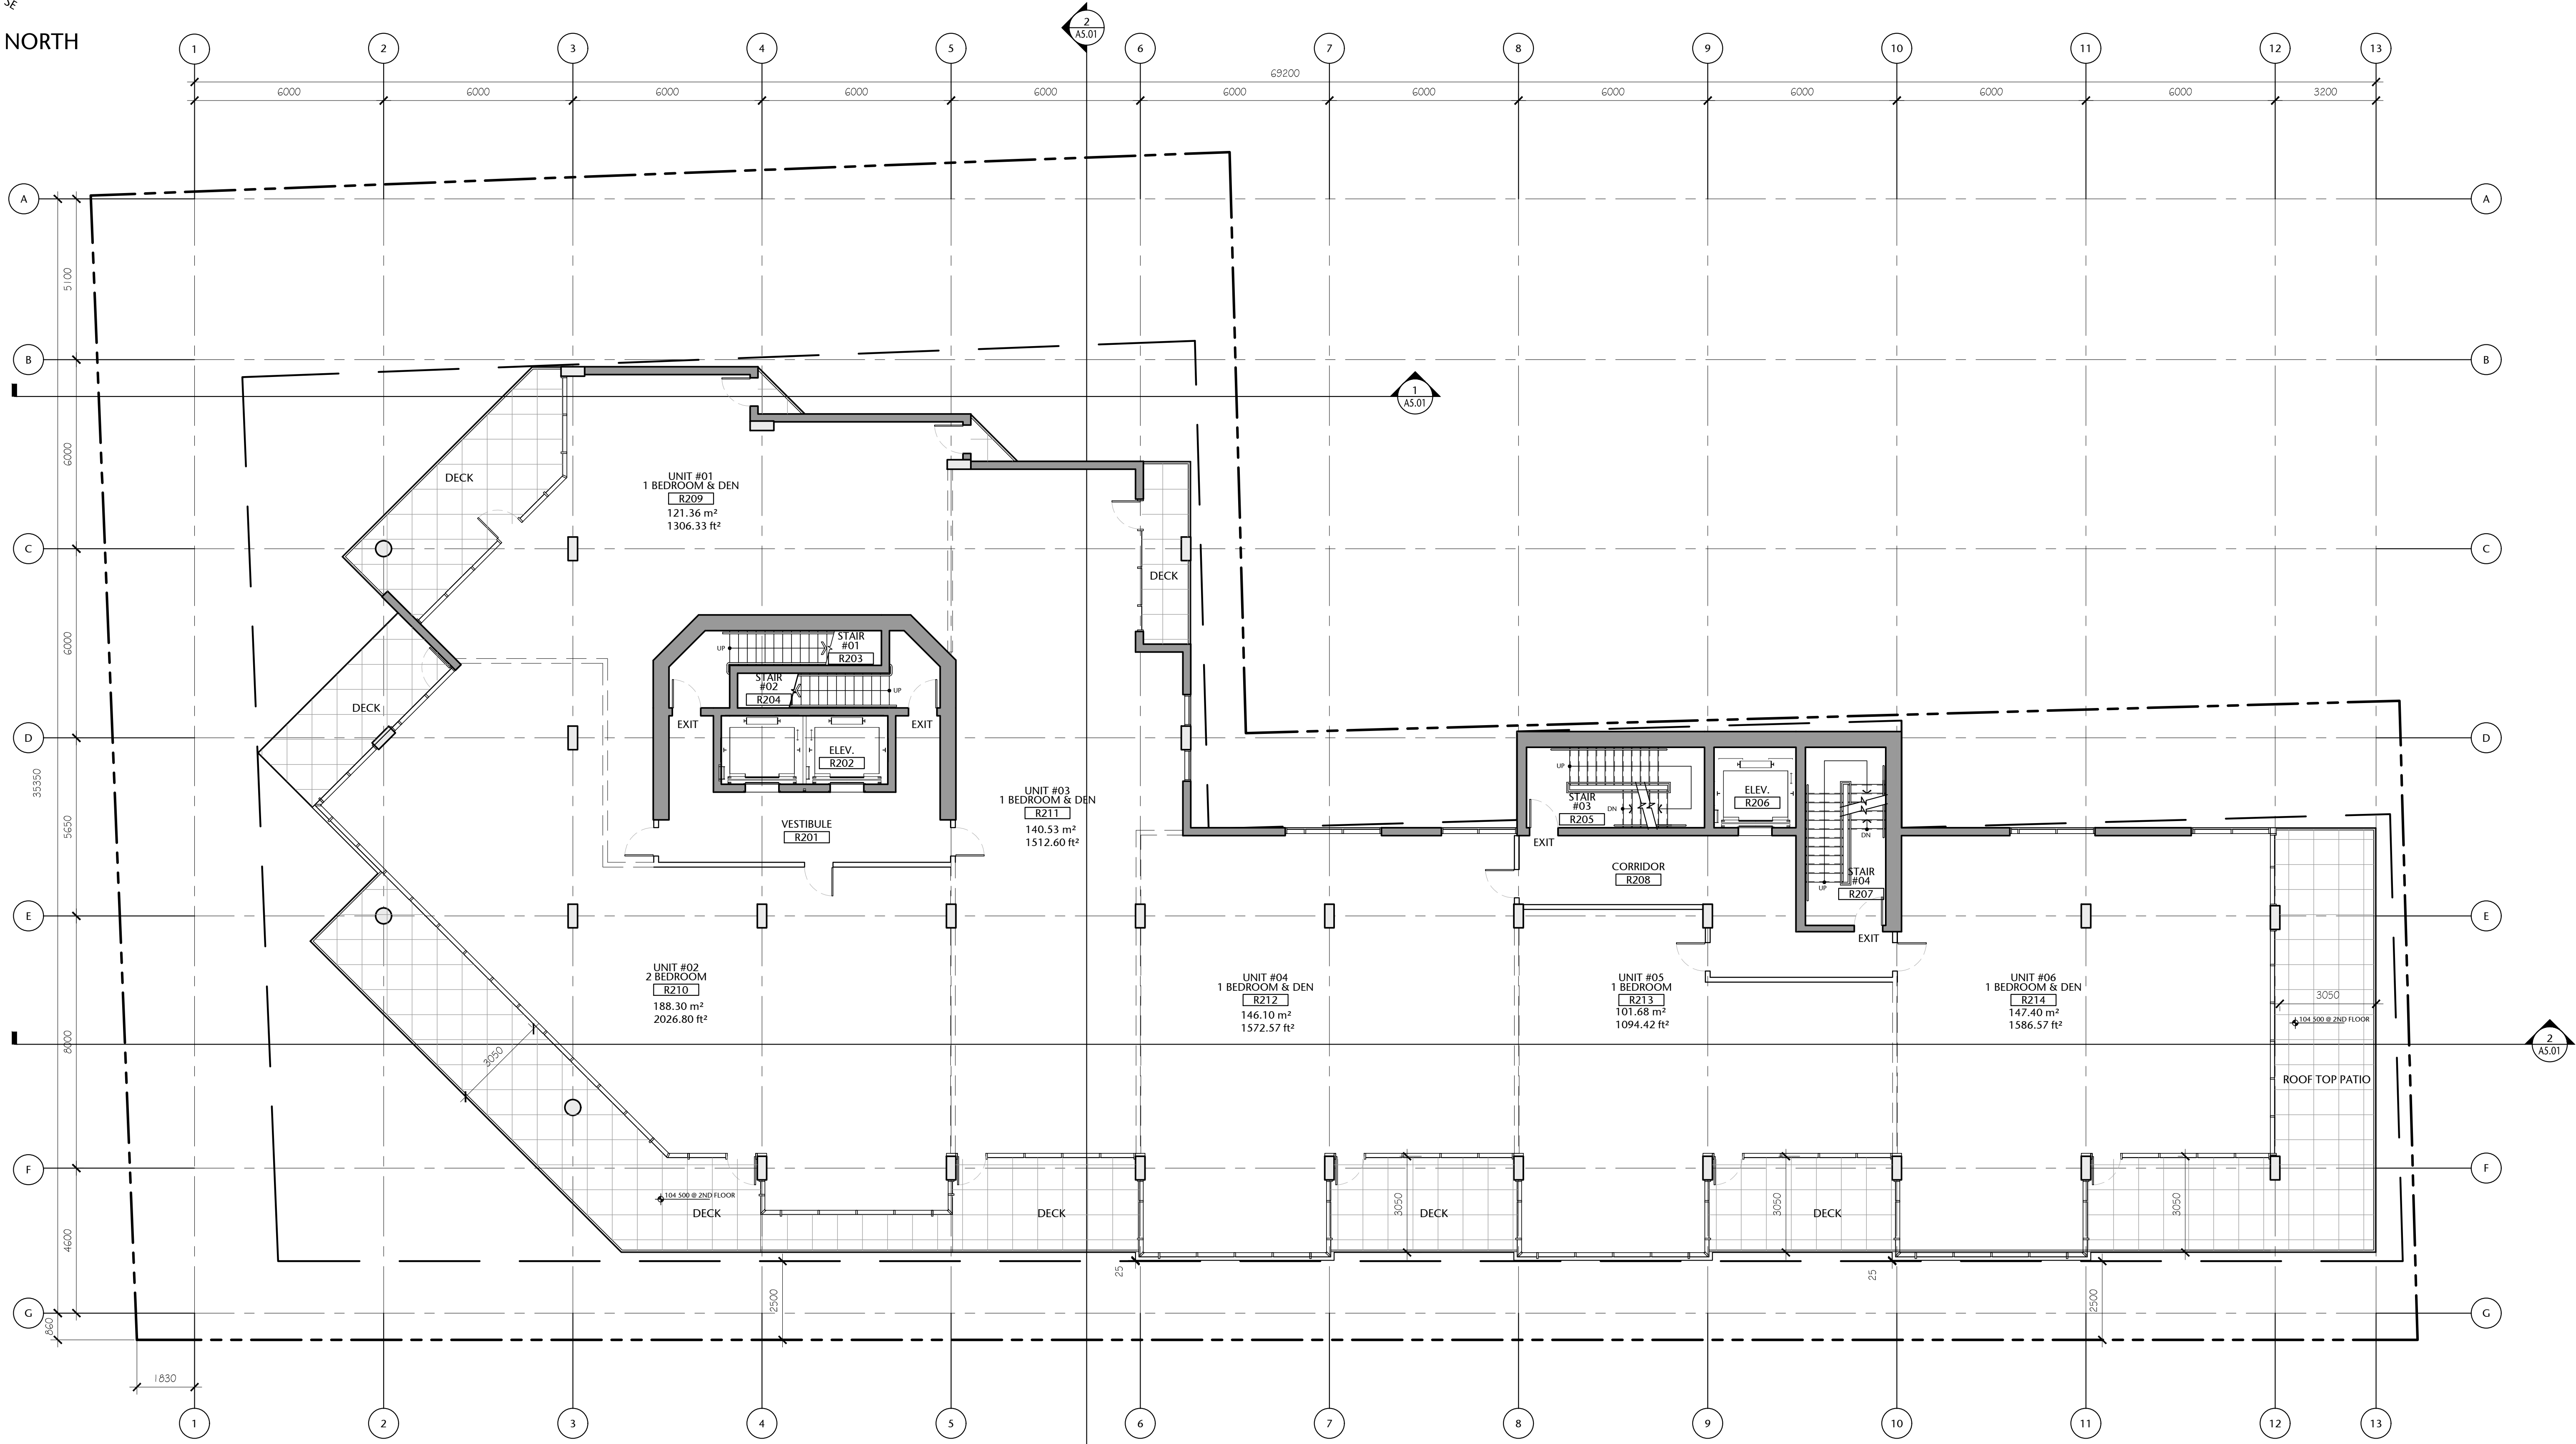

Second Floor Gross Area:
950.23 sq. mts. (10 228 sq. ft.)

(Possible Unit Mix Illustrated)

Overall Gross Floor Areas:

Gross Floor Area above Grade (excluding balconies)		
	SQ. MTS.	SQ. FT.
1. Main Floor :	870.14	9,366
2. Second Floor:	950.23	10,228
3. Third Floor:	937.43	10,090
4. Fourth Floor:	857.23	9,227
5. Fifth Floor:	785.82	8,459
6. Sixth Floor:	651.25	7,010
7. Seventh Floor:	577.83	6,220
8. Eighth Floor:	424.51	4,569
TOTAL AREA	6054.44	65,170

1 SECOND FLOOR PLAN
A2.03 1:100



257 BELLEVILLE
STREET

VICTORIA, BRITISH COLUMBIA

no.	issued for	date
1	DEVELOPMENT PERMIT	OCT 23/2012
2	DEVELOPMENT PERMIT	MAR 16/2020
3	REISSUED DEVELOPMENT PERMIT	DEC 03/2020



alan lowe architect inc.





mtaink.com Urban Design Architecture Interior Design


SECOND FLOOR PLAN

A2.03

drawn	scale
POR	AS SHOWN
checked	project no.
DL	20.118

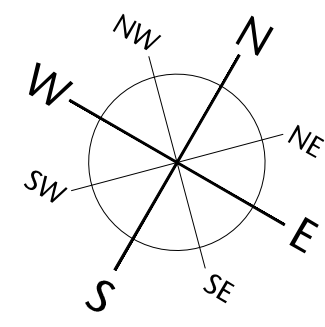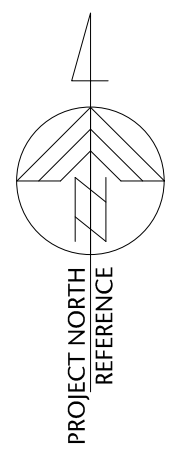

COMPASS NORTH

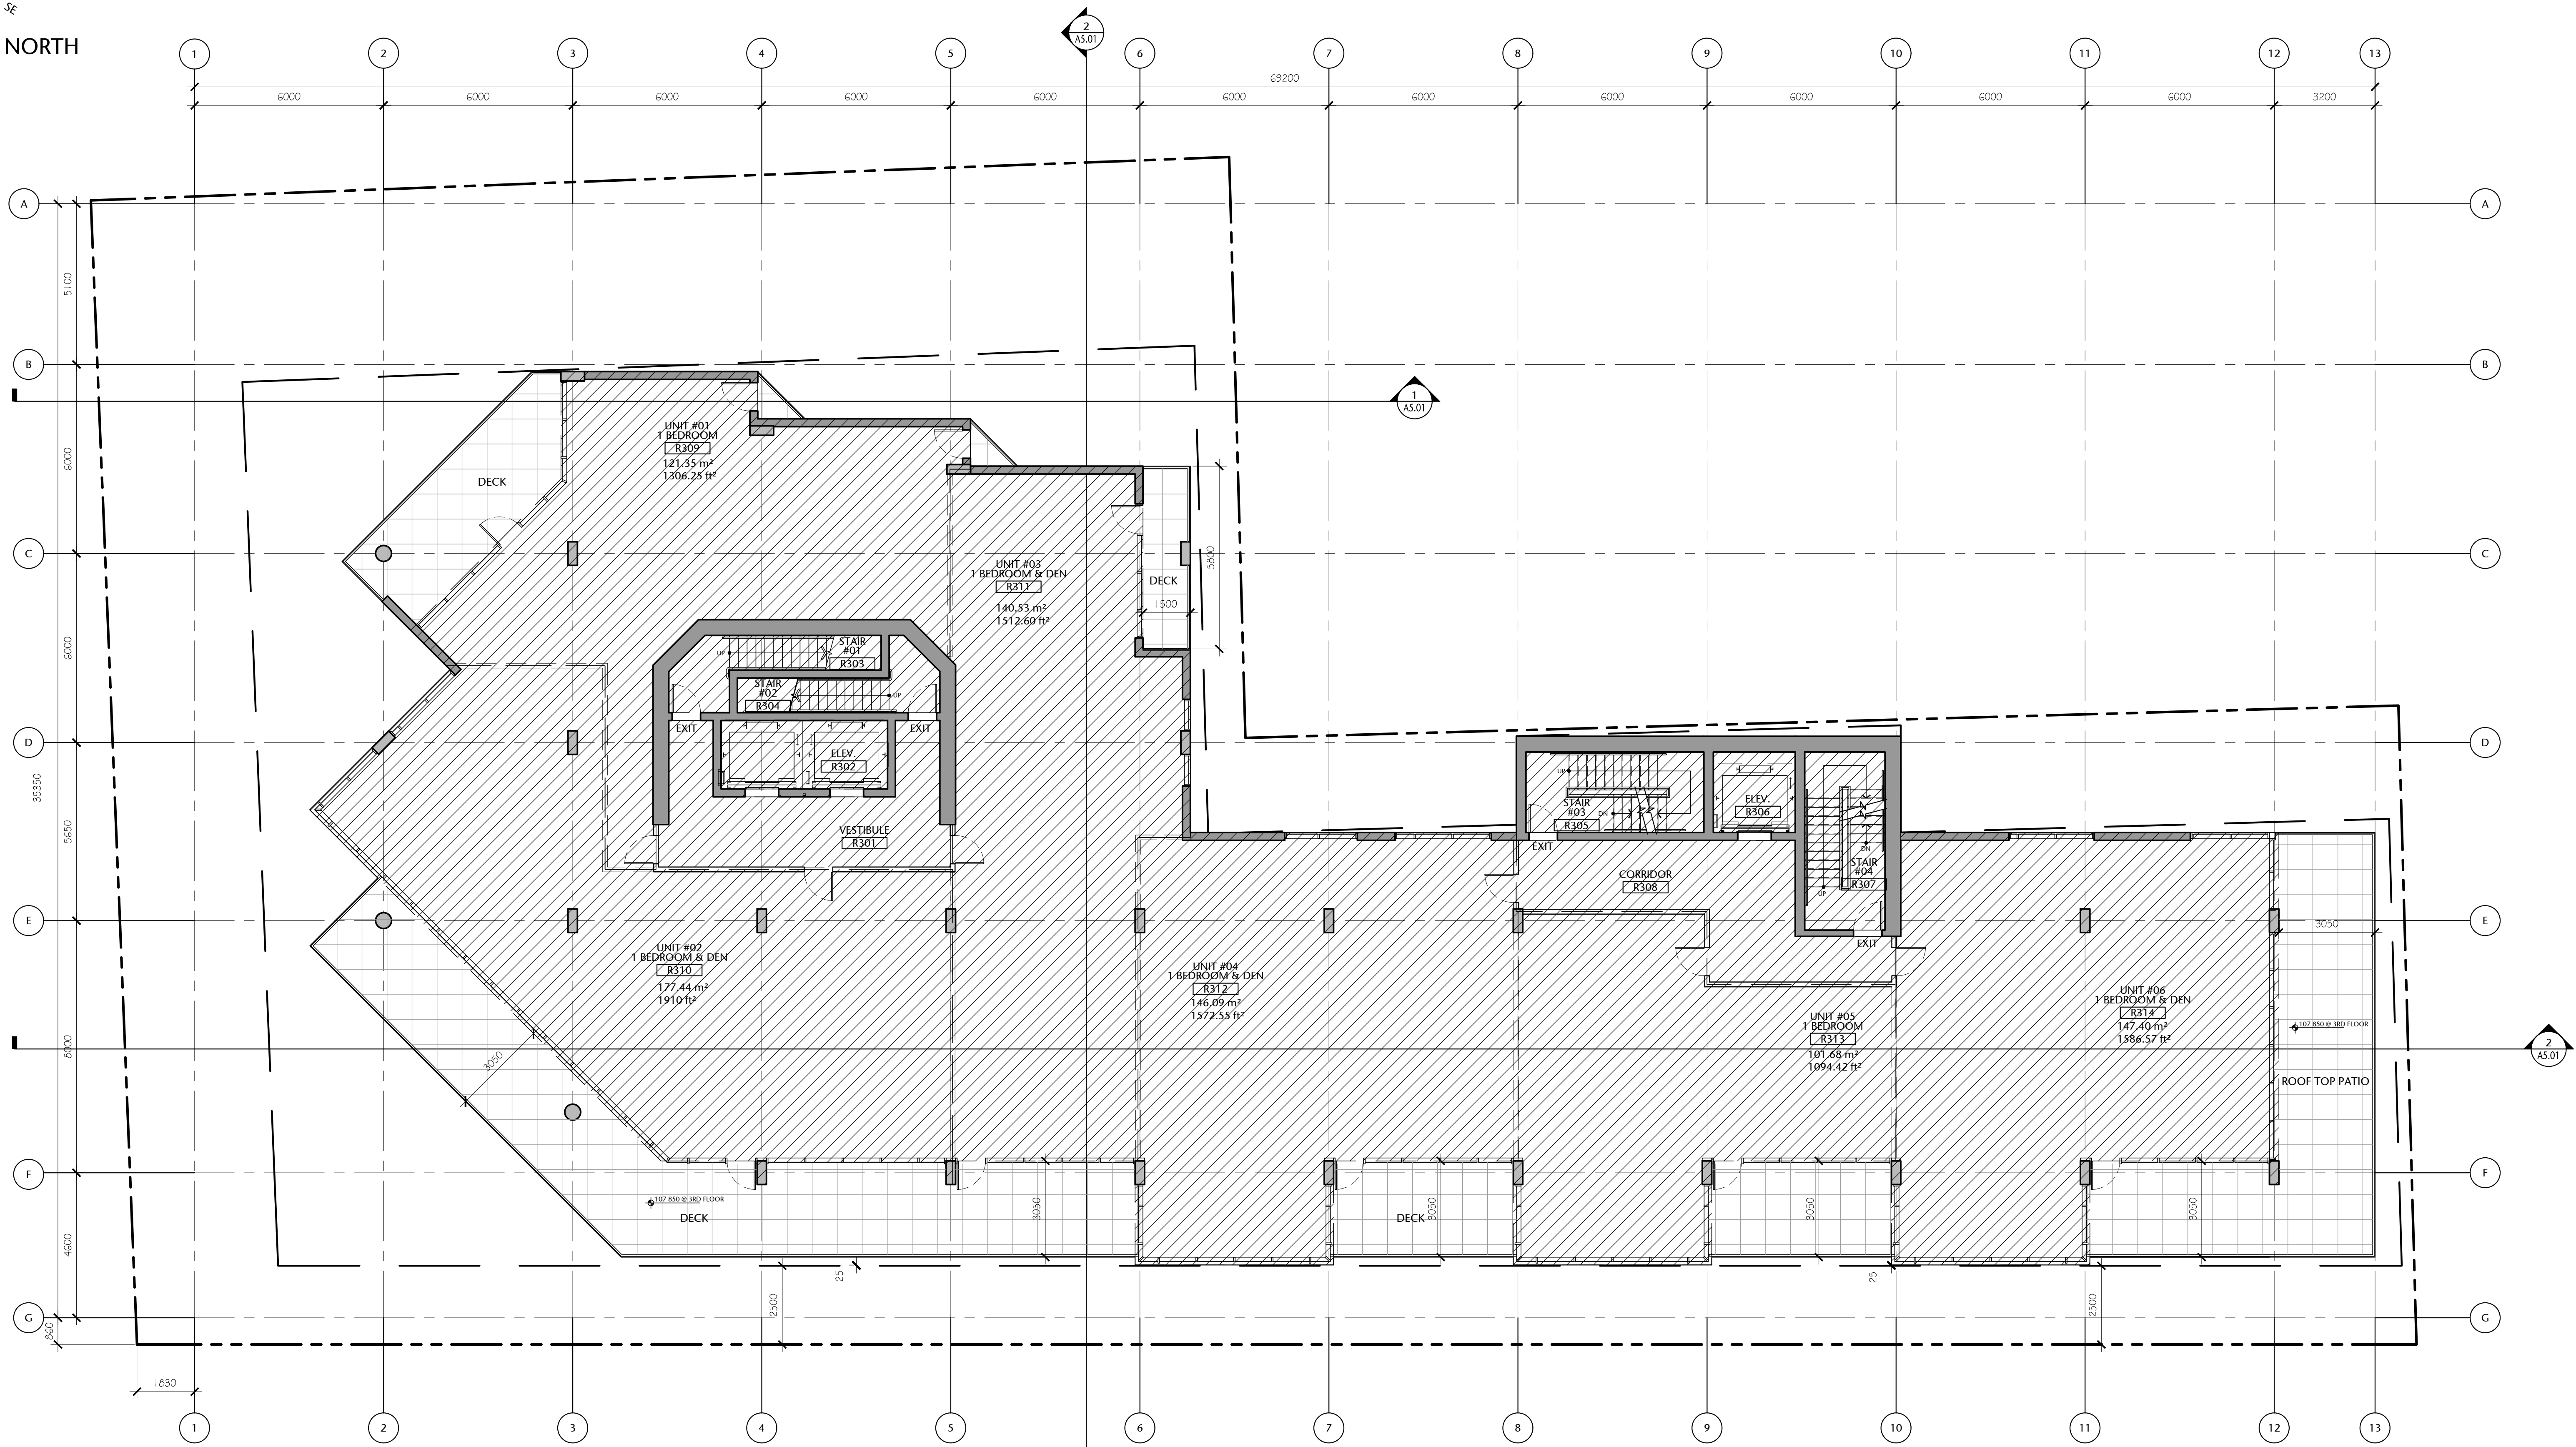

1 THIRD FLOOR PLAN
A2.04 1:100



Third Floor Gross Area:
937.43 sq. mts. (10 090.41 sq. ft.)

(Possible Unit Mix Illustrated)

Overall Gross Floor Areas:

Gross Floor Area above Grade (excluding balconies)		
	SQ. MTS.	SQ. FT.
1. Main Floor :	870.14	9,366
2. Second Floor:	950.23	10,228
3. Third Floor:	937.43	10,090
4. Fourth Floor:	857.23	9,227
5. Fifth Floor:	785.82	8,459
6. Sixth Floor:	651.25	7,010
7. Seventh Floor:	577.83	6,220
8. Eighth Floor:	424.51	4,569
9. Mech Penthouse	98.78	1,063
TOTAL AREA	6153.22	66,232

Note: All travel distance's shown under
allowed 45m under the applicable BC
Building Code 2018 Division B - Part 3
'3.4.2.5 Location of Exits (c)'

257 BELLEVILLE
STREET

VICTORIA, BRITISH COLUMBIA

no.	issued for	date
1	DEVELOPMENT PERMIT	OCT 23/2012
2	DEVELOPMENT PERMIT	MAR 16/2020
3	REISSUED DEVELOPMENT PERMIT	DEC 03/2020





consultant

alan **lowe** architect inc.


MTA CALGARY | EDMONTON
310, 625 - 11 Ave SW Calgary AB T2R 0E1
T: 403.264.8700
F: 403.264.8029
mtalink.com Urban Design Architecture Interior Design

drawing title
THIRD FLOOR PLAN
sheet
A2.04
drawn POR
checked DL
scale AS SHOWN
project no. 20.118

P:\2020\20.118.257 Belleville DP Renewal\ID Integrated Design\ID20 AutoCAD\ID22 Current\Sheets\WD 30x42 Sheets\A2.00\20.118-09-151-A2.05 FOURTH FLOOR PLAN.dwg 20/01/2022 7:55 PM Iona Crunkiewicz

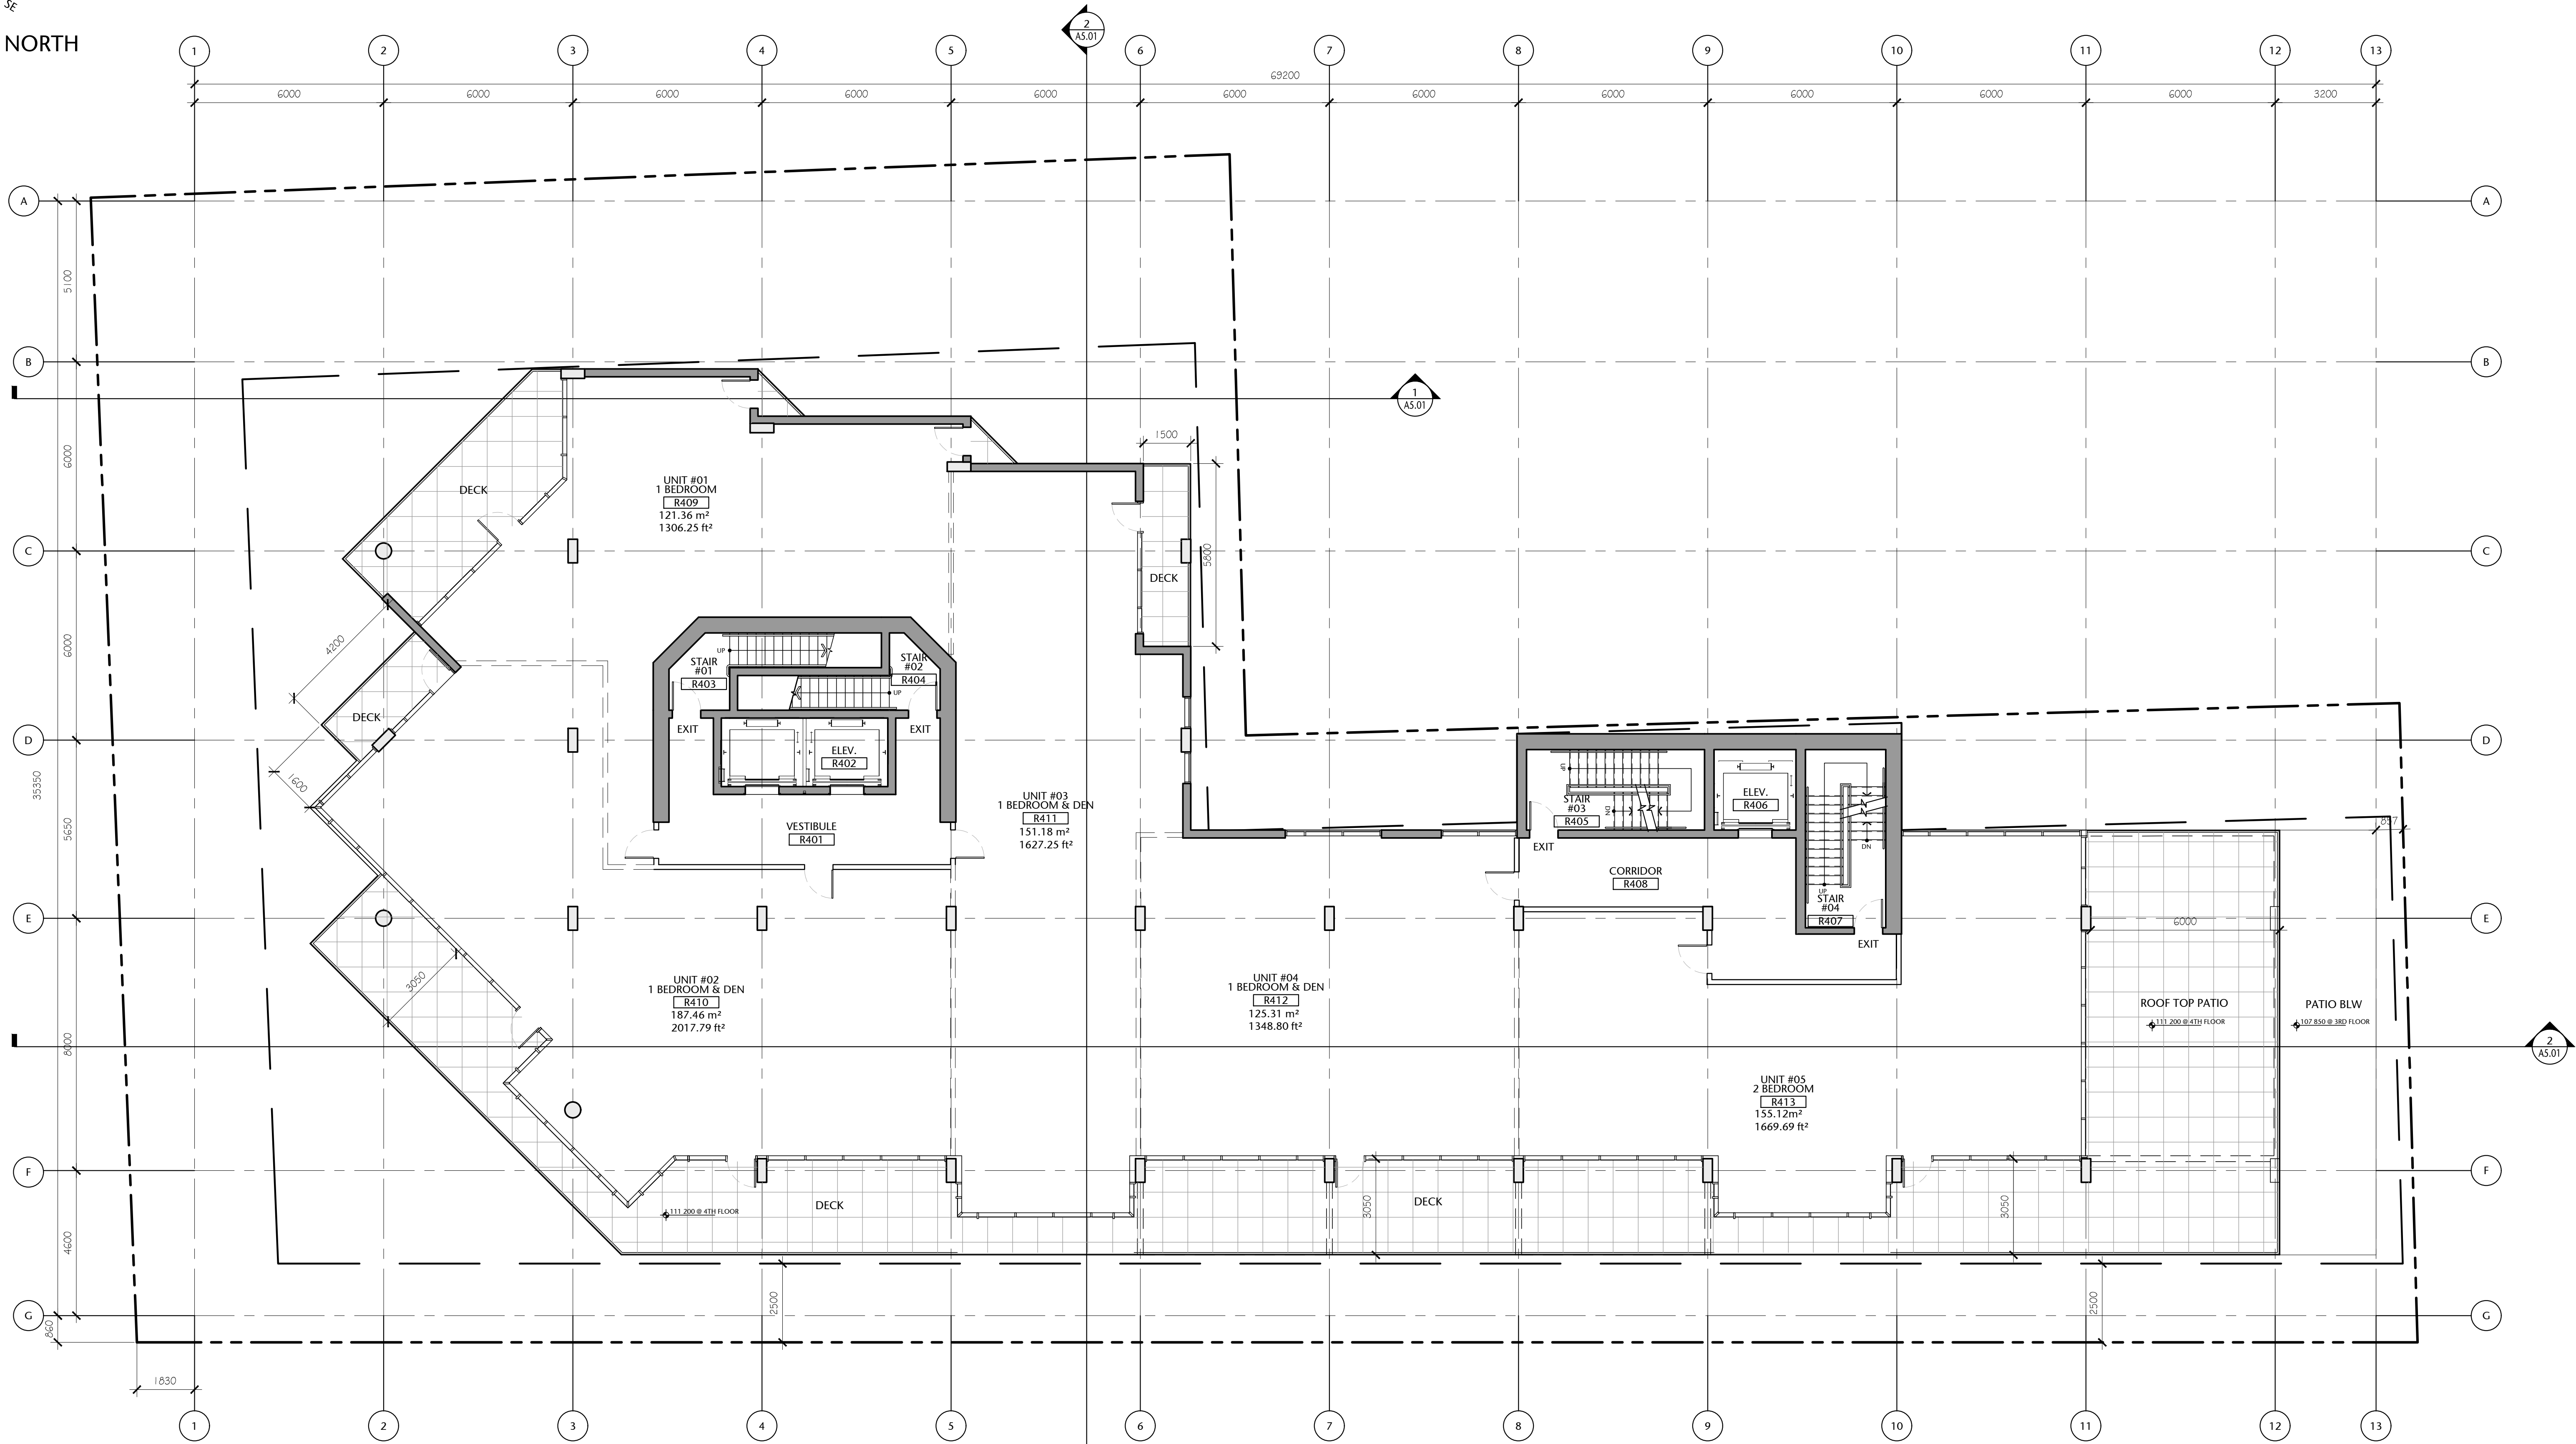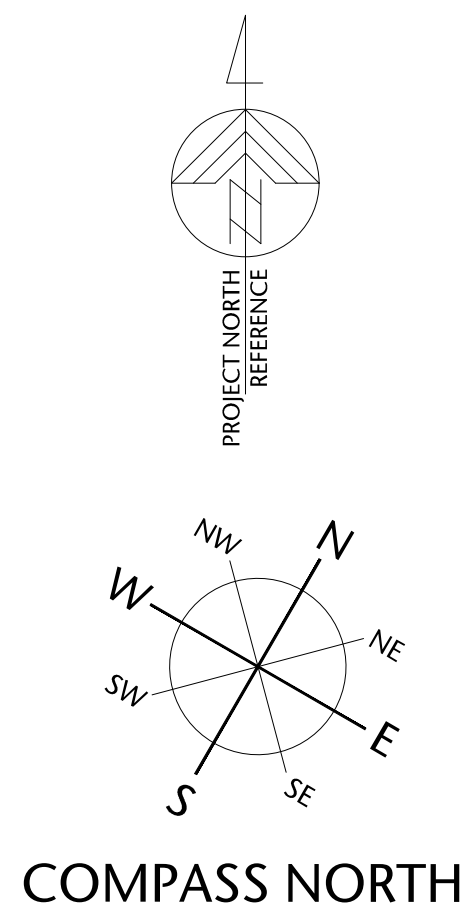

1 FOURTH FLOOR PLAN
A2.05
1:100

 

Fourth Floor Gross Area:
857.23 sq. mts. (9227.15 sq. ft.)

(Possible Unit Mix Illustrated)

Overall Gross Floor Areas:

Gross Floor Area above Grade (excluding balconies)		
	SQ. MTS.	SQ. FT.
1. Main Floor :	870.14	9,366
2. Second Floor:	950.23	10,228
3. Third Floor:	937.43	10,090
4. Fourth Floor:	857.23	9,227
5. Fifth Floor:	785.82	8,459
6. Sixth Floor:	651.25	7,010
7. Seventh Floor:	577.83	6,220
8. Eighth Floor:	424.51	4,569
9. Mech Penthouse	98.78	1,063
TOTAL AREA	6153.22	66,232

257 BELLEVILLE
STREET

VICTORIA, BRITISH COLUMBIA

no.	issued for	date
1	DEVELOPMENT PERMIT	OCT 23/2012
2	DEVELOPMENT PERMIT	MAR 16/2020
3	REISSUED DEVELOPMENT PERMIT	DEC 03/2020



alan **lowe** architect inc.





mtalink.com Urban Design Architecture Interior Design

FOURTH FLOOR PLAN


A2.05

drawn	scale
POR	AS SHOWN
checked	project no.
DL	20.118

P:\2020\20.118.257 Belleville DP Renewal\ID Integrated Design\ID20 AutoCAD\ID22 Current\Sheets\A2.00\20.118.09-151-A2.06 FIFTH FLOOR PLAN.dwg 2020/12/02 7:57 PM Iona Cunkiewicz

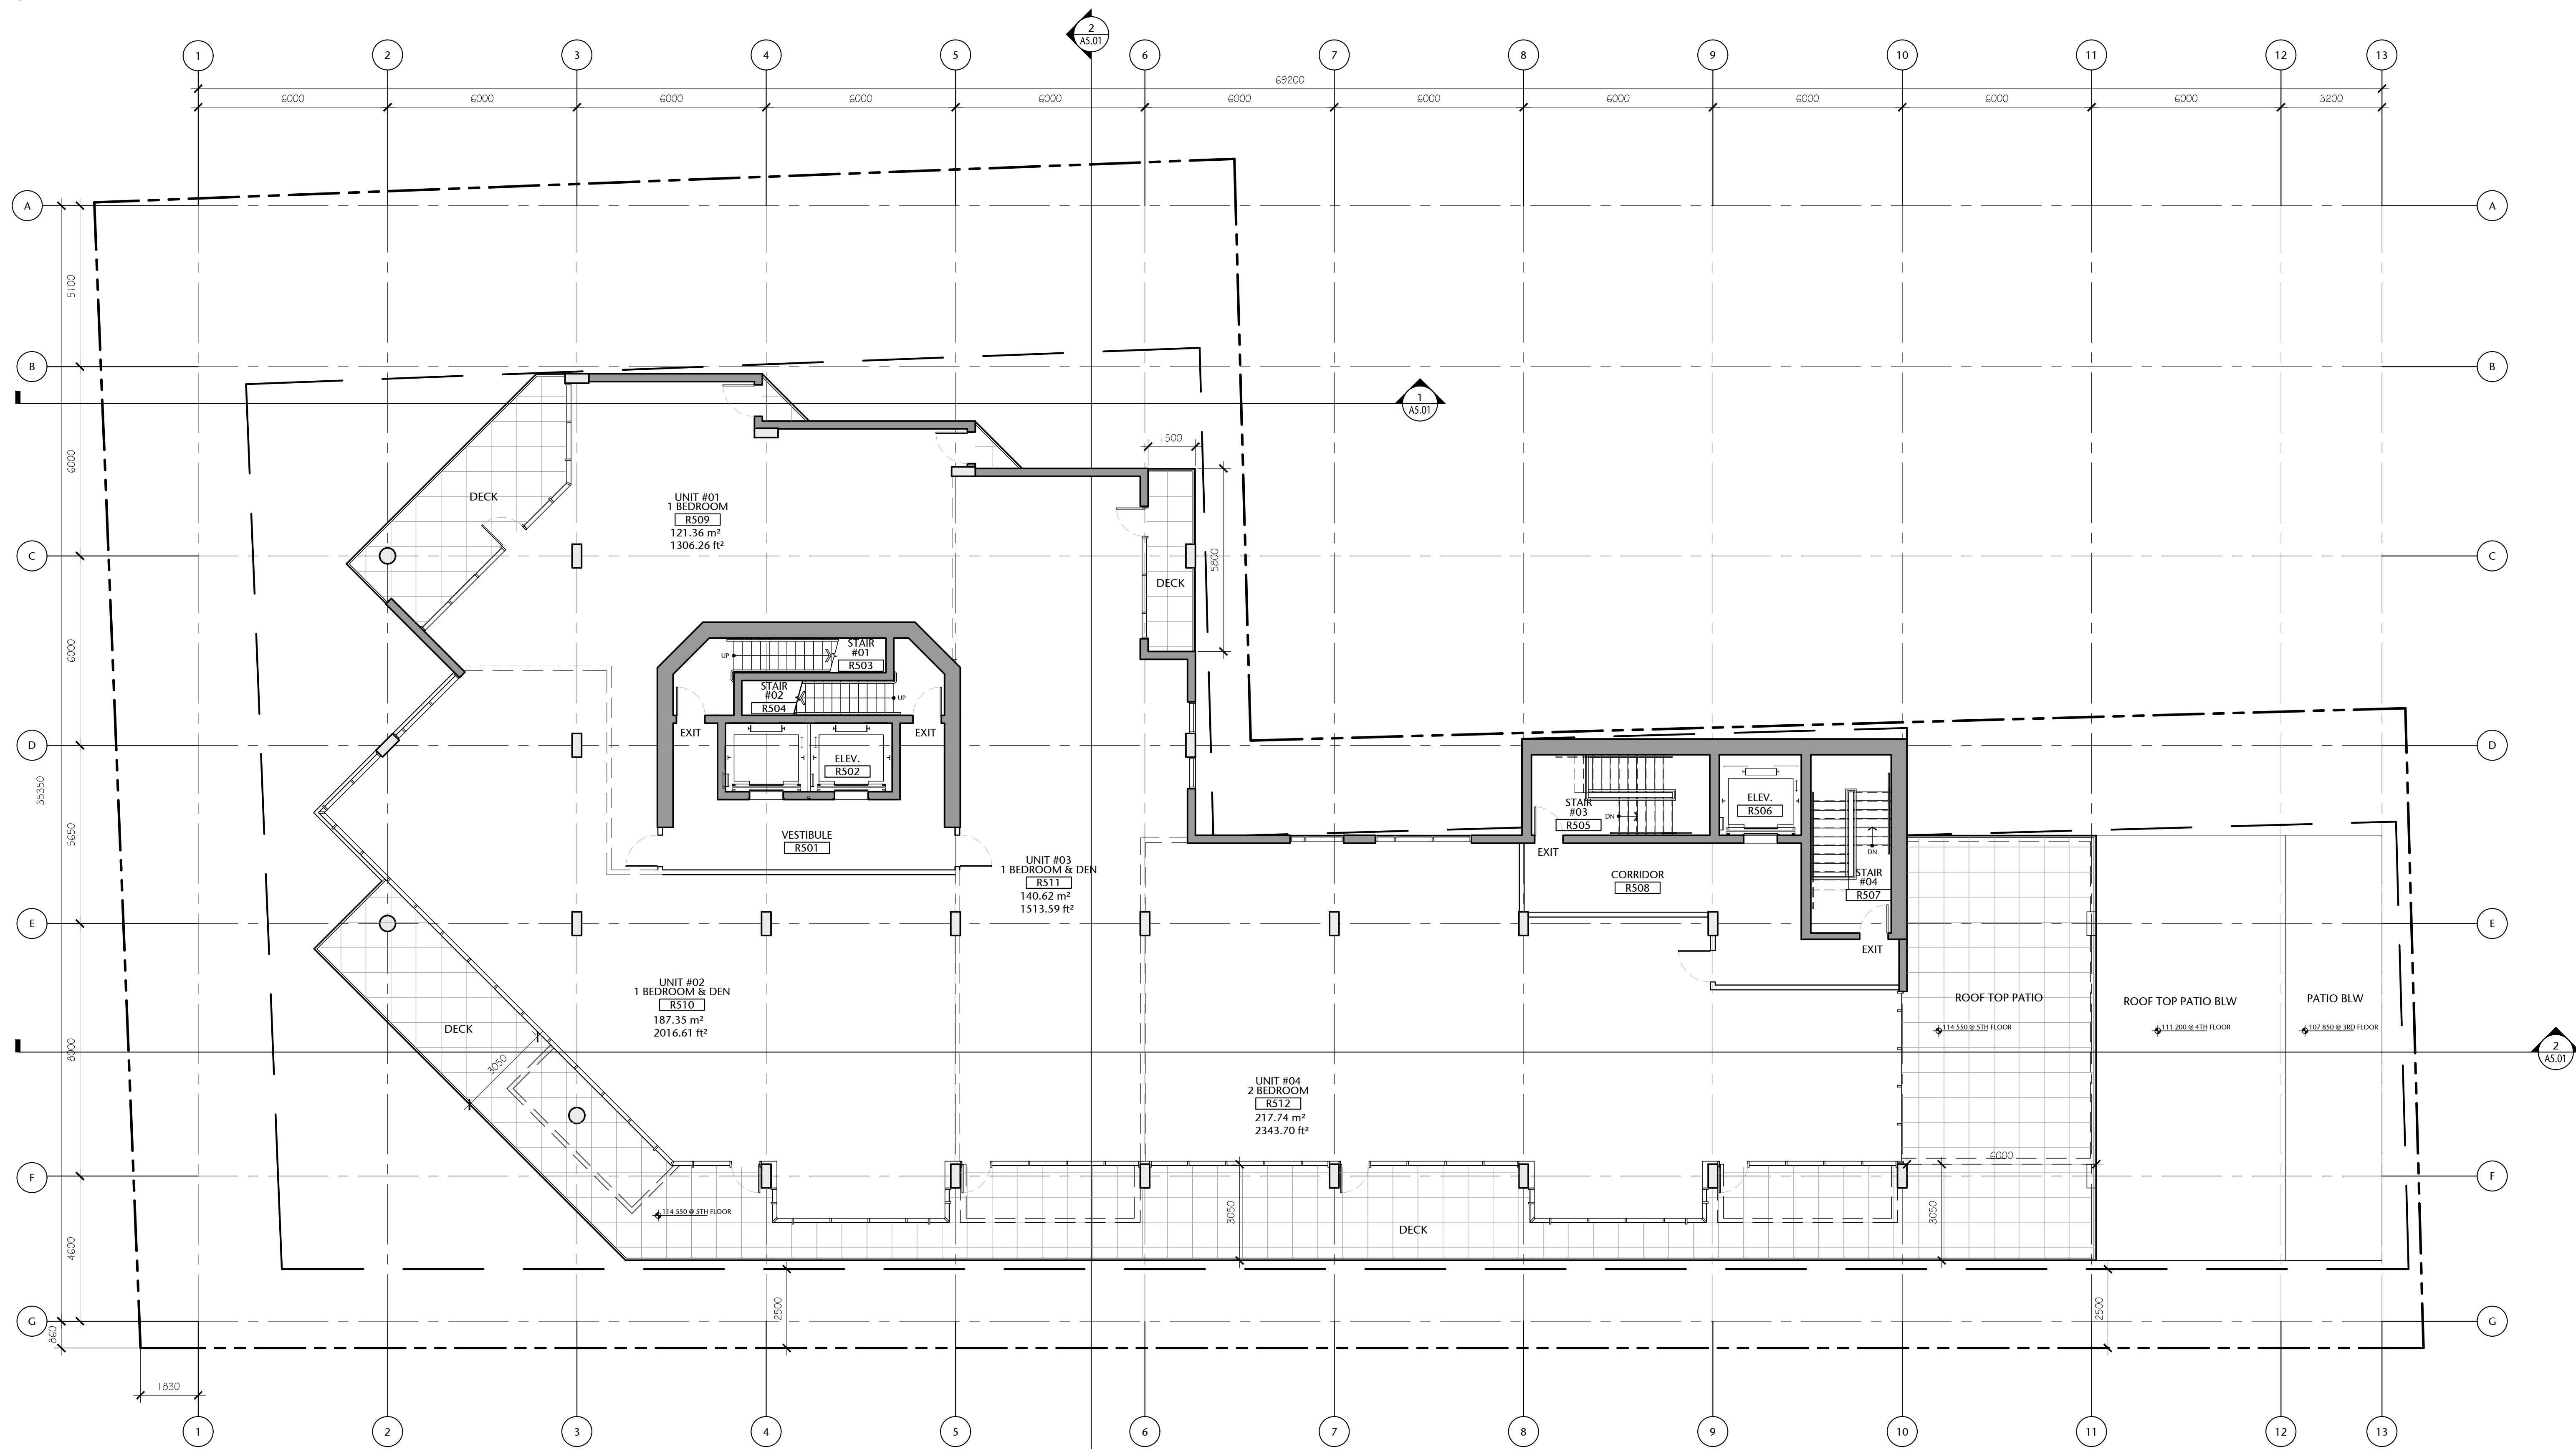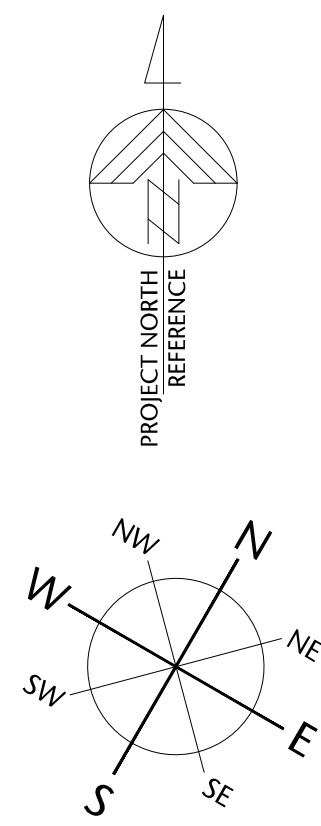

1 FIFTH FLOOR PLAN
A2.06 1:100

 

Fifth Floor Gross Area:
785.82 sq. mts. (8458.5 sq. ft.)

(Possible Unit Mix Illustrated)

Overall Gross Floor Areas:

Gross Floor Area above Grade (excluding balconies)		
	SQ. MTS.	SQ. FT.
1. Main Floor :	870.14	9,366
2. Second Floor:	950.23	10,228
3. Third Floor:	937.43	10,090
4. Fourth Floor:	857.23	9,227
5. Fifth Floor:	785.82	8,459
6. Sixth Floor:	651.25	7,010
7. Seventh Floor:	577.83	6,220
8. Eighth Floor:	424.51	4,569
9. Mech Penthouse	98.78	1,063
TOTAL AREA	6153.22	66,232

257 BELLEVILLE
STREET

VICTORIA, BRITISH COLUMBIA

no.	issued for	date
1	DEVELOPMENT PERMIT	OCT 23/2012
2	DEVELOPMENT PERMIT	MAR 16/2020
3	REISSUED DEVELOPMENT PERMIT	DEC 03/2020



alan **lowe** architect inc.



mtaink.com Urban Design Architecture Interior Design



drawing title
FIFTH FLOOR PLAN

A2.06


drawn	scale
POR	AS SHOWN
checked	project no.
DL	20.118

COPYRIGHTED. This design is the exclusive property of the Architect and shall not be reproduced without the Architects written permission. These drawings are to be read in conjunction with the specifications, structural, mechanical and electrical drawings. This drawing must not be scaled. All dimensions, data and levels shall be verified before construction, and all errors or omissions reported immediately to the Architect.

P:\2020\20.118.257 Belleville DP Renewal\ID Integrated Design\ID20 AutoCAD\ID22 Current\Sheets\WD 30x42 Sheets\A2.00\20.118-09-151-A2.07 SIXTH FLOOR PLAN.dwg 2020/12/02 7:59 PM Iona Cumberlidge

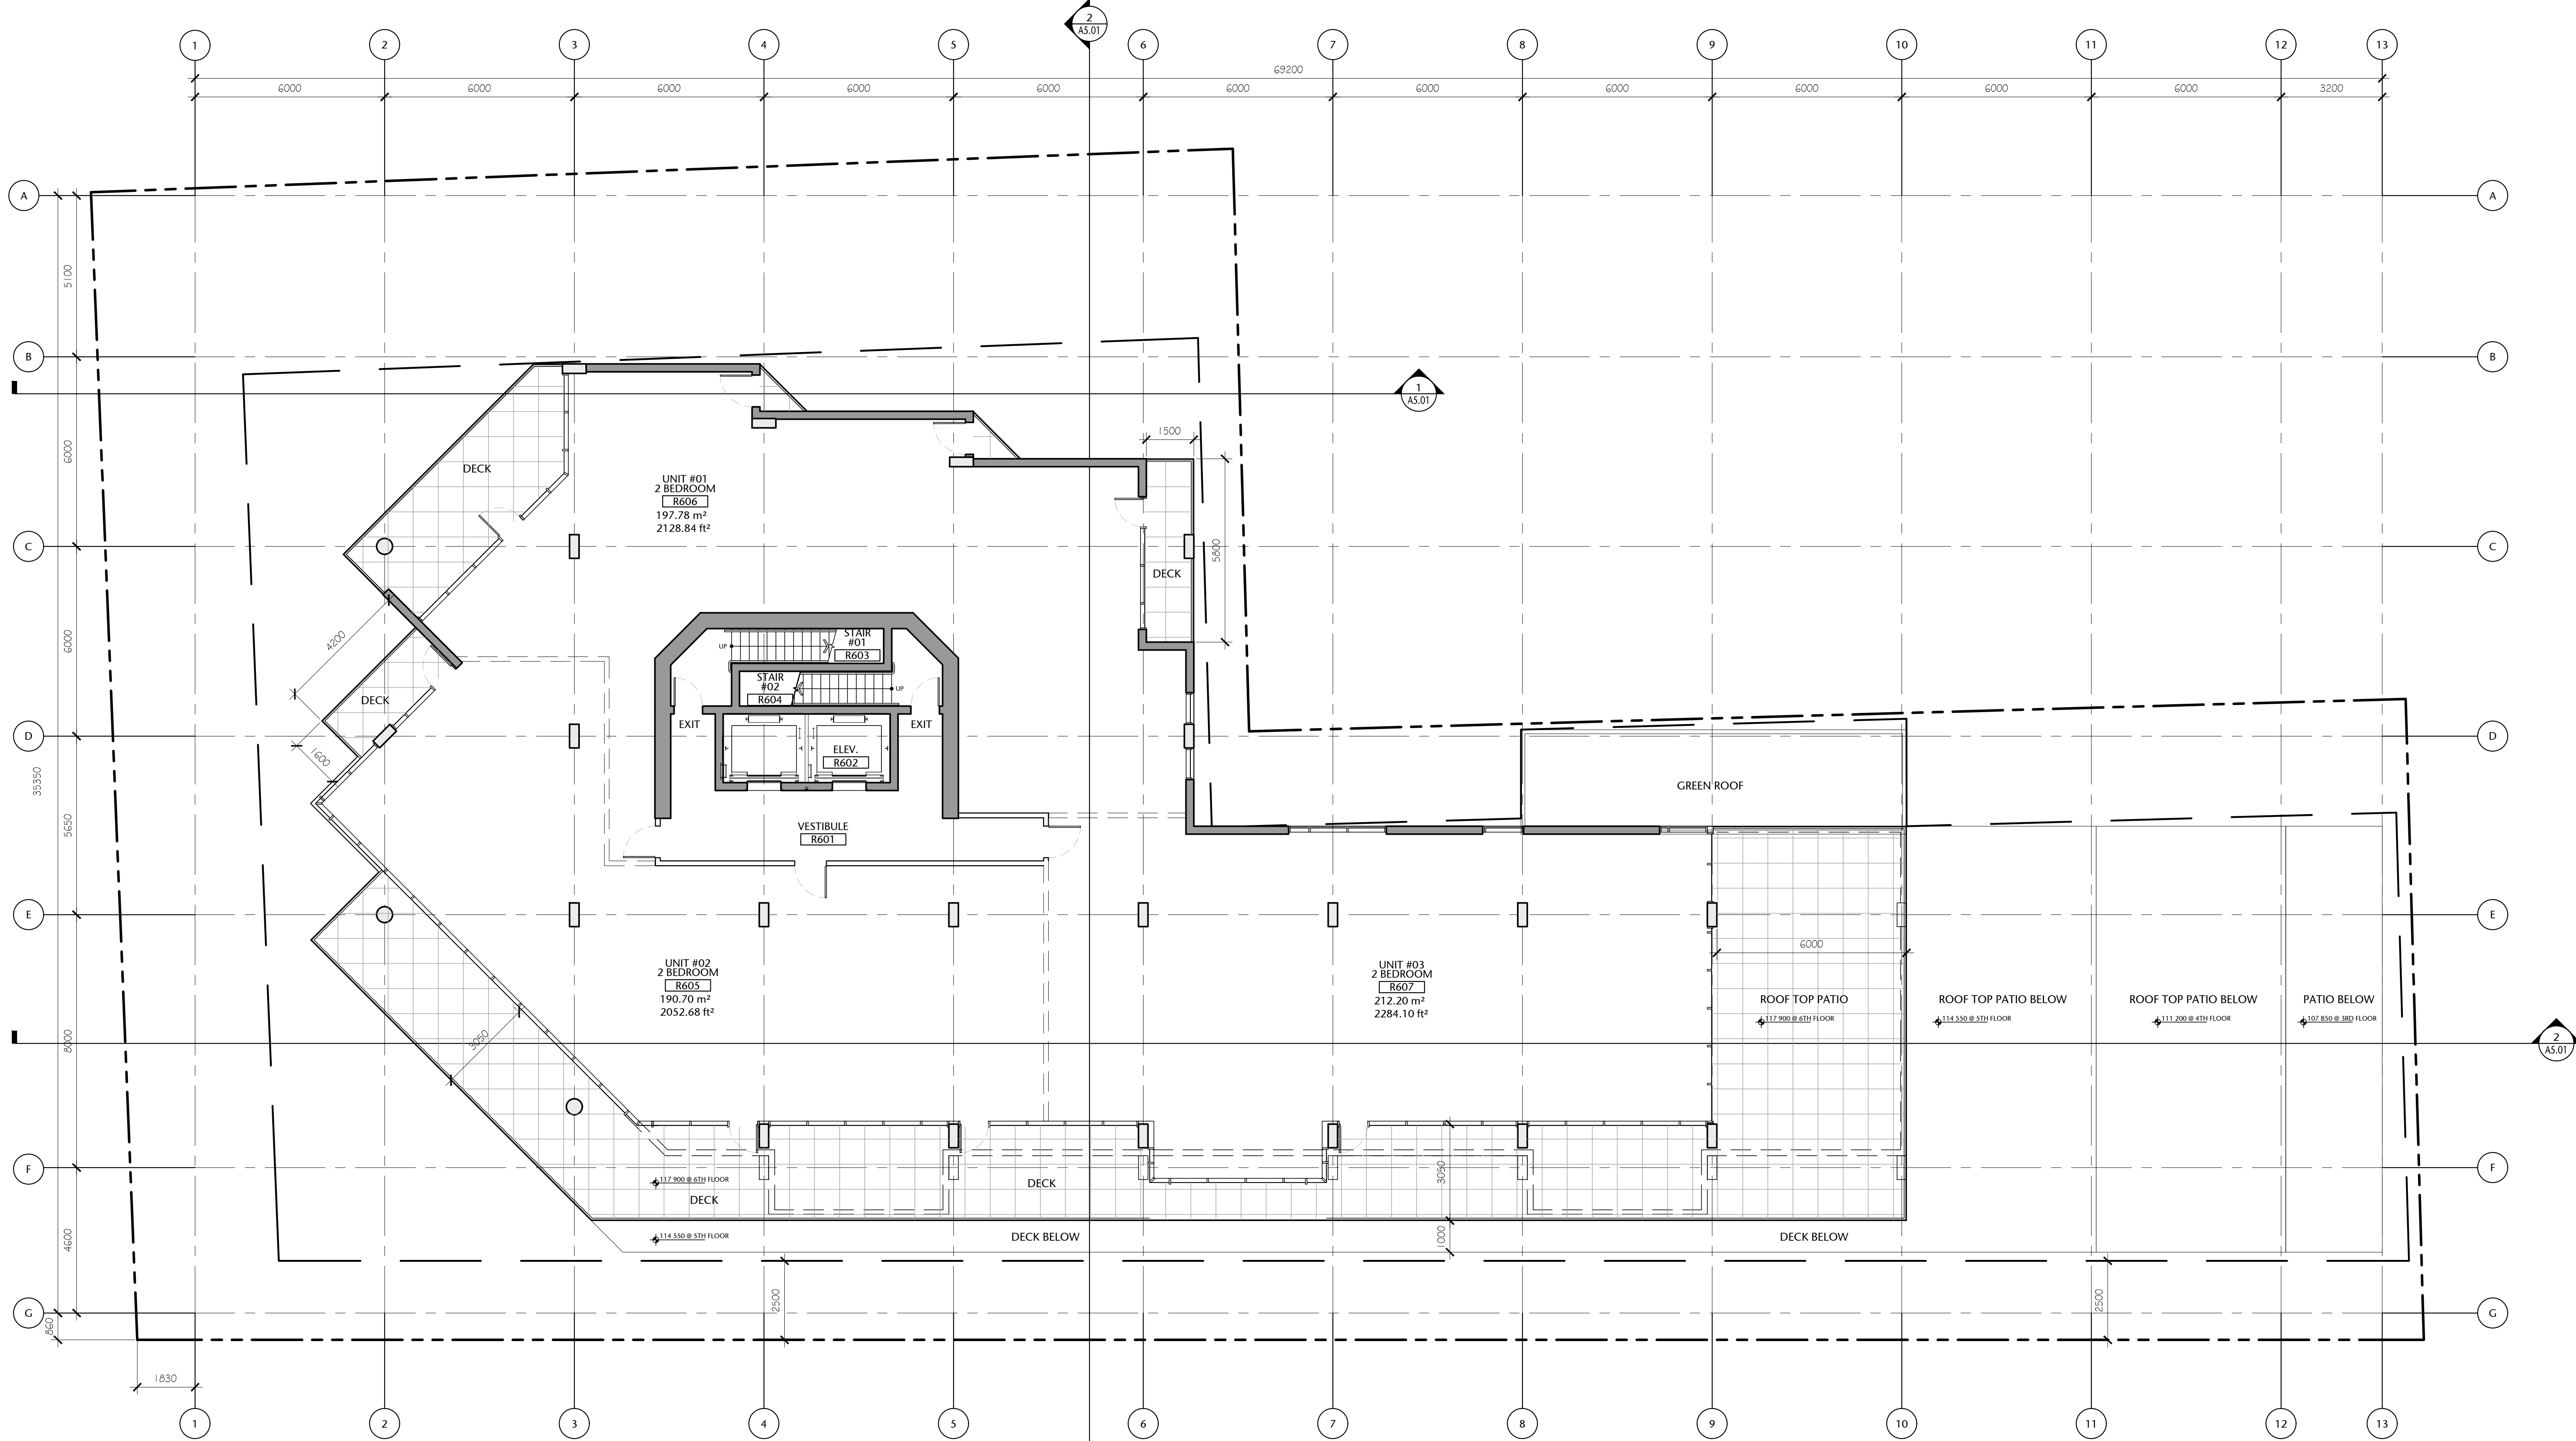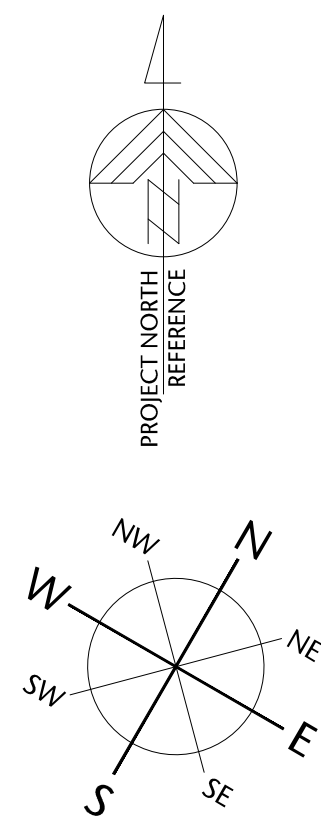

1 SIXTH FLOOR PLAN
A2.07 1:100

 

Sixth Floor Gross Area:
651.25 sq. mts. (7010 sq. ft.)

(Possible Unit Mix Illustrated)

Overall Gross Floor Areas:

Gross Floor Area above Grade (excluding balconies)		
	SQ. MTS.	SQ. FT.
1. Main Floor :	870.14	9,366
2. Second Floor:	950.23	10,228
3. Third Floor:	937.43	10,090
4. Fourth Floor:	857.23	9,227
5. Fifth Floor:	785.82	8,459
6. Sixth Floor:	651.25	7,010
7. Seventh Floor:	577.83	6,220
8. Eighth Floor:	424.51	4,569
9. Mech Penthouse	98.78	1,063
TOTAL AREA	6153.22	66,232

257 BELLEVILLE
STREET

VICTORIA, BRITISH COLUMBIA

no.	issued for	date
1	DEVELOPMENT PERMIT	OCT 23/2012
2	DEVELOPMENT PERMIT	MAR 16/2020
3	REISSUED DEVELOPMENT PERMIT	DEC 03/2020



alan **lowe** architect inc.



mtalink.com Urban Design Architecture Interior Design

drawing title

SIXTH FLOOR PLAN



A2.07

sheet


drawn	scale
POR	AS SHOWN
checked	project no.
DL	20.118

COPYRIGHTED. This design is the exclusive property of the Architect and shall not be reproduced without the Architects written permission. These drawings are to be read in conjunction with the specifications, structural, mechanical and electrical drawings. All dimensions, data and levels shall be verified before construction, and all errors or omissions reported immediately to the Architect.

P:\2020\20.118.257 Belleville DP Renewal\ID Integrated Design\ID20 AutoCAD\ID22 Current\Sheets\WD 30x42 Sheets\A2.00\20.118.09-151-A2.08 SEVENTH FLOOR PLAN.dwg, 2020/12/02, 8:00 PM, Iona Cunliewicz

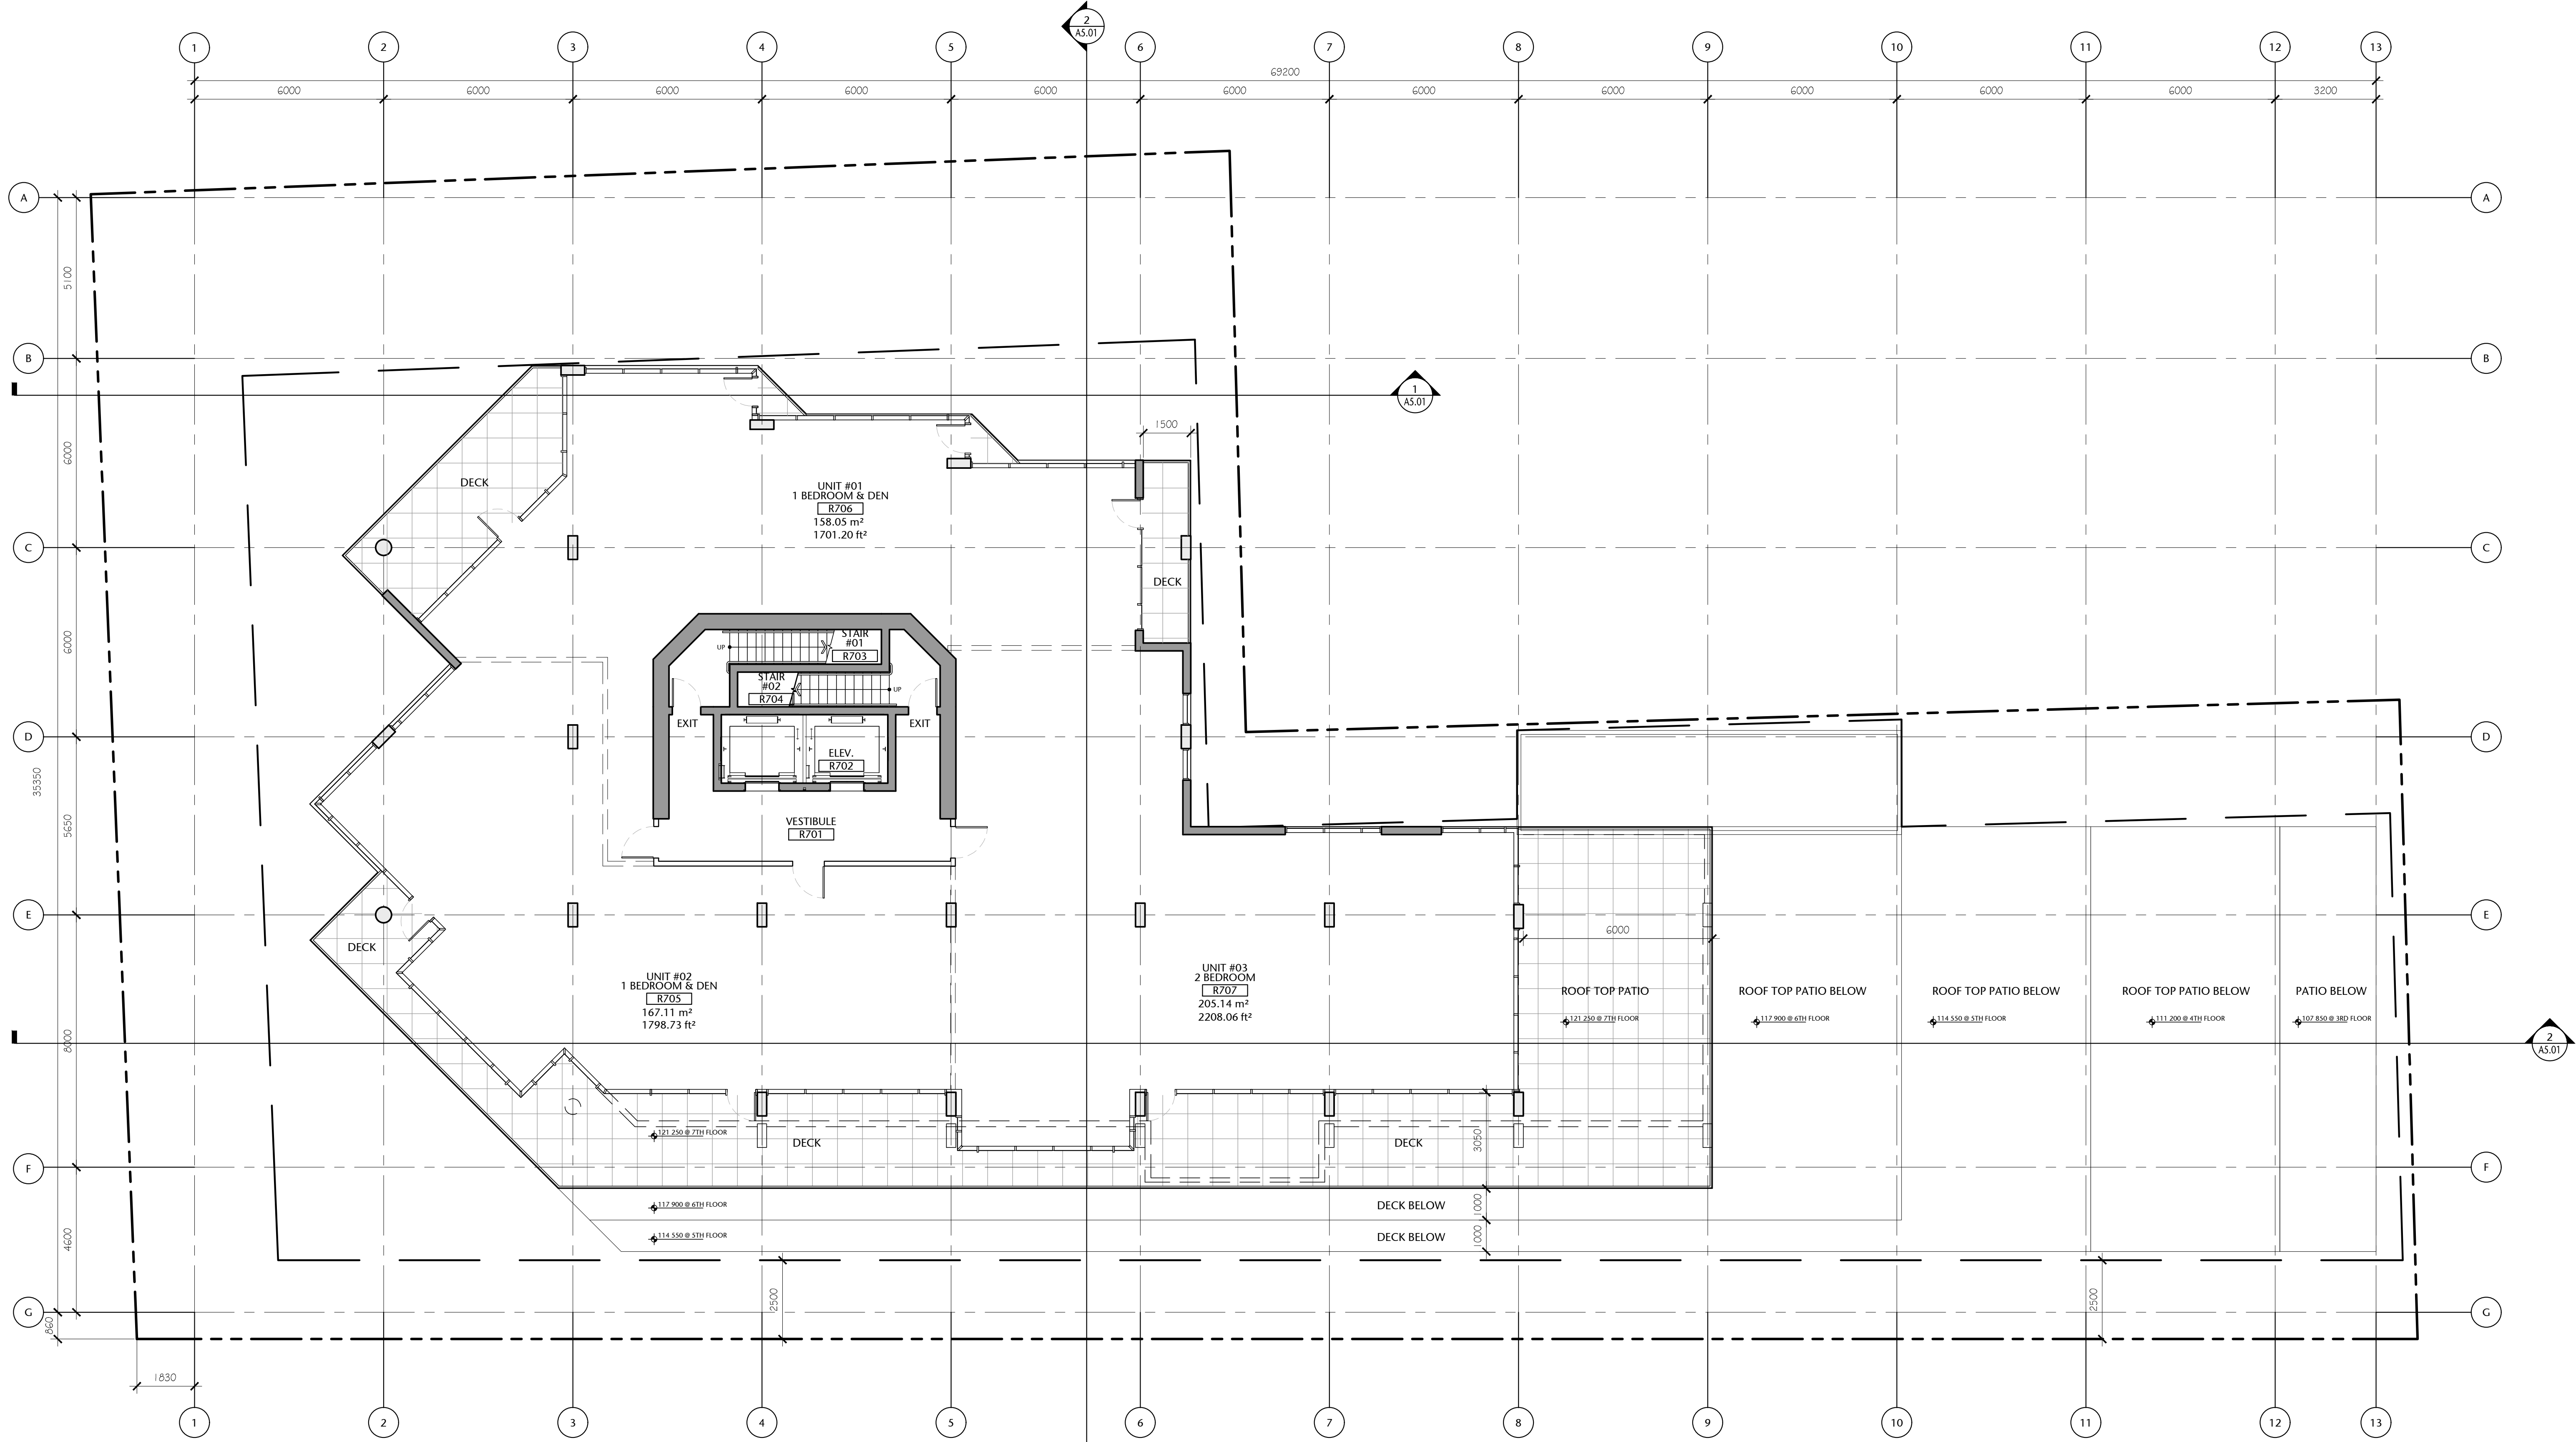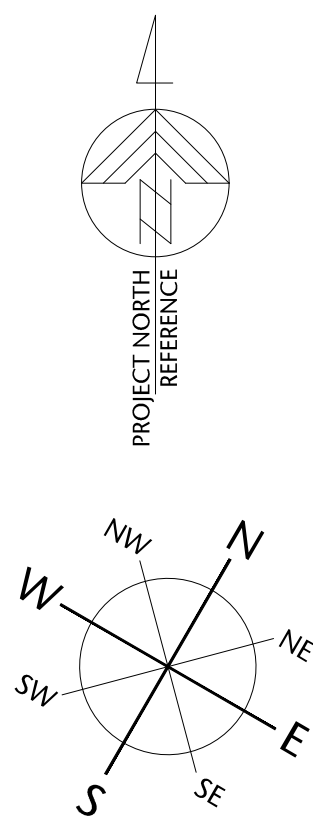

1 SEVENTH FLOOR PLAN
A2.08 1:100

 

Seventh Floor Gross Area:
577.83 sq. mts. (6219.71 sq. ft.)

(Possible Unit Mix Illustrated)

Overall Gross Floor Areas:

Gross Floor Area above Grade (excluding balconies)		
	SQ. MTS.	SQ. FT.
1. Main Floor :	870.14	9,366
2. Second Floor:	950.23	10,228
3. Third Floor:	937.43	10,090
4. Fourth Floor:	857.23	9,227
5. Fifth Floor:	785.82	8,459
6. Sixth Floor:	651.25	7,010
7. Seventh Floor:	577.83	6,220
8. Eighth Floor:	424.51	4,569
9. Mech Penthouse	98.78	1,063
TOTAL AREA	6153.22	66,232

257 BELLEVILLE
STREET

VICTORIA, BRITISH COLUMBIA

no.	issued for	date
1	DEVELOPMENT PERMIT	OCT 23/2012
2	DEVELOPMENT PERMIT	MAR 16/2020
3	REISSUED DEVELOPMENT PERMIT	DEC 03/2020



alan lowe architect inc.





mtalink.com Urban Design Architecture Interior Design

SEVENTH FLOOR PLAN


A2.08

drawn	scale
POR	AS SHOWN
checked	project no.
DL	20.118

These drawings are to be read in conjunction with the specifications, structural, mechanical and electrical drawings. This drawing must not be scaled. All dimensions, data and levels shall be verified before construction, and all errors or omissions reported immediately to the Architect.

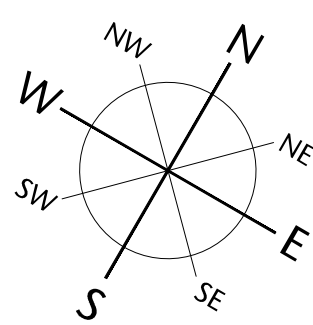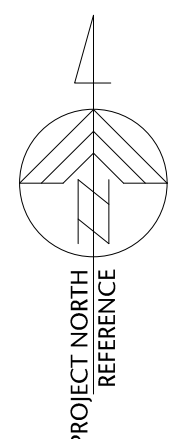

COMPASS NORTH

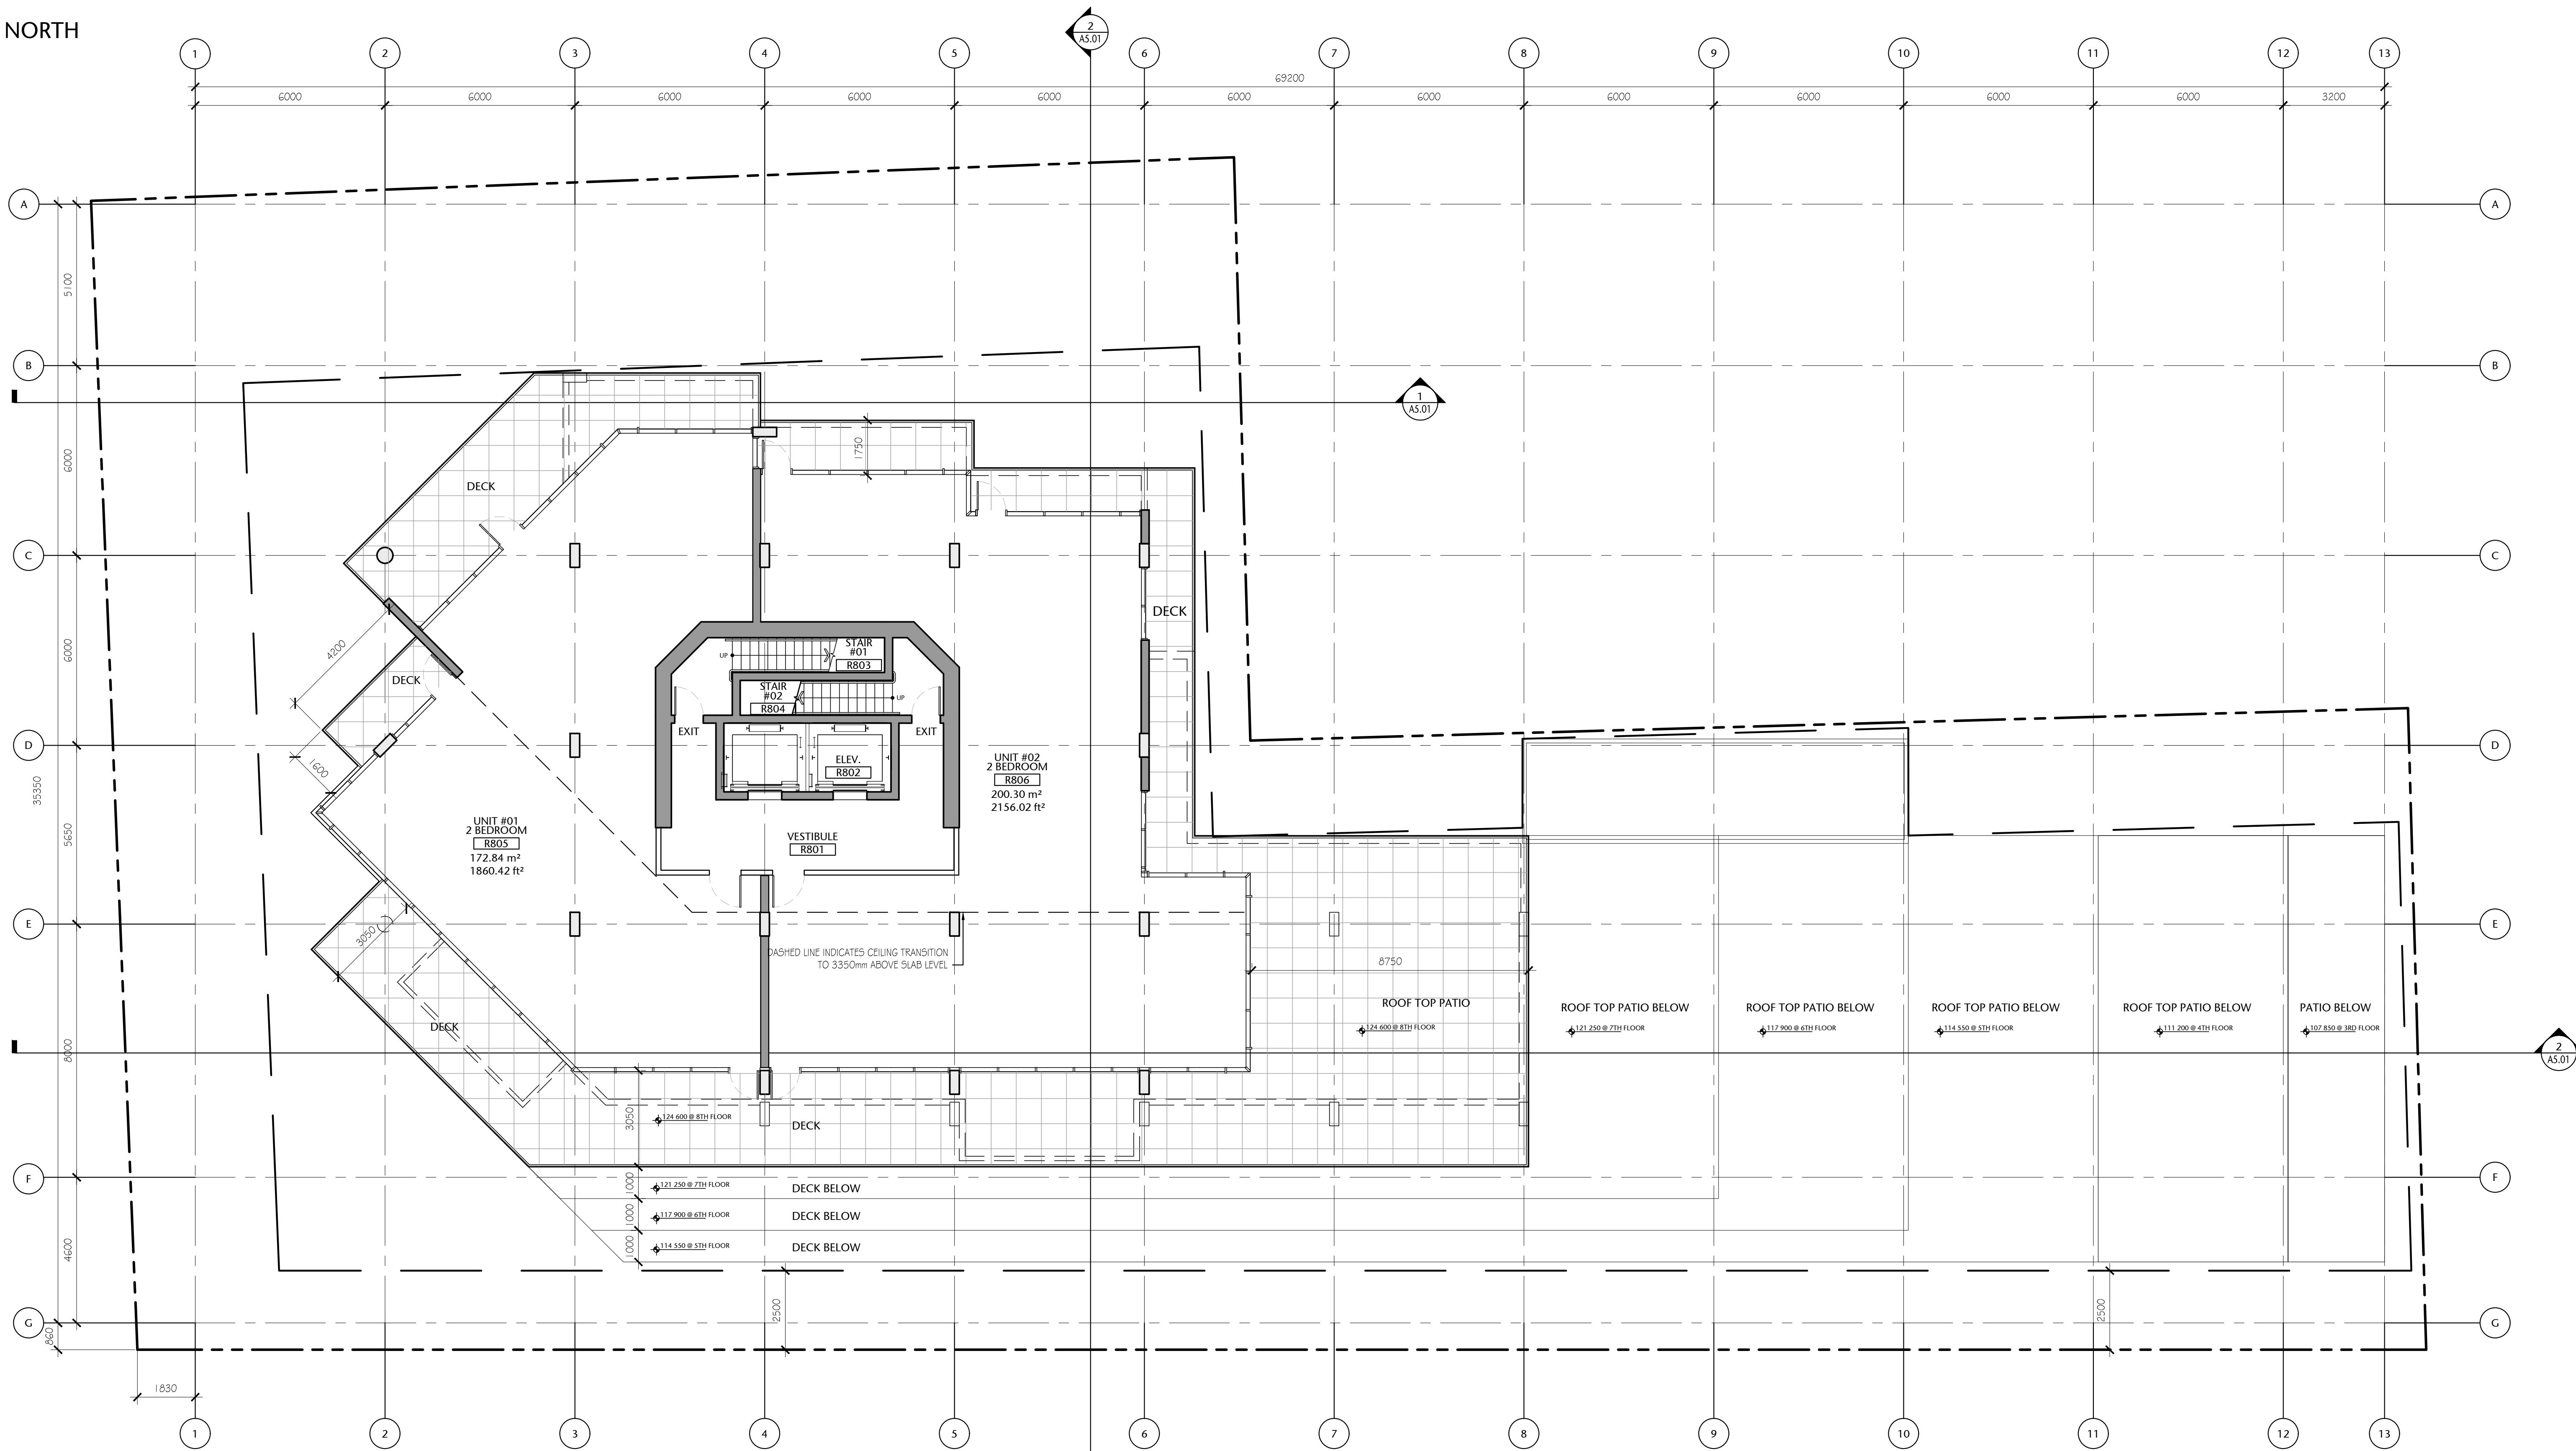

Eighth Floor Gross Area:
424.51 sq. mts. (4 569 sq. ft.)

(Possible Unit Mix Illustrated)

Overall Gross Floor Areas:

Gross Floor Area above Grade (excluding balconies)		
	SQ. MTS.	SQ. FT.
1. Main Floor :	870.14	9,366
2. Second Floor:	950.23	10,228
3. Third Floor:	937.43	10,090
4. Fourth Floor:	857.23	9,227
5. Fifth Floor:	785.82	8,459
6. Sixth Floor:	651.25	7,010
7. Seventh Floor:	577.83	6,220
8. Eighth Floor:	424.51	4,569
9. Mech Penthouse	98.78	1,063
TOTAL AREA	6153.22	66,232

1 EIGHTH FLOOR PLAN
A2.09 1:100



257 BELLEVILLE
STREET

VICTORIA, BRITISH COLUMBIA

no.	issued for	date
1	DEVELOPMENT PERMIT	OCT 23/2012
2	DEVELOPMENT PERMIT	MAR 16/2020
3	REISSUED DEVELOPMENT PERMIT	DEC 03/2020



alan **lowe** architect inc.



310, 625 - 11 Ave SW Calgary AB T2R 0E1
t. 403.264.8700
f. 403.264.8029



mtalink.com Urban Design Architecture Interior Design

EIGHTH FLOOR PLAN

A2.09

drawn	scale
POR	AS SHOWN
checked	project no.
DL	20.118

P:\2020\20.118.257 Belleville DP Renewal\ID Integrated Design\ID20 AutoCAD\ID22 Current\Sheets\WD 30x42 Sheets\A2.00\20.118-09-151-A2.10 MECH. PENTHOUSE PLAN.dwg 20/01/2022 8:05 PM Iona Cunkiewicz

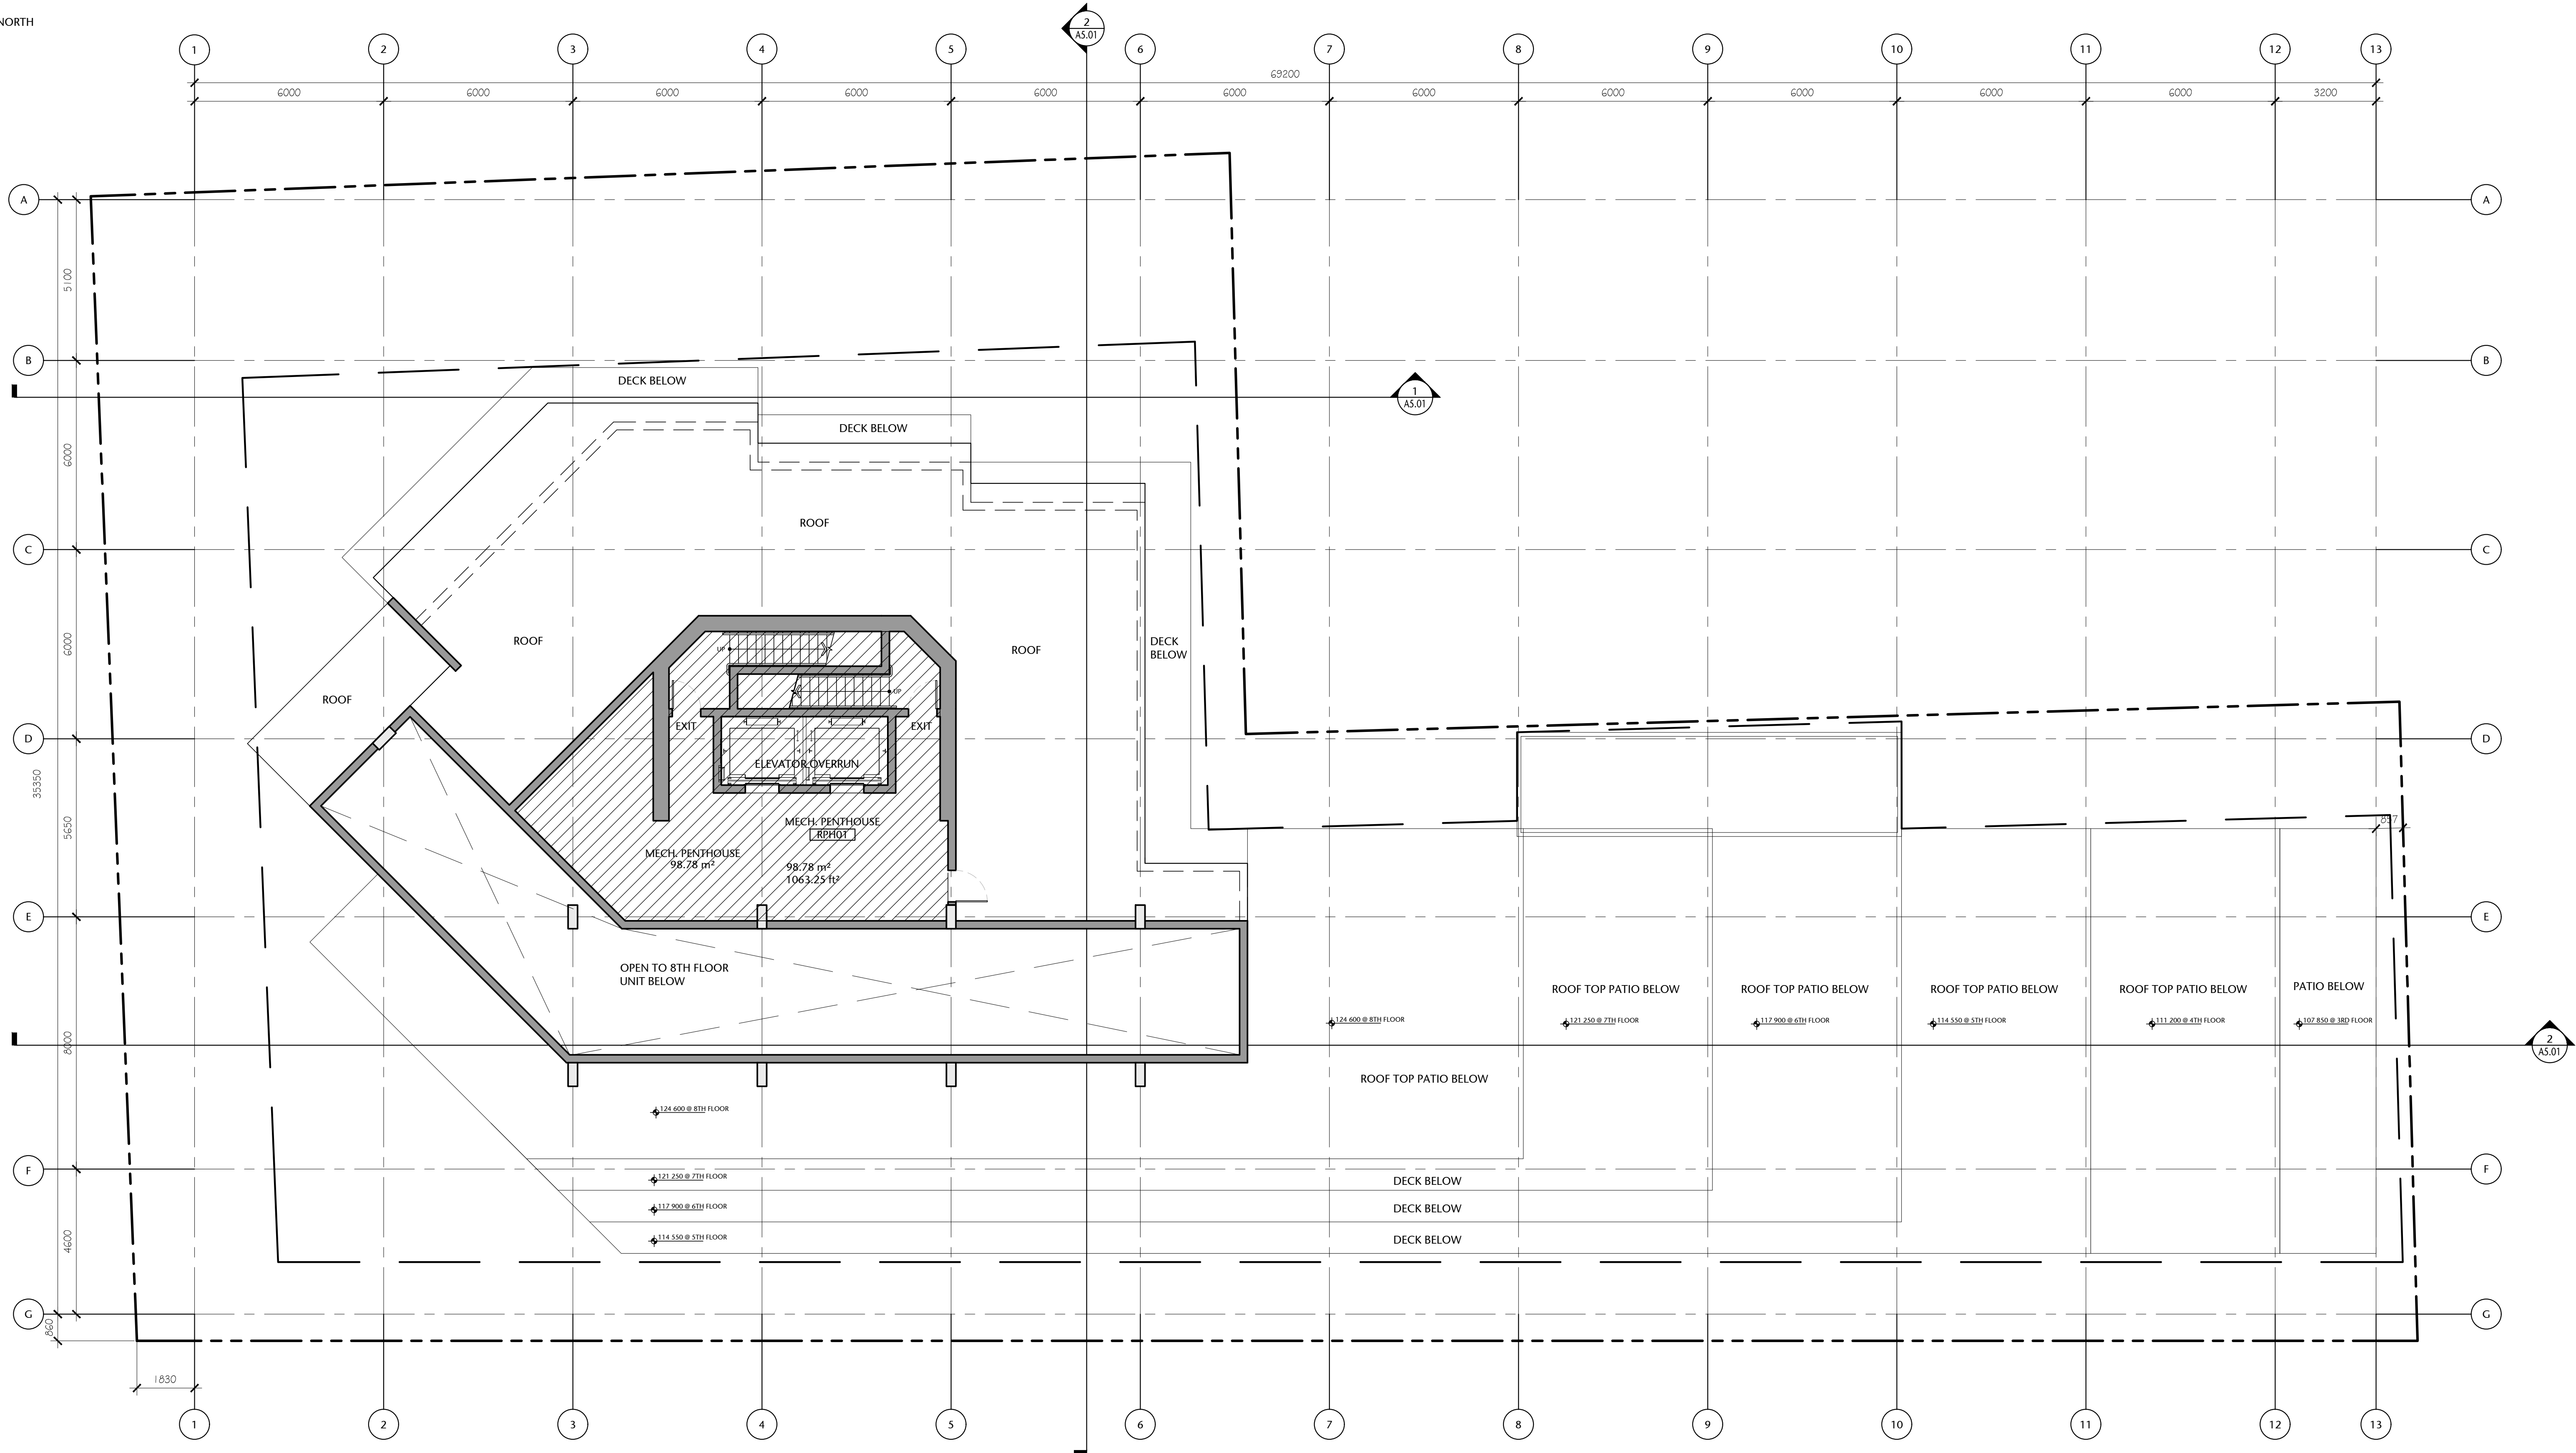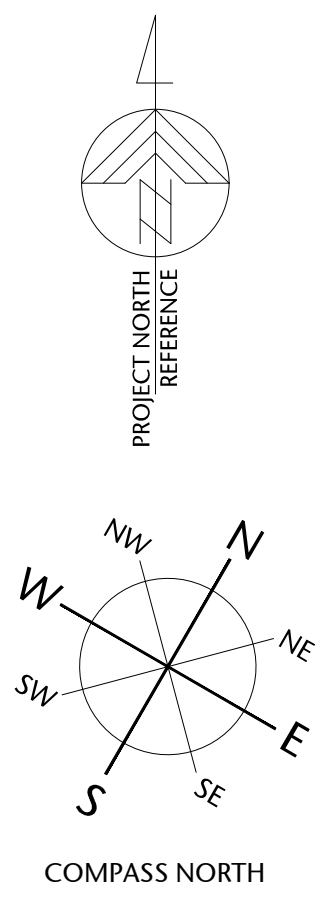

1 MECH. PENTHOUSE PLAN
A2.10 1:100



Overall Gross Floor Areas:

Gross Floor Area above Grade (excluding balconies)		
	SQ. MTS.	SQ. FT.
1. Main Floor :	870.14	9,366
2. Second Floor:	950.23	10,228
3. Third Floor:	937.43	10,090
4. Fourth Floor:	857.23	9,227
5. Fifth Floor:	785.82	8,459
6. Sixth Floor:	651.25	7,010
7. Seventh Floor:	577.83	6,220
8. Eighth Floor:	424.51	4,569
9. Mech Penthouse	98.78	1,063
TOTAL AREA	6153.22	66,232

257 BELLEVILLE
STREET

VICTORIA, BRITISH COLUMBIA

no.	issued for	date
1	DEVELOPMENT PERMIT	OCT 23/2012
2	DEVELOPMENT PERMIT	MAR 16/2020
3	REISSUED DEVELOPMENT PERMIT	DEC 03/2020



alan **lowe** architect inc.



mtalink.com Urban Design Architecture Interior Design



MECH. PENTHOUSE PLAN

A2.10

drawn	scale
POR	AS SHOWN
checked	project no.
DL	20.118

COPYRIGHTED. This design is the exclusive property of the Architect and shall not be reproduced without the Architects written permission. These drawings are to be read in conjunction with the specifications, structural, mechanical and electrical drawings. All dimensions, data and levels shall be verified before construction, and all errors or omissions reported immediately to the Architect.

P:\2020\20.118.257 Belleville DP Renewal\ID Integrated Design\ID20 AutoCAD\ID22 Current\Sheets\WD 30x42 Sheets\A2.00\20.118.09-151-A2.11 ROOF PLAN.dwg 2020/12/02 8:07 PM Iona Clunkiewicz

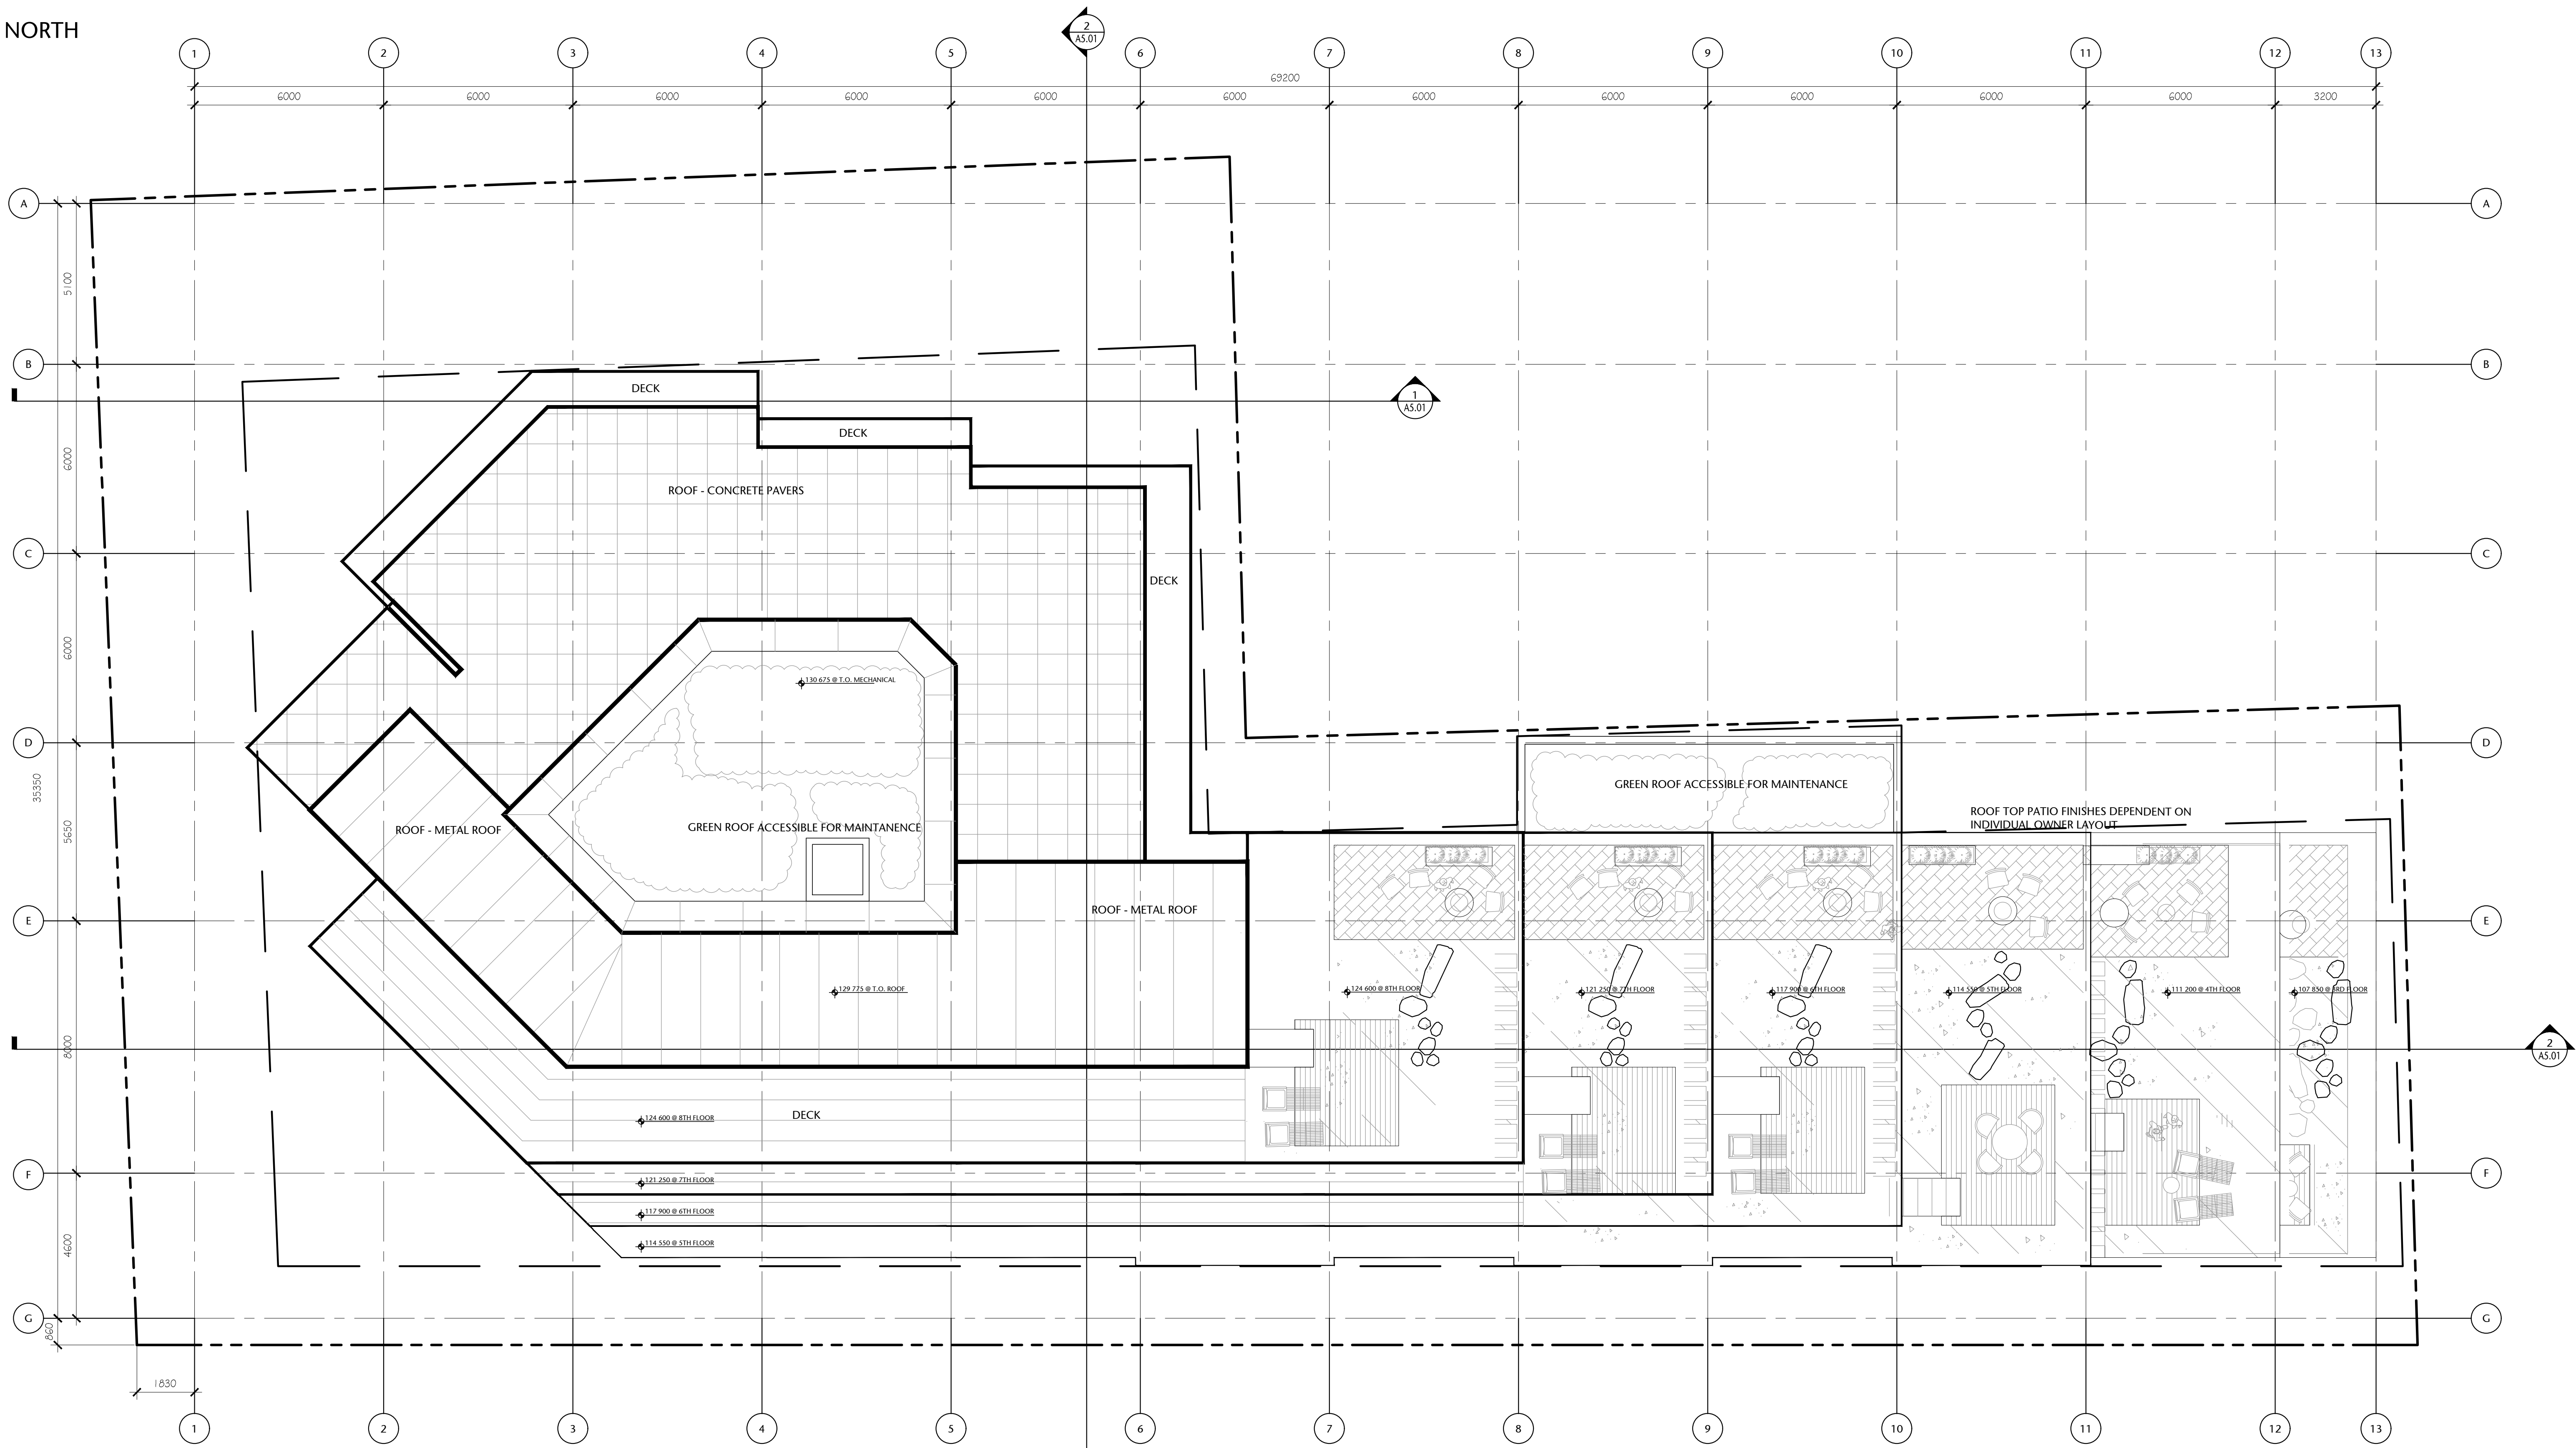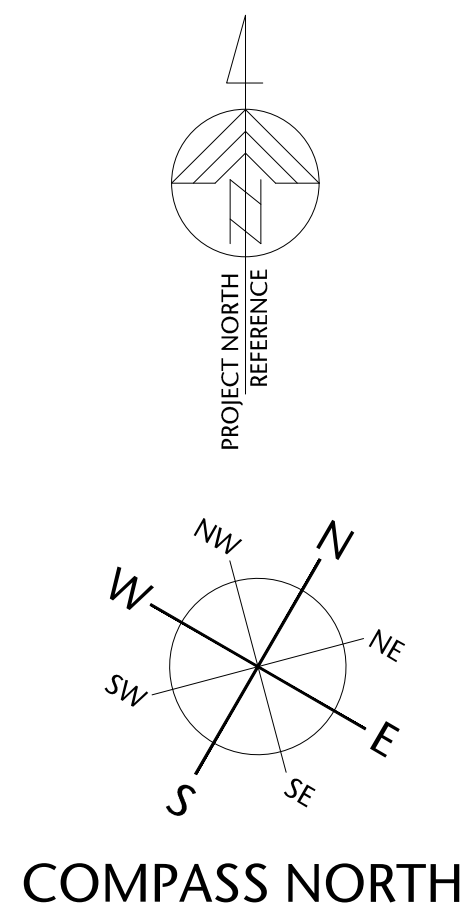

1 ROOF PLAN
A2.11 1:100



257 BELLEVILLE
STREET

VICTORIA, BRITISH COLUMBIA

no.	issued for	date
1	DEVELOPMENT PERMIT	OCT 23/2012
2	DEVELOPMENT PERMIT	MAR 16/2020
3	REISSUED DEVELOPMENT PERMIT	DEC 03/2020



alan lowe architect inc.



mtalink.com Urban Design Architecture Interior Design

drawing title
ROOF PLAN

A2.11 sheet

drawn DS, POR	scale AS SHOWN
checked DL	project no. 20.118

COPYRIGHTED. This design is the exclusive property of the Architect and shall not be reproduced without the Architects written permission. These drawings are to be read in conjunction with the specifications, structural, mechanical and electrical drawings. This drawing must not be scaled. All dimensions, data and levels shall be verified before construction, and all errors or omissions reported immediately to the Architect.

P:\2020\20.118.257 Belleville DP Renewal\ID Integrated Design\ID20 AutoCAD\ID22 Current\Sheets\A4.00\20.118-09-151-A4.01 ELEVATIONS.dwg 2020/12/02 9:18 PM Ilona Czumbevicz

257 BELLEVILLE STREET

VICTORIA, BRITISH COLUMBIA

no.	issued for	date
1	DEVELOPMENT PERMIT	OCT 23/2012
2	DEVELOPMENT PERMIT	MAR 16/2020
3	REISSUED DEVELOPMENT PERMIT	DEC 03/2020
4	REISSUED DEVELOPMENT PERMIT	APR/11/2022



alan lowe architect inc.



310, 625 - 11 Ave SW Calgary AB T2R 0E1
T. 403.264.8700
F. 403.264.8029






mtalink.com Urban Design Architecture Interior Design

drawing title

ELEVATIONS


A4.01

drawn	DL	AS SHOWN	scale
checked	DL	project no.	20.118

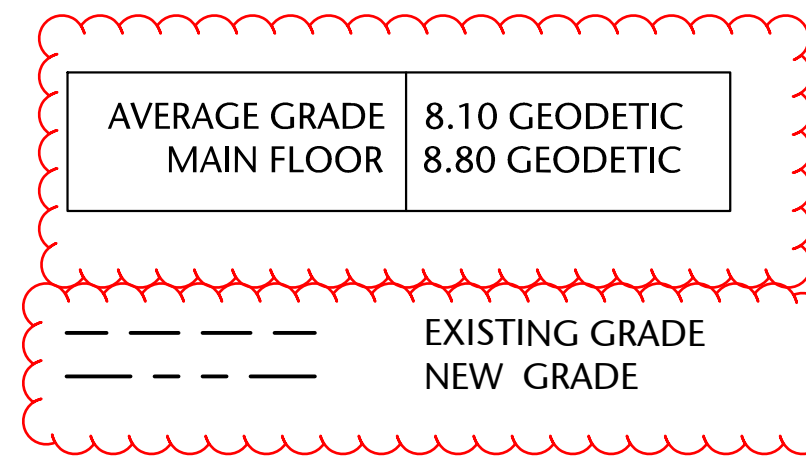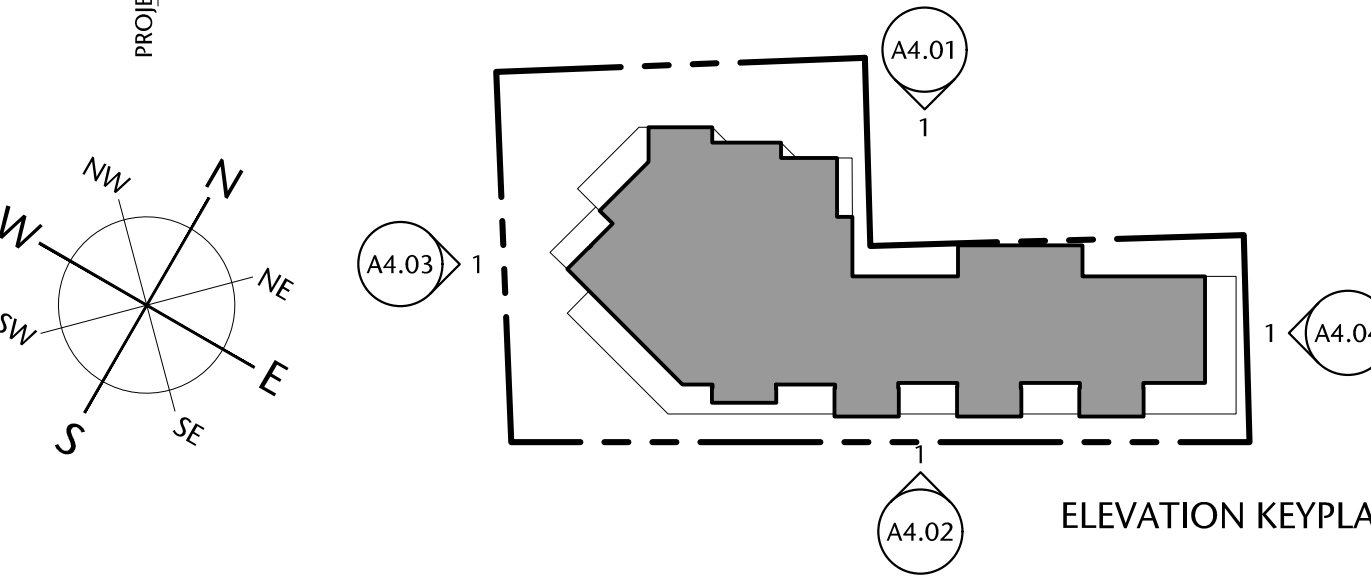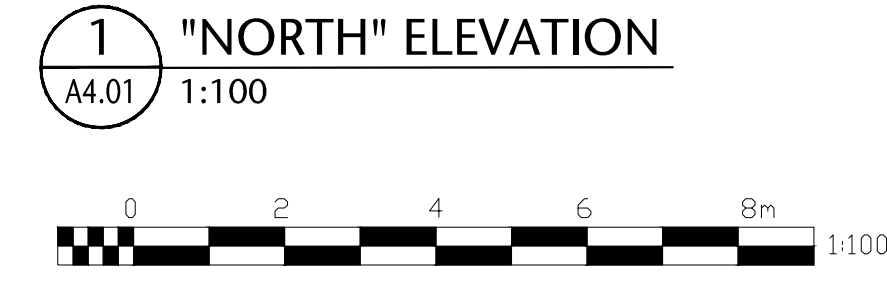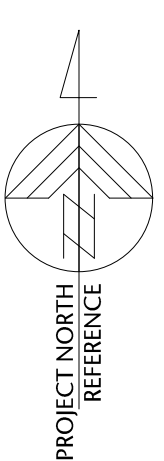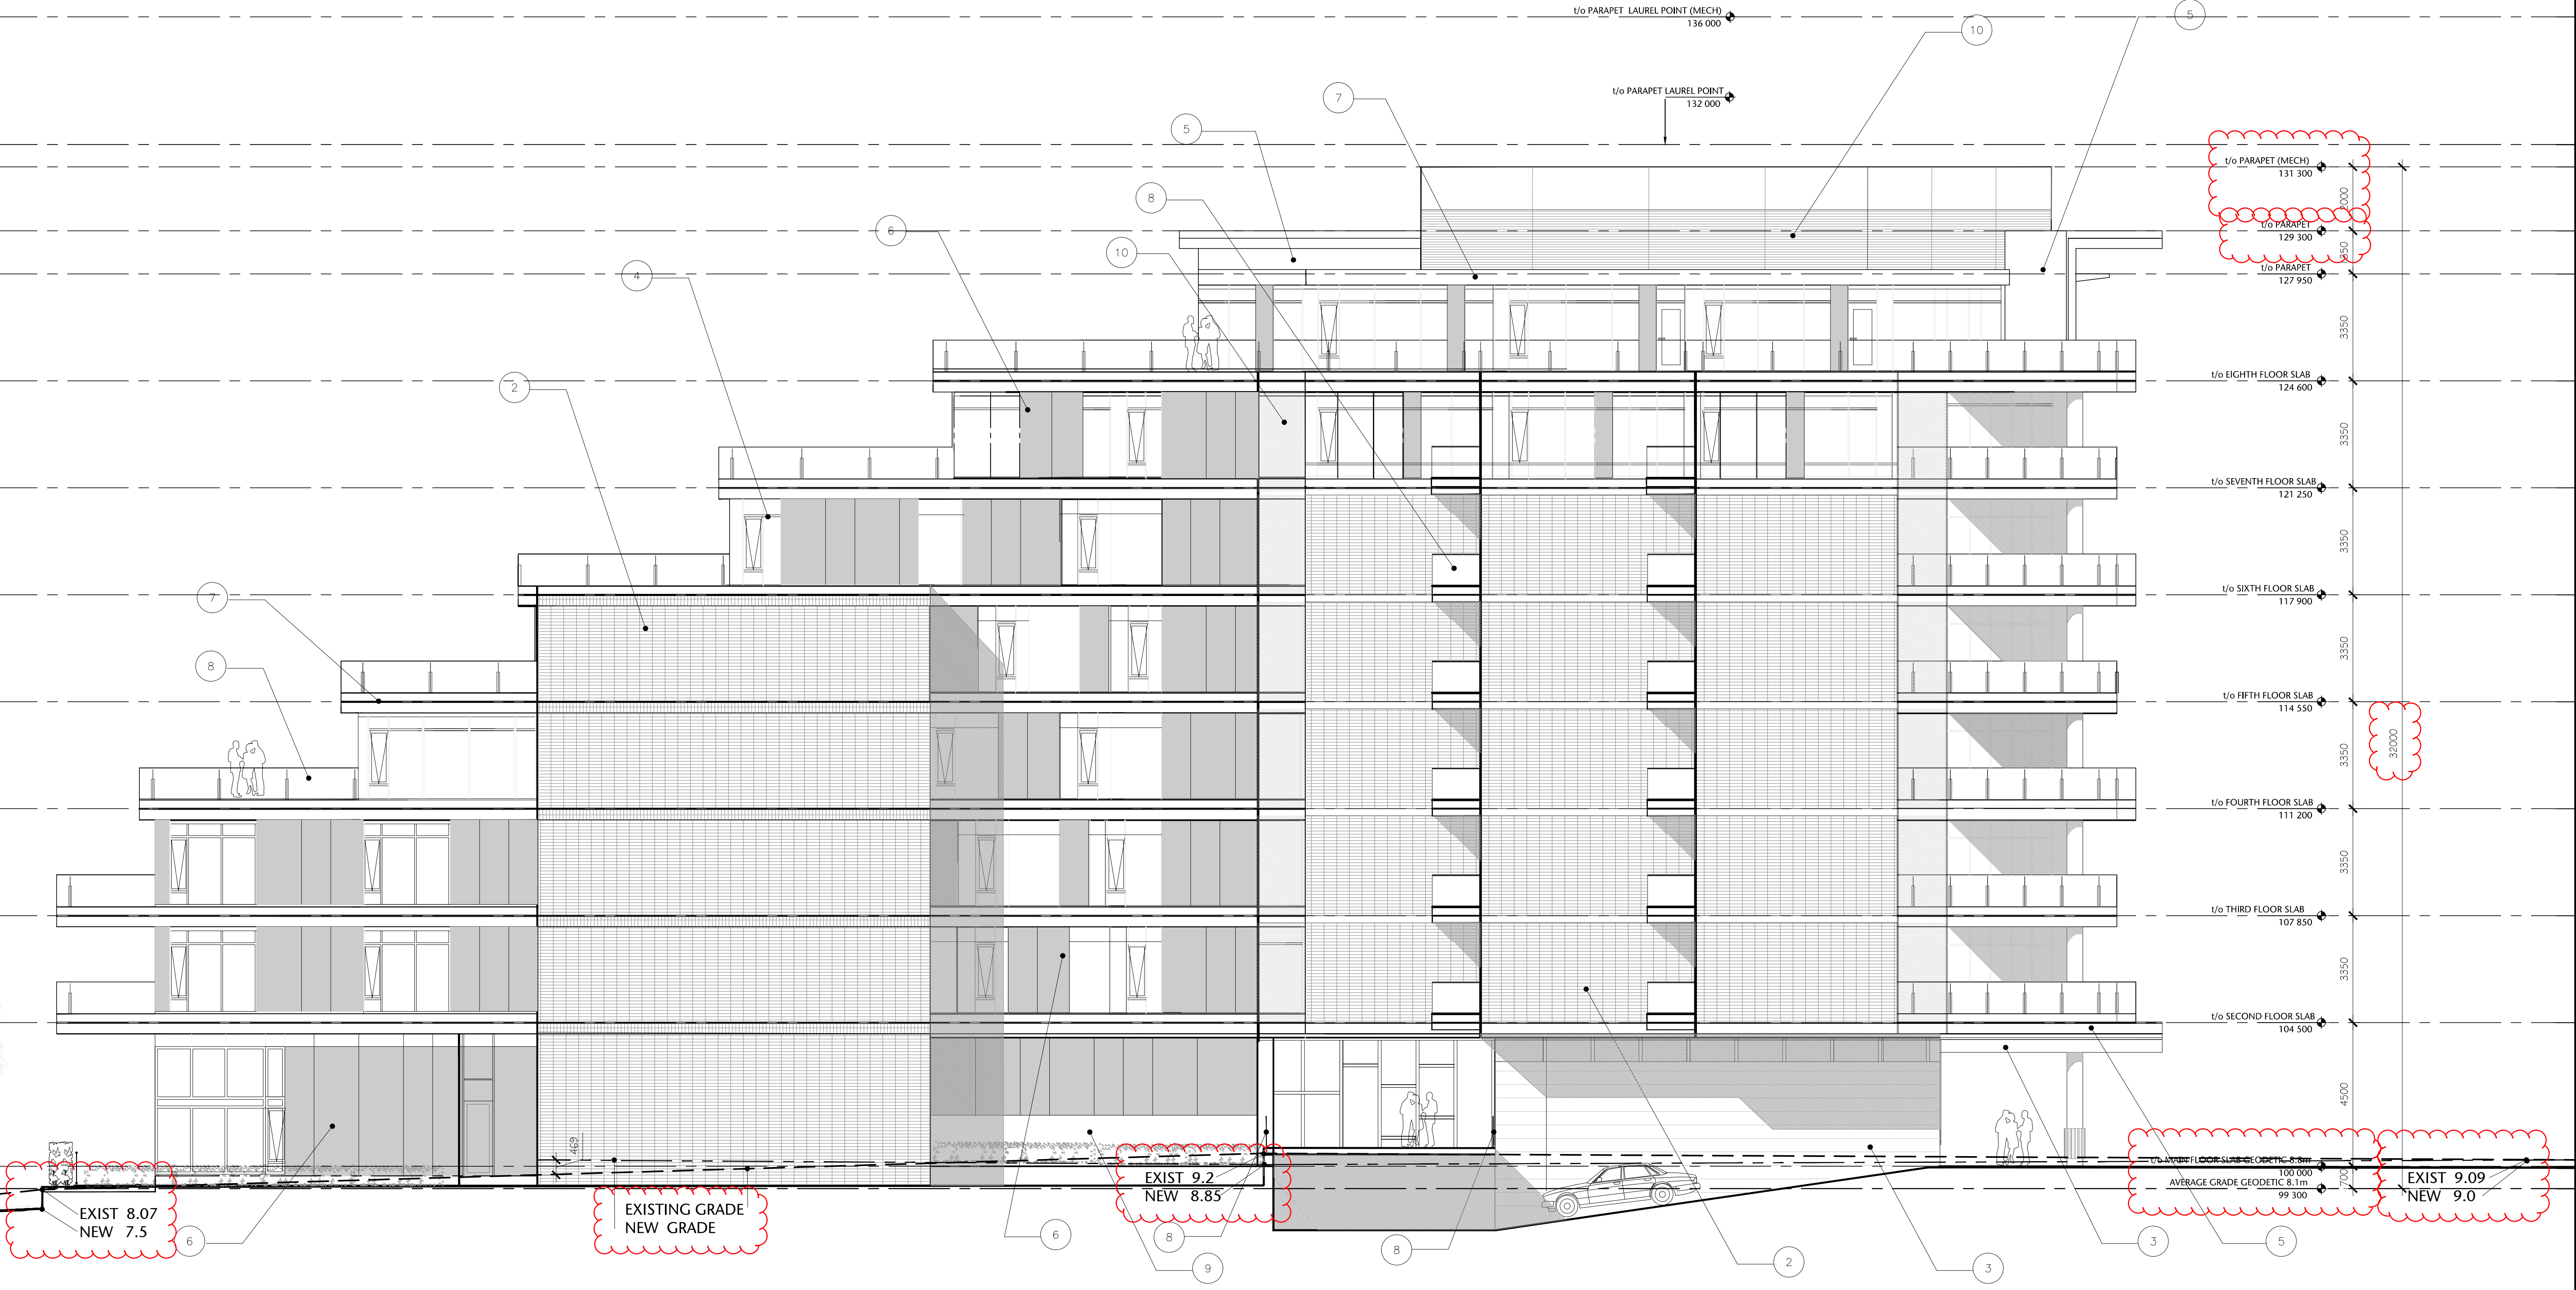

- 1 cast in place concrete
- 2 smooth red stack bond brick
- 3 British Columbia western red cedar
- 4 anodized aluminium
- 5 gray painted aluminium
- 6 composite wood panel - rustic color
- 7 prefinished gray aluminium
- 8 clear glass handrail
- 9 tinted vision glass
- 10 corrugated anodized aluminium

P:\2020\20.118.257 Belleville DP Renewal\ID Integrated Design\ID20 AutoCAD\ID22 Current\Sheets\A4.02.01.151-A4.02 ELEVATIONS.dwg 2020/12/02 9:19 PM Ilona Czumbevicz

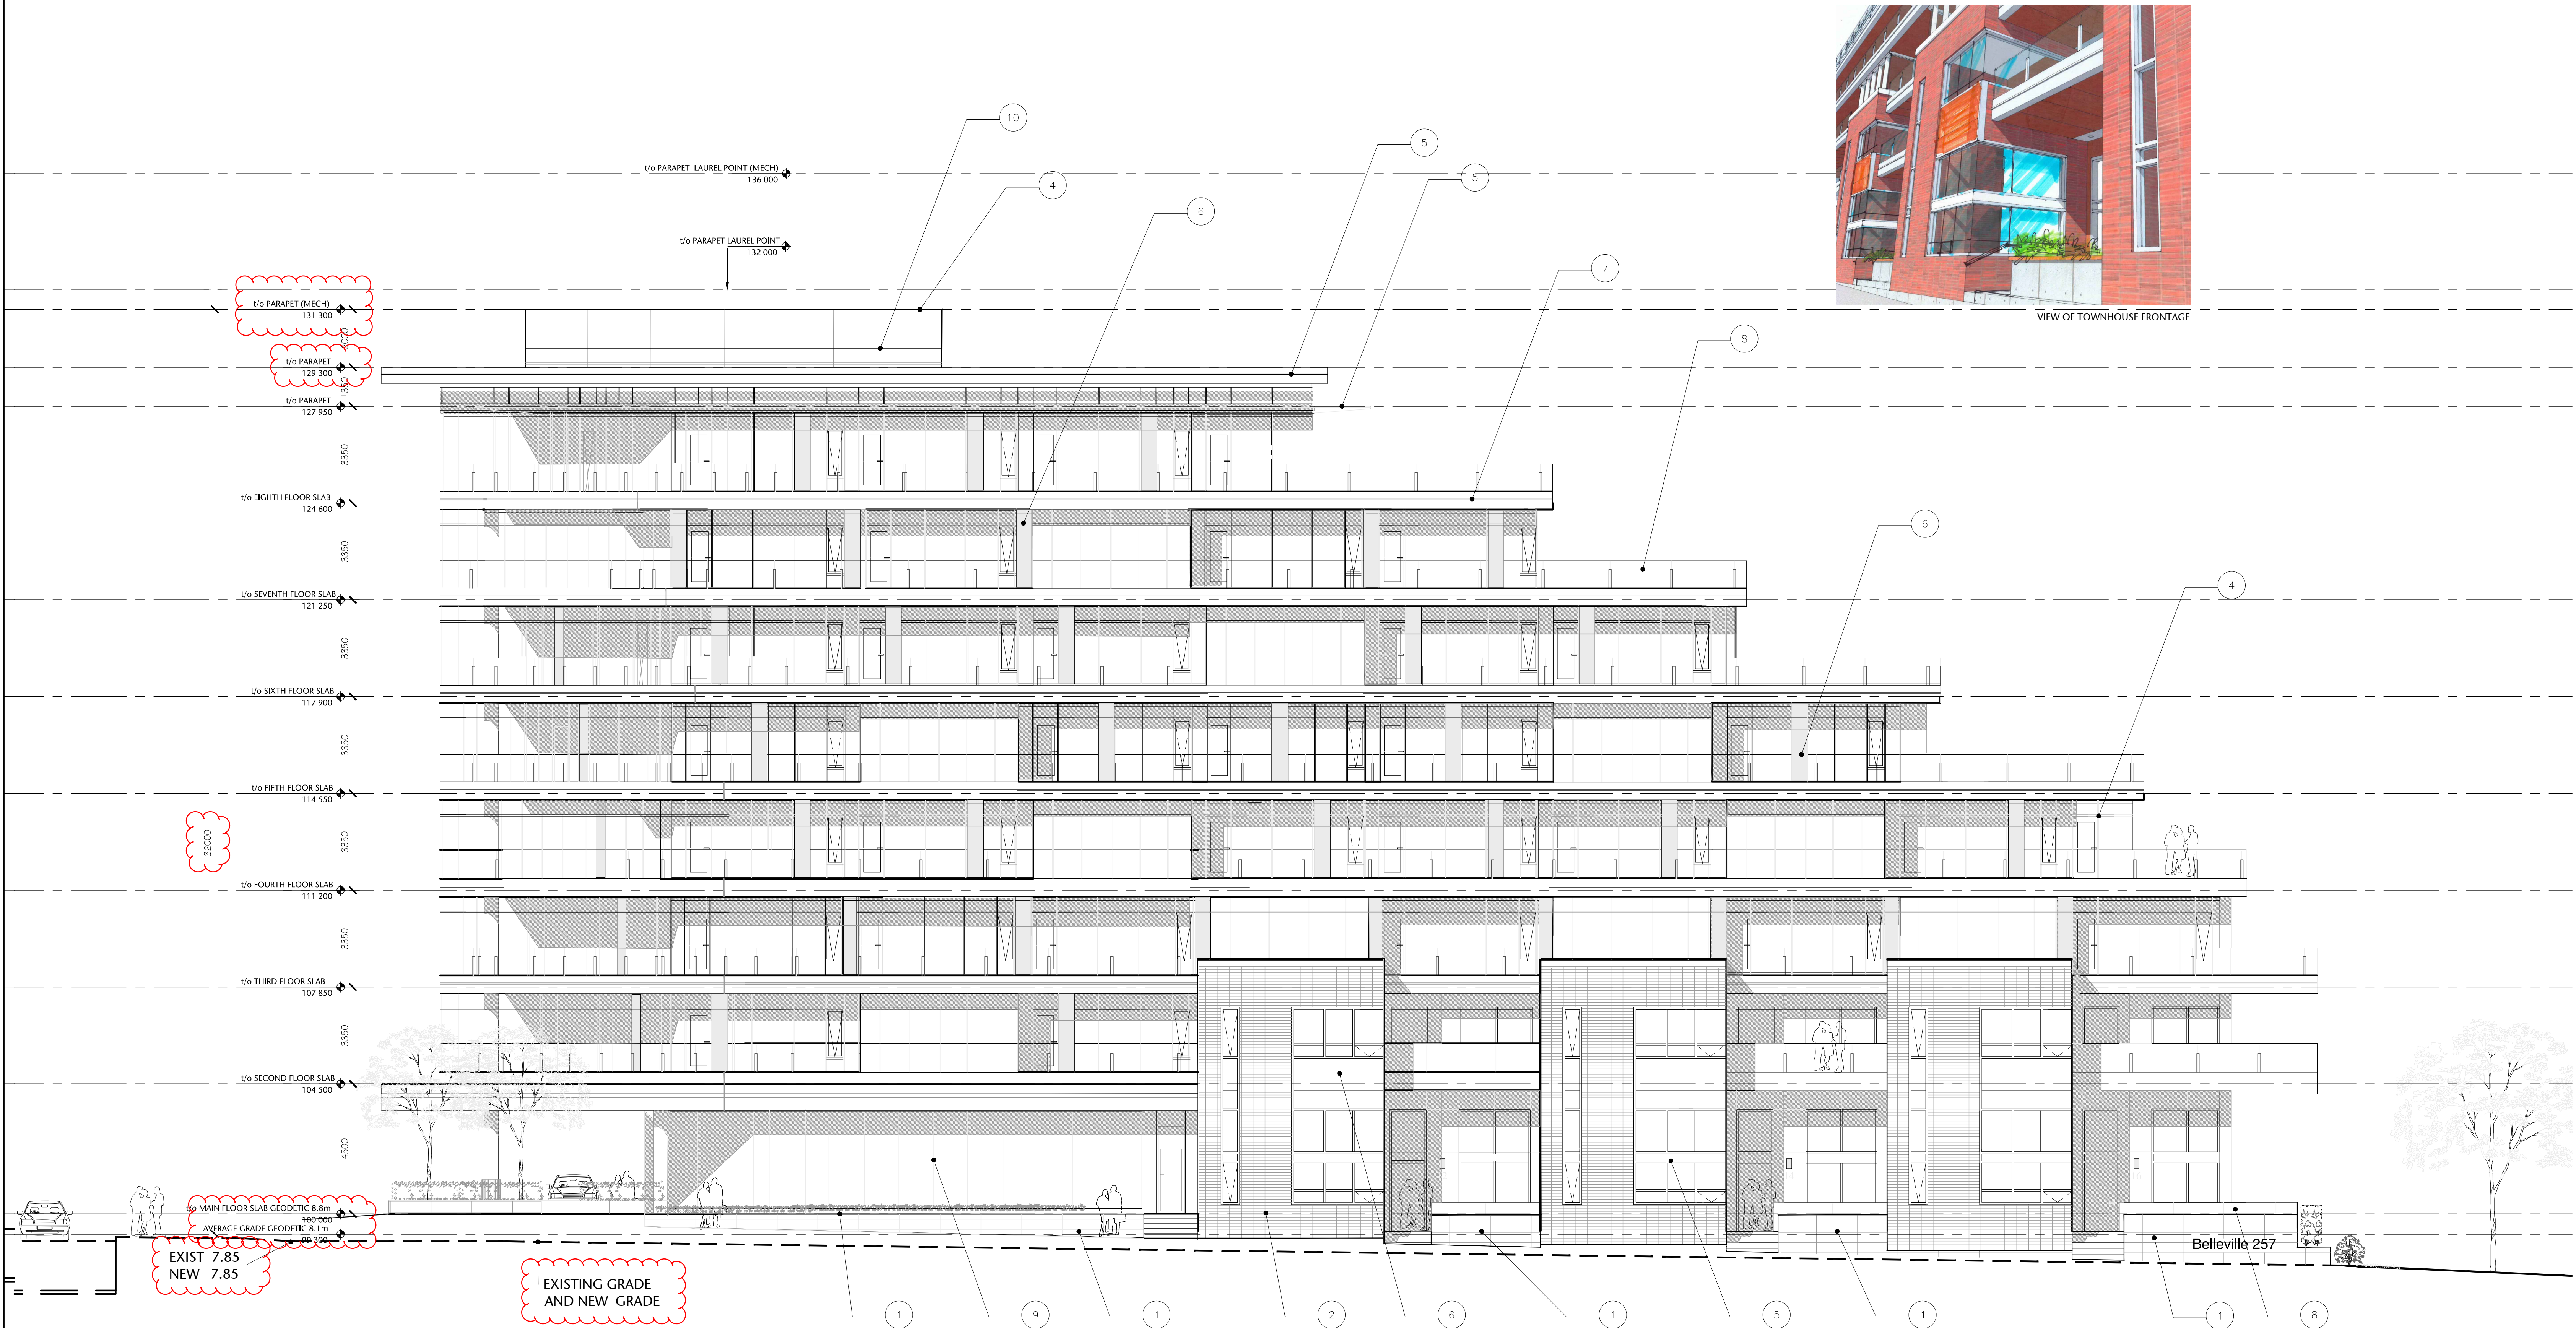

257 BELLEVILLE STREET

VICTORIA, BRITISH COLUMBIA

no.	issued for	date
1	DEVELOPMENT PERMIT	OCT 23/2012
2	DEVELOPMENT PERMIT	MAR 16/2020
3	REISSUED DEVELOPMENT PERMIT	DEC 03/2020
4	REISSUED DEVELOPMENT PERMIT	APR/11/2022



consultant

alan **lowe** architect inc.



Urban Design Architecture Interior Design

drawing title


ELEVATIONS

A4.02

drawn	DL	AS SHOWN	scale
checked	DL	20.118	project no.

COPYRIGHTED. This design is the exclusive property of the Architect and shall not be reproduced without the Architects written permission. These drawings are to be read in conjunction with the specifications, structural, mechanical and electrical drawings. This drawing must not be scaled. All dimensions, data and levels shall be verified before construction, and all errors or omissions reported immediately to the Architect.

 VICTORIA, BRITISH COLUMBIA

seal

ultant


mtalink.com Urban Design Architecture Interior Design

Drawing title



sheet

checked	project no
	20.118


These drawings are to be read in conjunction with the specifications, structural, mechanical and electrical drawings. This drawing must not be scaled. All dimensions, data and levels shall be verified before construction, and all errors or omissions reported immediately to the Architect.

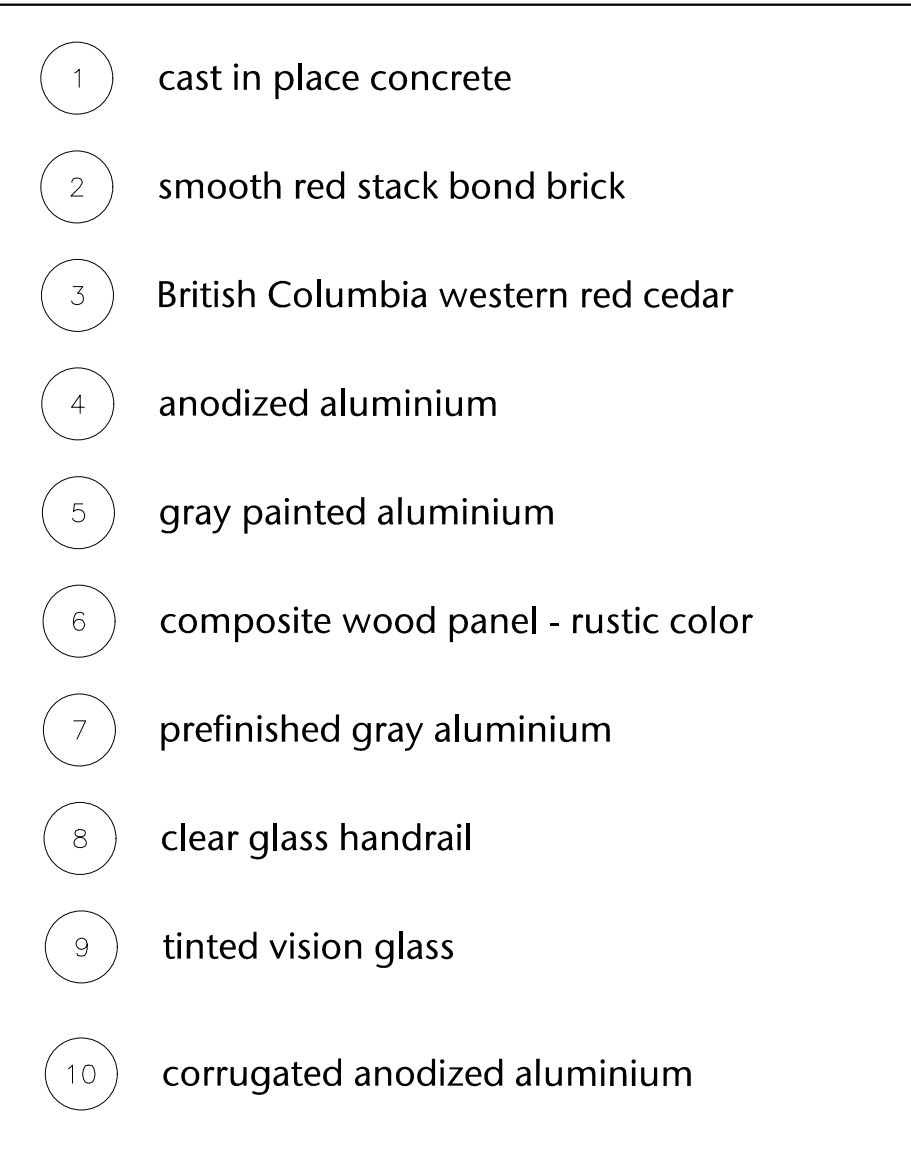

P:\2020\20.118.257 Belleville DP Renewal\ID Integrated Design\ID20 AutoCAD\ID22 Current\Sheets\A4.00\20.118.09-151-A4.04 ELEVATIONS.dwg 2020/12/02 9:23 PM Ilona Ciunbănevic

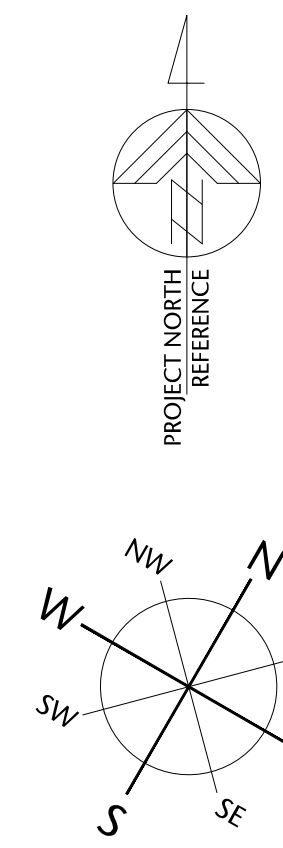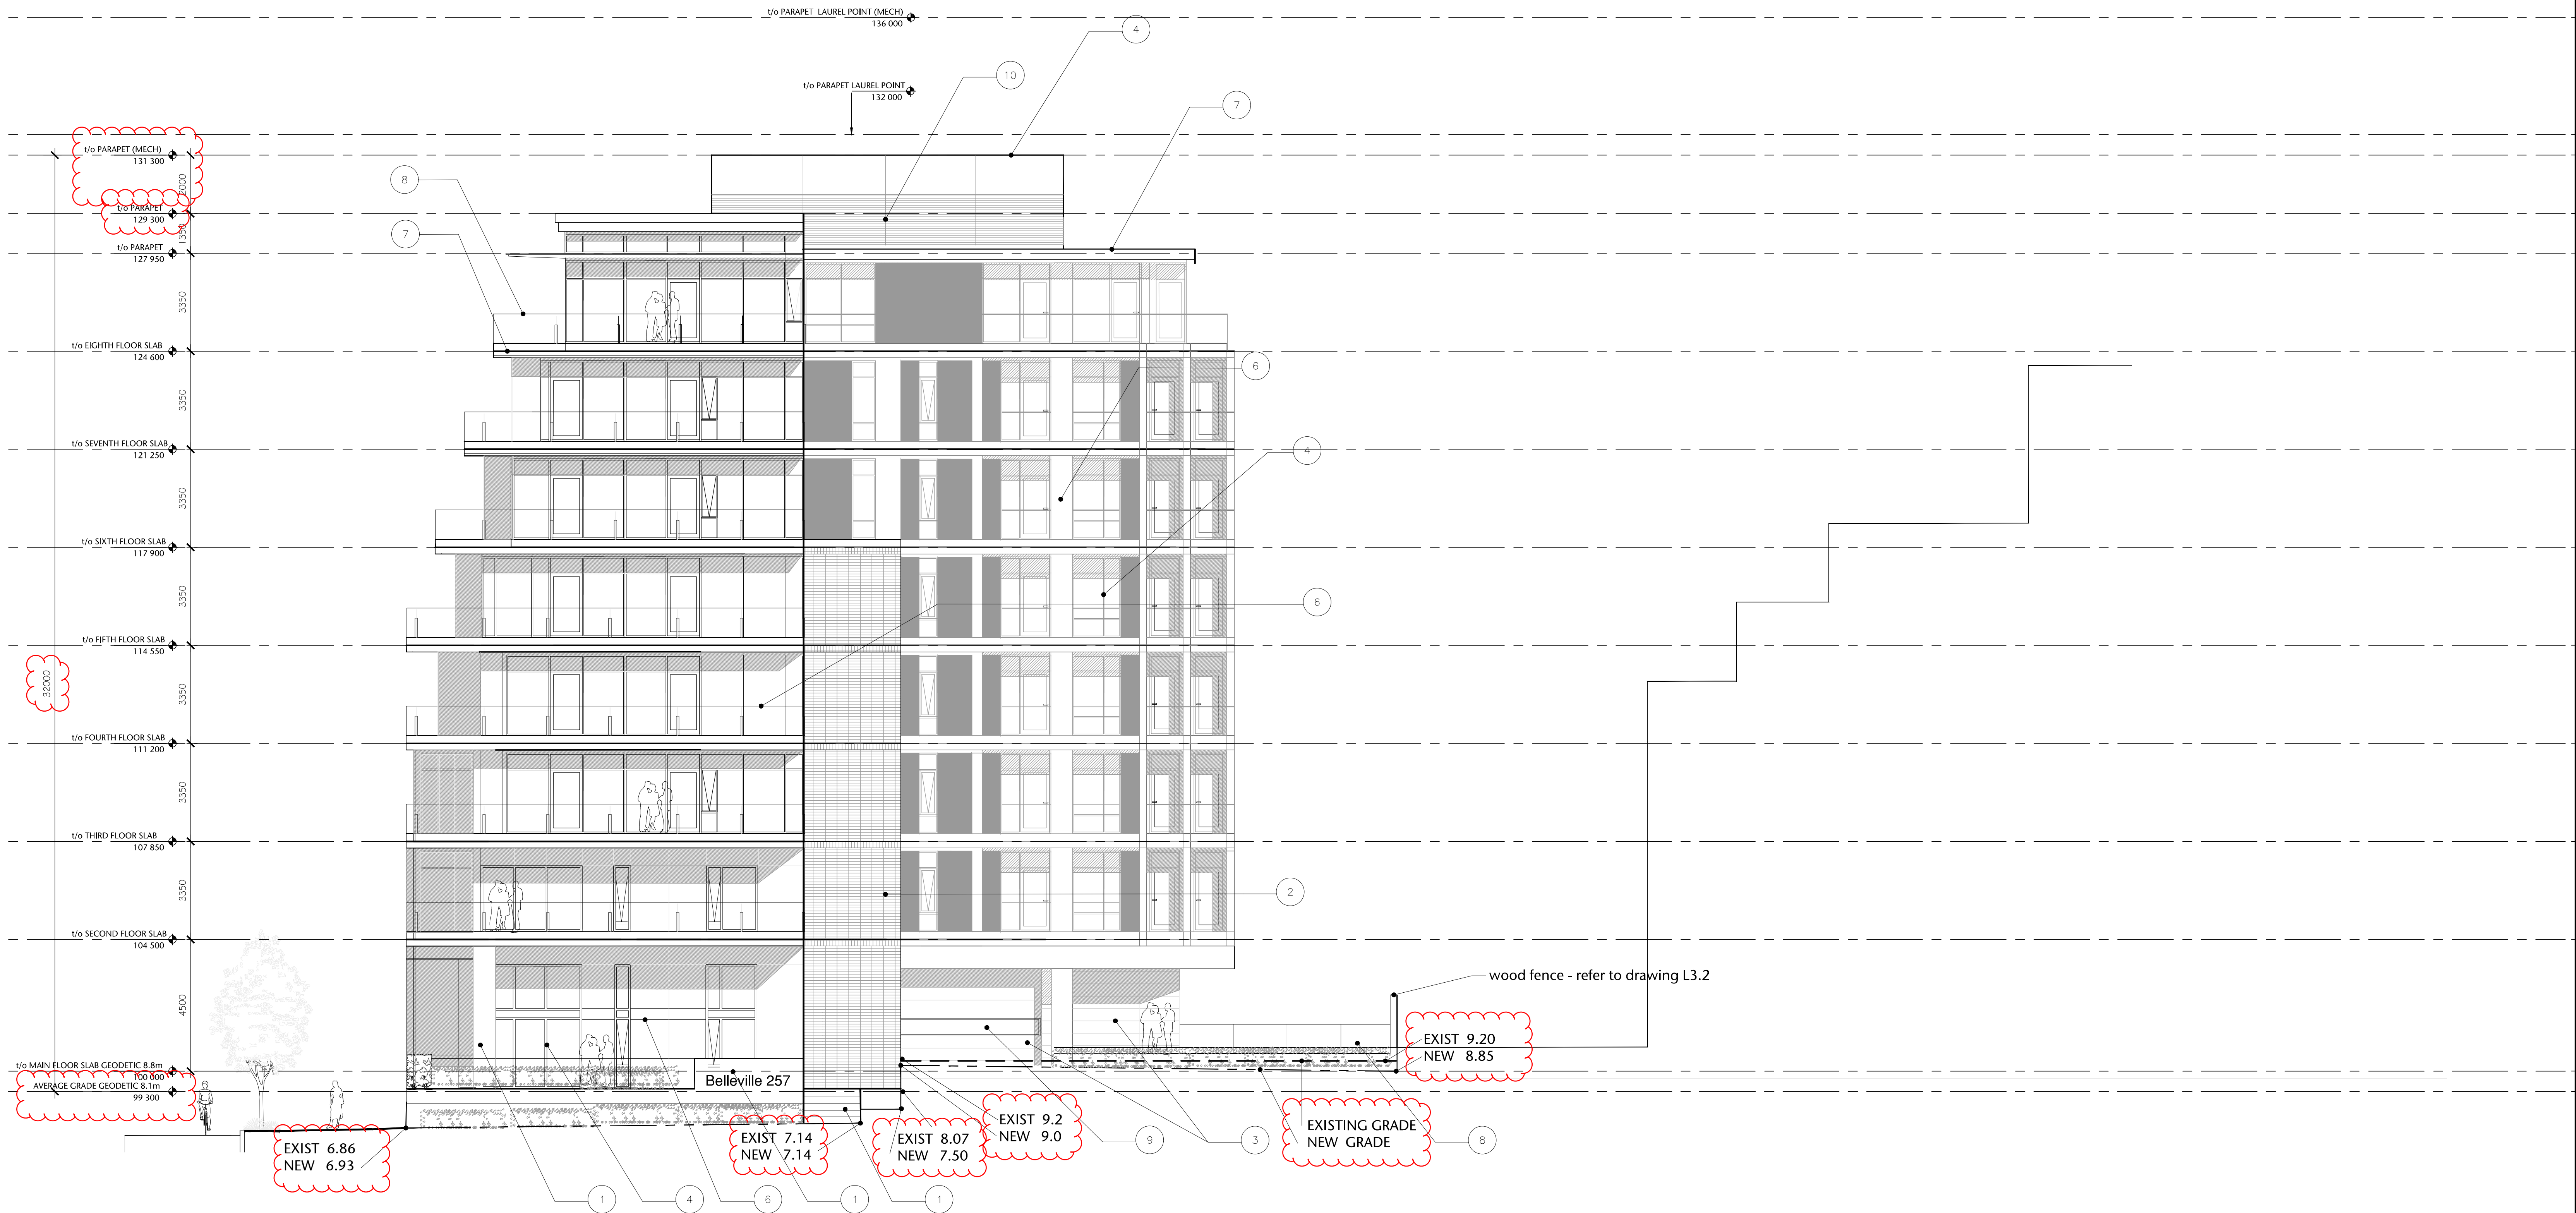

1 "EAST" ELEVATION
A4.04 1:100

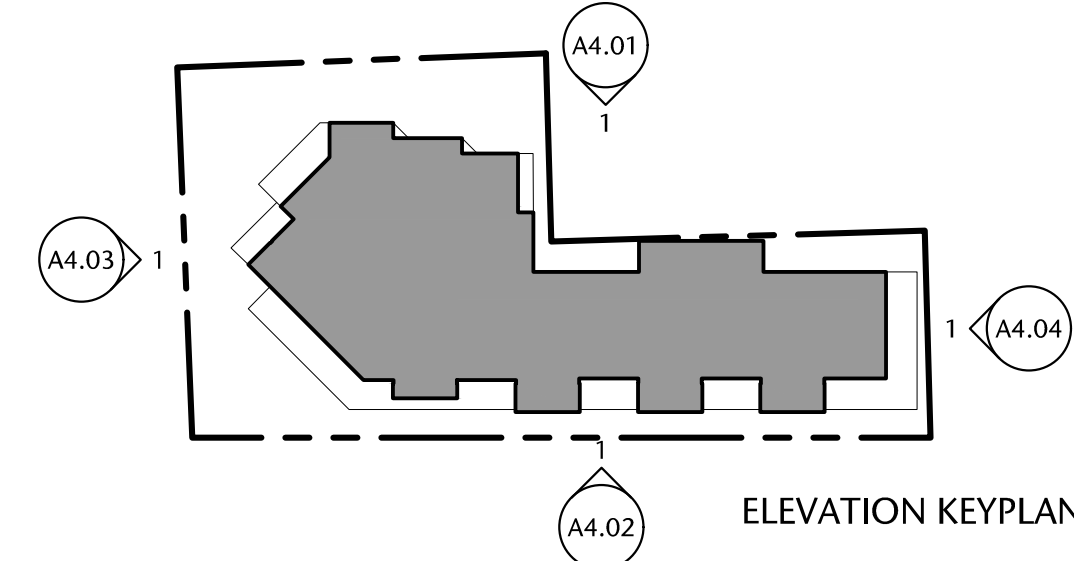

AVERAGE GRADE MAIN FLOOR	8.10 GEODETIC 8.80 GEODETIC
----- EXISTING GRADE ----- NEW GRADE	

- 1 cast in place concrete
- 2 smooth red stack bond brick
- 3 British Columbia western red cedar
- 4 anodized aluminium
- 5 gray painted aluminium
- 6 composite wood panel - rustic color
- 7 prefinished gray aluminium
- 8 clear glass handrail
- 9 tinted vision glass
- 10 corrugated anodized aluminium

257 BELLEVILLE
STREET

VICTORIA, BRITISH COLUMBIA

no.	issued for	date
1	DEVELOPMENT PERMIT	OCT 23/2012
2	DEVELOPMENT PERMIT	MAR 16/2020
3	REISSUED DEVELOPMENT PERMIT	DEC 03/2020
4	REISSUED DEVELOPMENT PERMIT	APR/11/2022



alan lowe architect inc.



mtalink.com Urban Design Architecture Interior Design


ELEVATIONS

A4.04



drawn	DL	scale	AS SHOWN
checked	DL	project no.	20.118

COPYRIGHTED. This design is the exclusive property of the Architect and shall not be reproduced without the Architects written permission. These drawings are to be read in conjunction with the specifications, structural, mechanical and electrical drawings. This drawing must not be scaled. All dimensions, data and levels shall be verified before construction, and all errors or omissions reported immediately to the Architect.


P:\2020\20.118.257 Belleville DP Renewal\DP Renewal\ID Integrated Design\ID20 AutoCAD\ID22 Current\Sheets\A4.00\20.118.09-151-A4.05 STREETScape ELEVATIONS.dwg 2020/12/02 9:52 PM Iona Cunniff

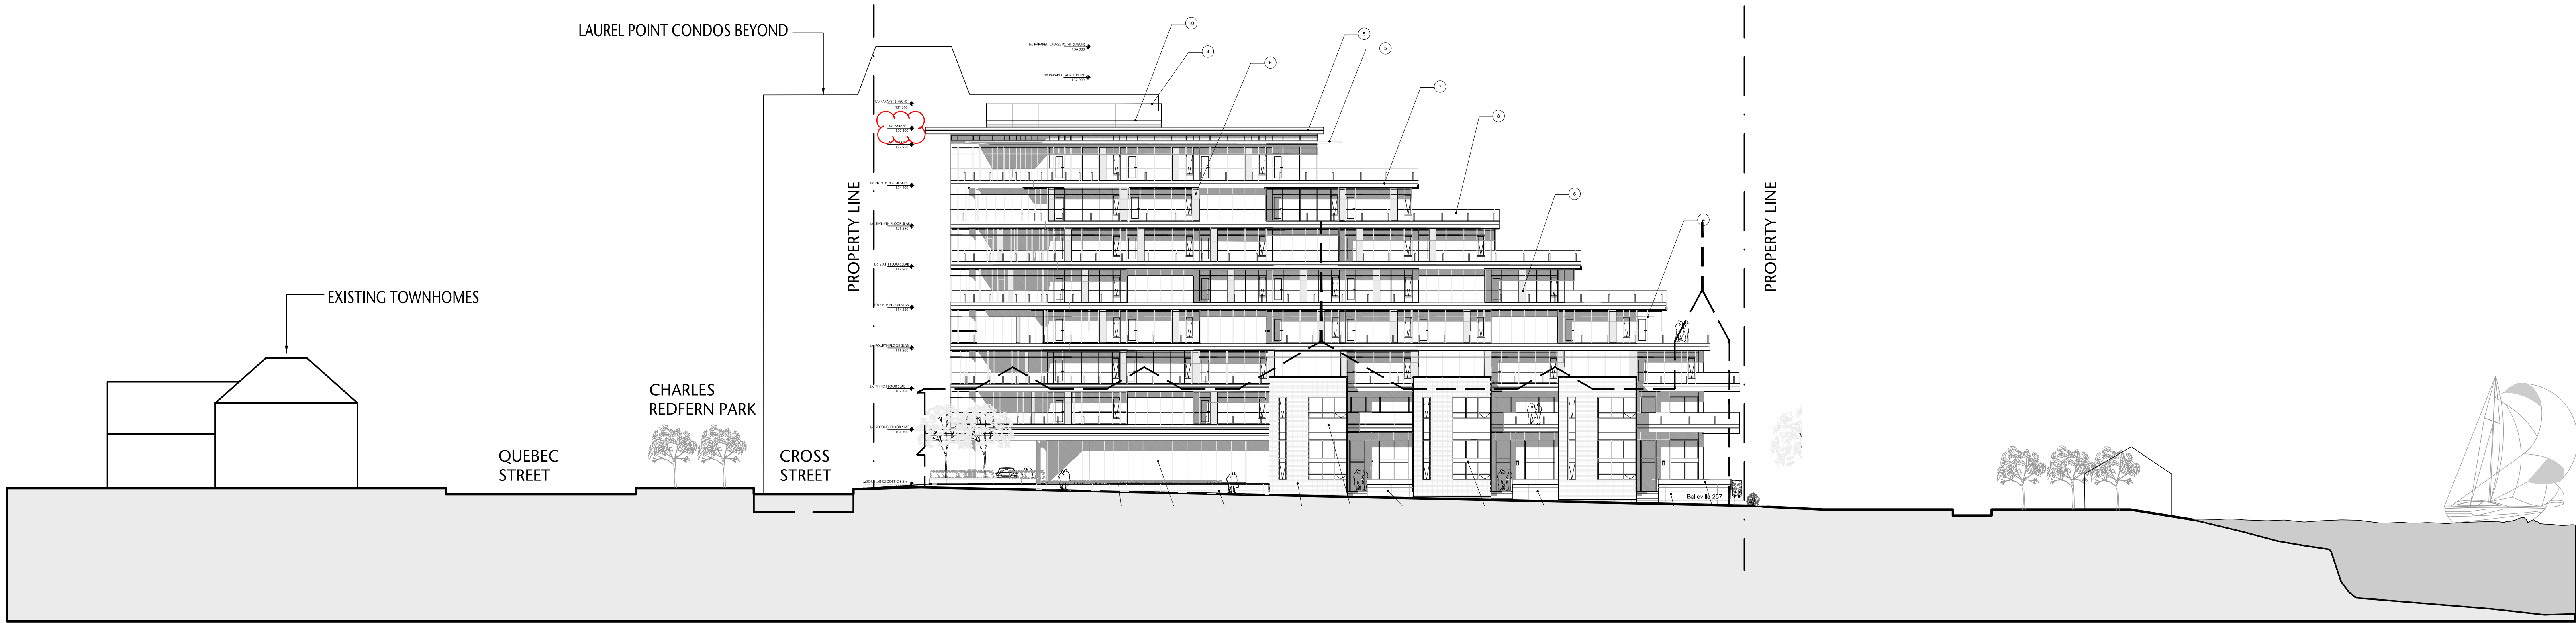

 1 STREETScape ELEVATION ALONG PENDRAY STREET
A4.05 1:250

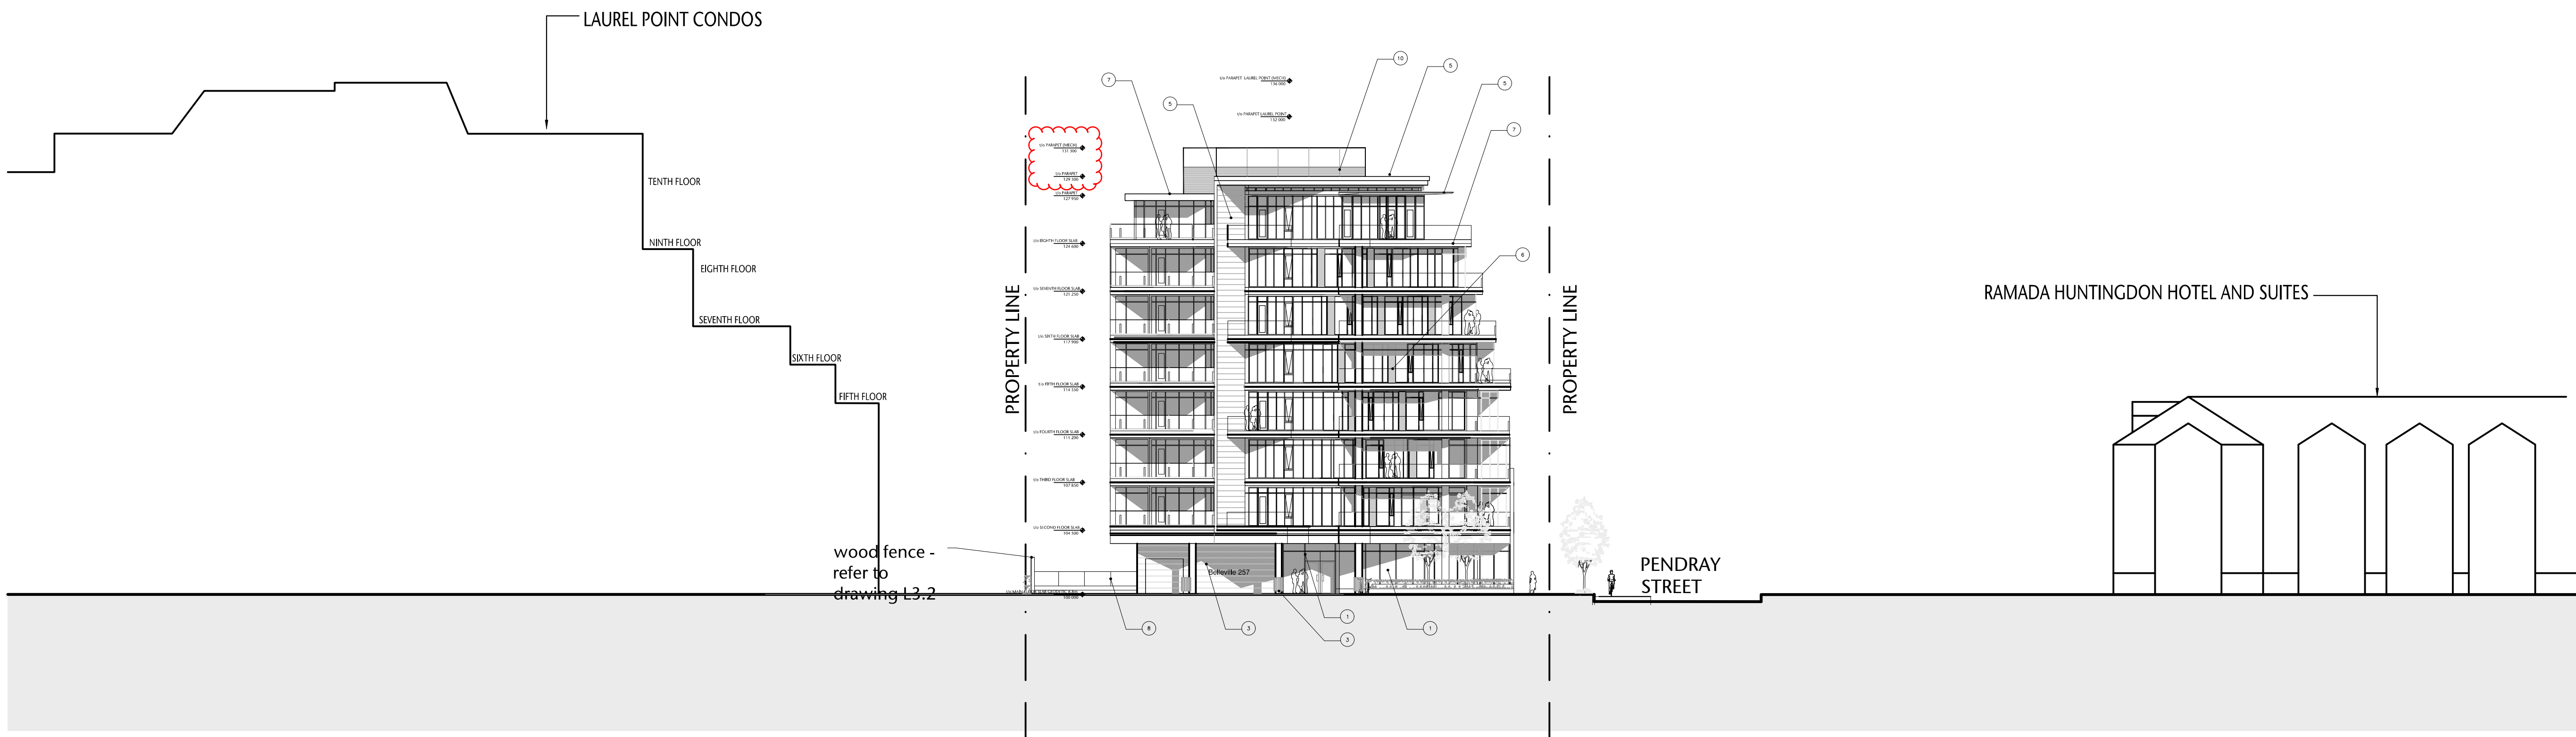

 2 STREETScape ELEVATION ALONG QUEBEC STREET
A4.05 1:250



257 BELLEVILLE STREET

VICTORIA, BRITISH COLUMBIA

no.	issued for	date
1	DEVELOPMENT PERMIT	OCT 23/2012
2	DEVELOPMENT PERMIT	MAR 16/2020
3	REISSUED DEVELOPMENT PERMIT	DEC 03/2020



consultant

alan lowe architect inc.

MTa CALGARY | EDMONTON
310, 625 - 11 Ave SW Calgary AB T2R 0E1
t. 403.264.8700
f. 403.264.8029


mtalink.com Urban Design Architecture Interior Design

drawing title
STREETScape ELEVATIONS

A4.05		sheet
drawn POR, DS	scale AS SHOWN	
checked DL	project no. 20.118	

COPYRIGHTED. This design is the exclusive property of the Architect and shall not be reproduced without the Architects written permission. These drawings are to be read in conjunction with the specifications, structural, mechanical and electrical drawings. This drawing must not be scaled. All dimensions, data and levels shall be verified before construction, and all errors or omissions reported immediately to the Architect.

P:\2020\20.118.257 Belleville DP Renewal\ID Integrated Design\ID20 AutoCAD\ID22 Current Sheets\AS 00\20.118.09-151-AS.02 BUILDING SECTIONS.dwg 2020/12/02 10:01 PM Iona Clunkiewicz

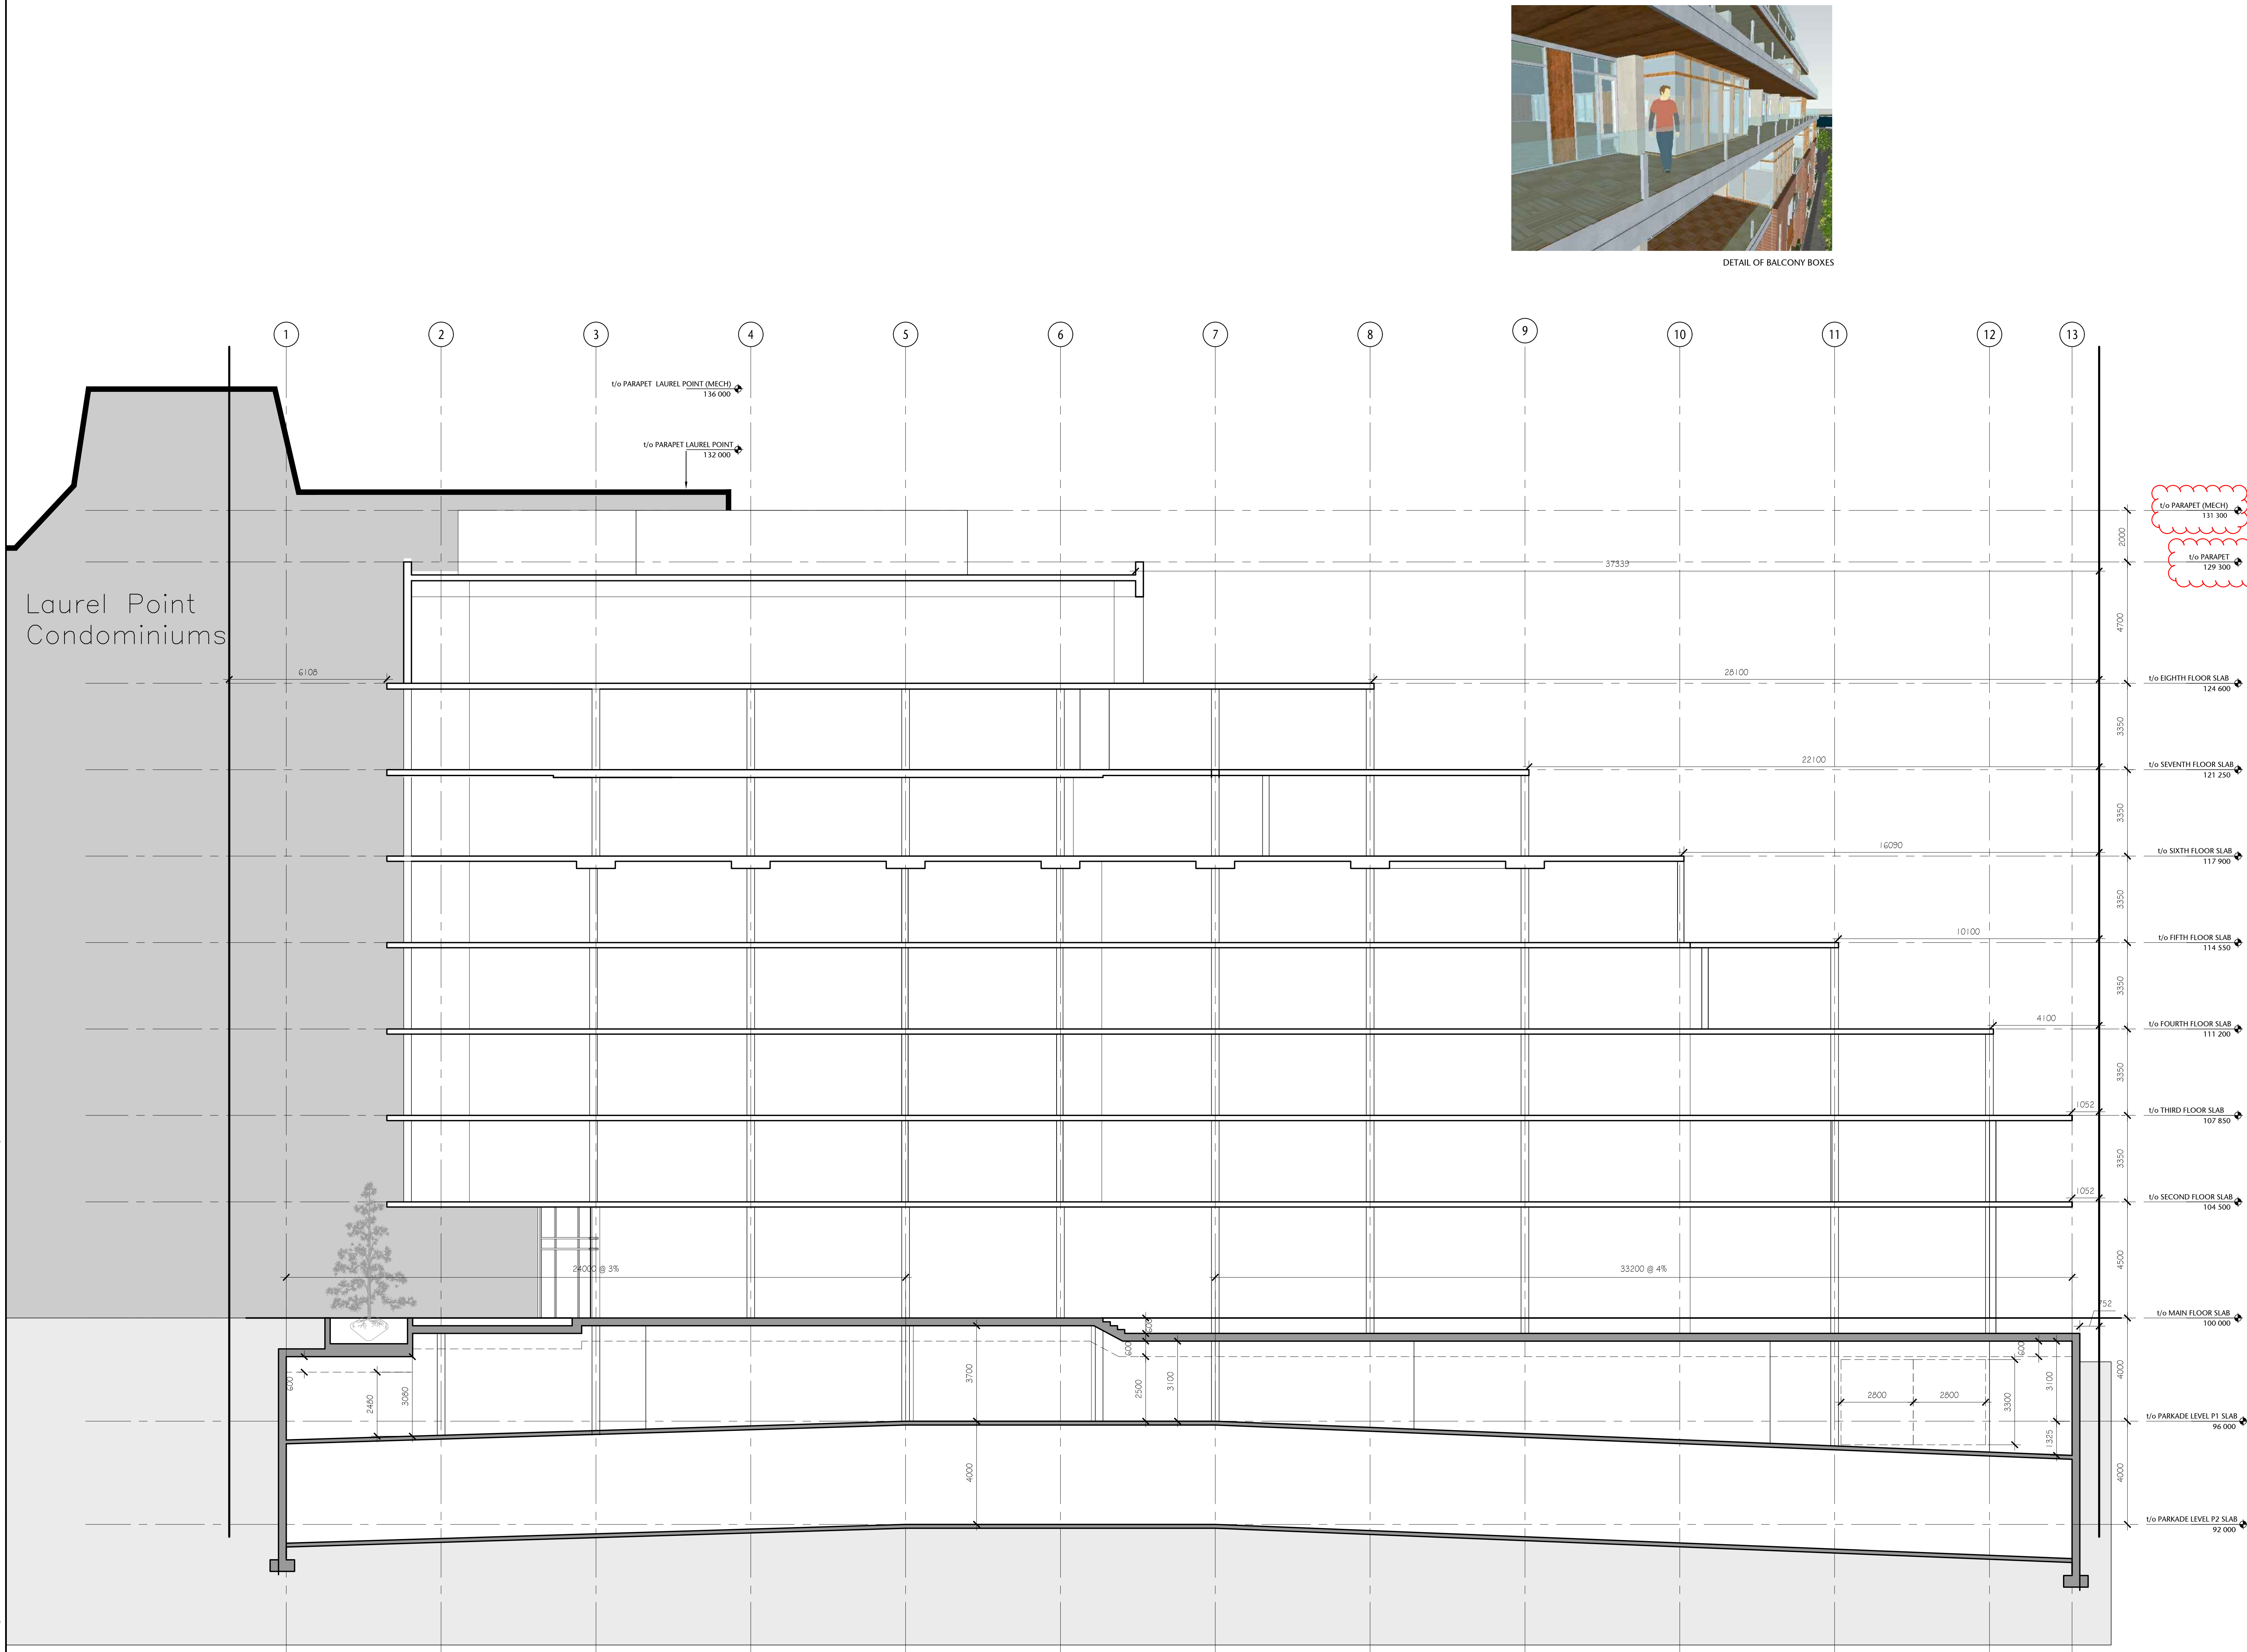

DETAIL OF BALCONY BOXES

1 BUILDING SECTION
AS.02 1:100

257 BELLEVILLE STREET

VICTORIA, BRITISH COLUMBIA

no.	issued for	date
1	DEVELOPMENT PERMIT	OCT 23/2012
2	DEVELOPMENT PERMIT	MAR 16/2020
3	REISSUED DEVELOPMENT PERMIT	DEC 03/2020



alan lowe architect inc.

MTa CALGARY | EDMONTON
310, 625 - 11 Ave SW Calgary AB T2R 0E1
t. 403.264.8700
f. 403.264.8029

mtalink.com Urban Design Architecture Interior Design

BUILDING SECTIONS

A5.02

PO, DS, DL	AS SHOWN
checked	project no.
DL	20.118